

Client	client
--------	--------

**PUBLIC SERVICES
AND PROCUREMENT
CANADA**

Project	Project
---------	---------

**ACTIVITY BASED
WORKPLACE FIT-UP
269 MAIN STREET**

Designed by	Con?u par
-------------	-----------

Drawn by	Dessin? por
----------	-------------


Approved by	Approuvé par
-------------	--------------

PWGSC Project Manager
JOHN ALIBIN

Drawing title	Titre du dessin
---------------	-----------------

THIRD FLOOR PLAN LIGHTING

Project no./No. du projet	Drawing no./No. du dessin	Revision no.
R.067379	EL2.0 2 OF 9	0

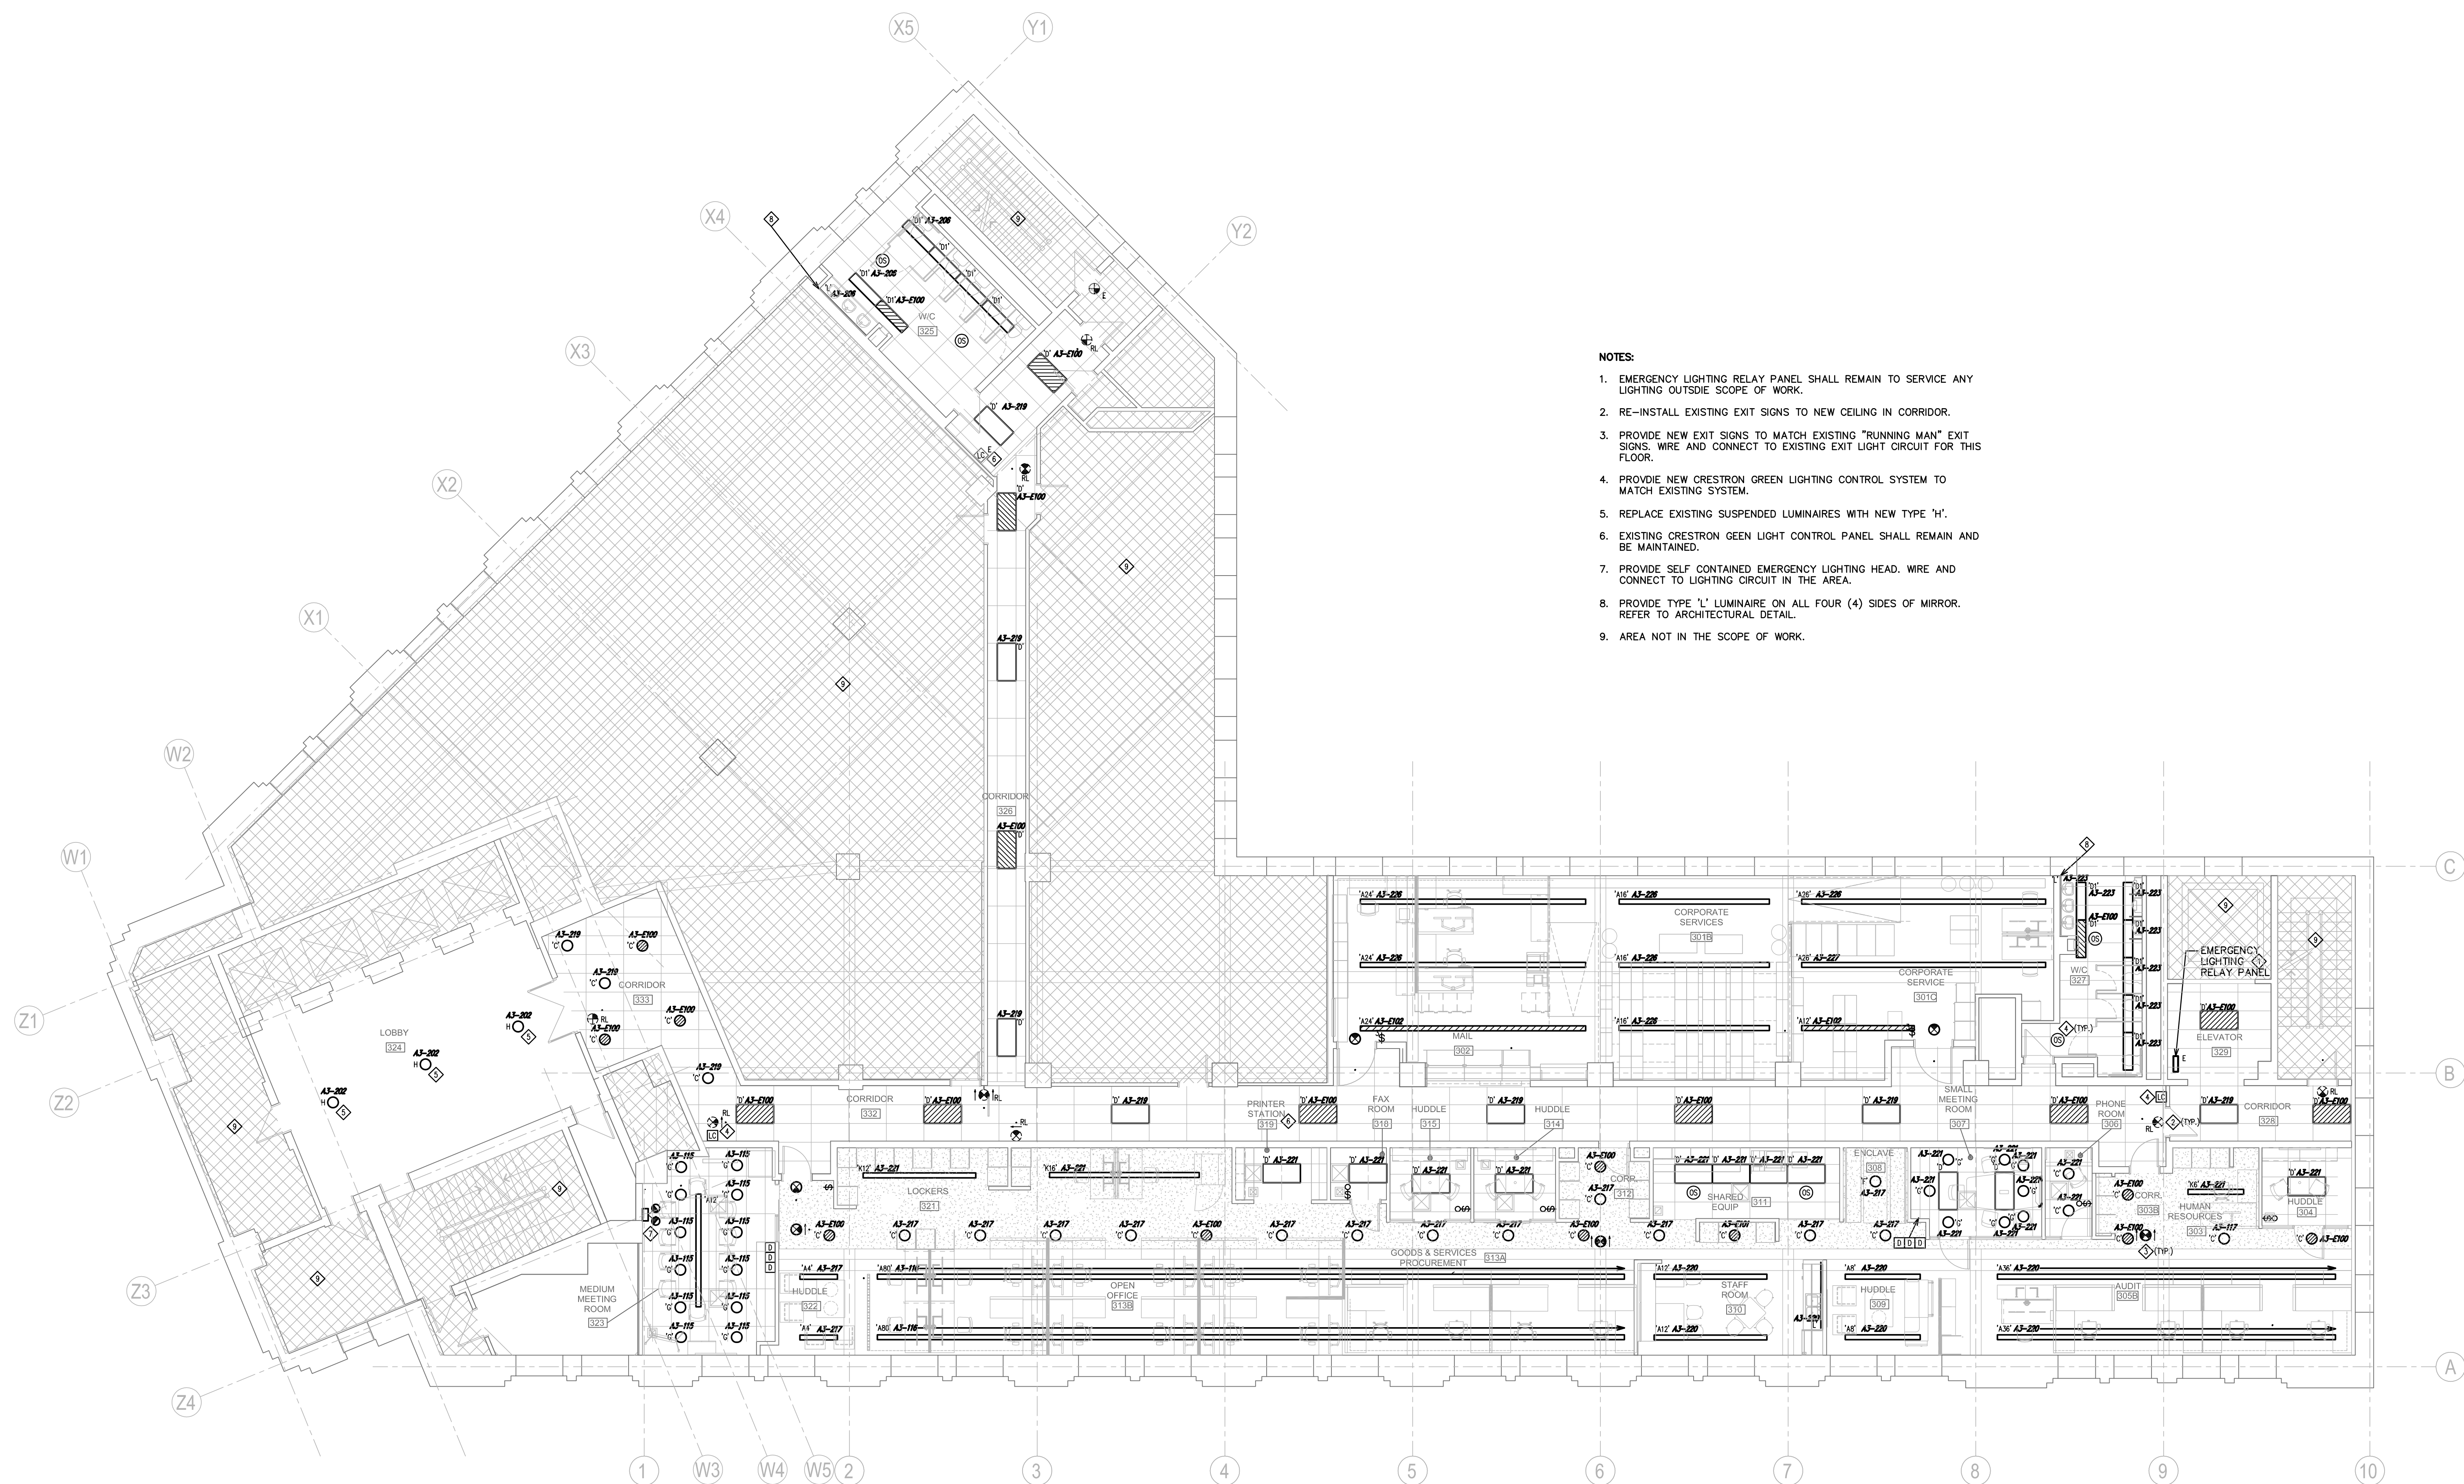

1 THIRD FLOOR PLAN – LIGHTING
EL2.0 SCALE: 1:100