



FAN WIRING DIAGRAM

1
ME3

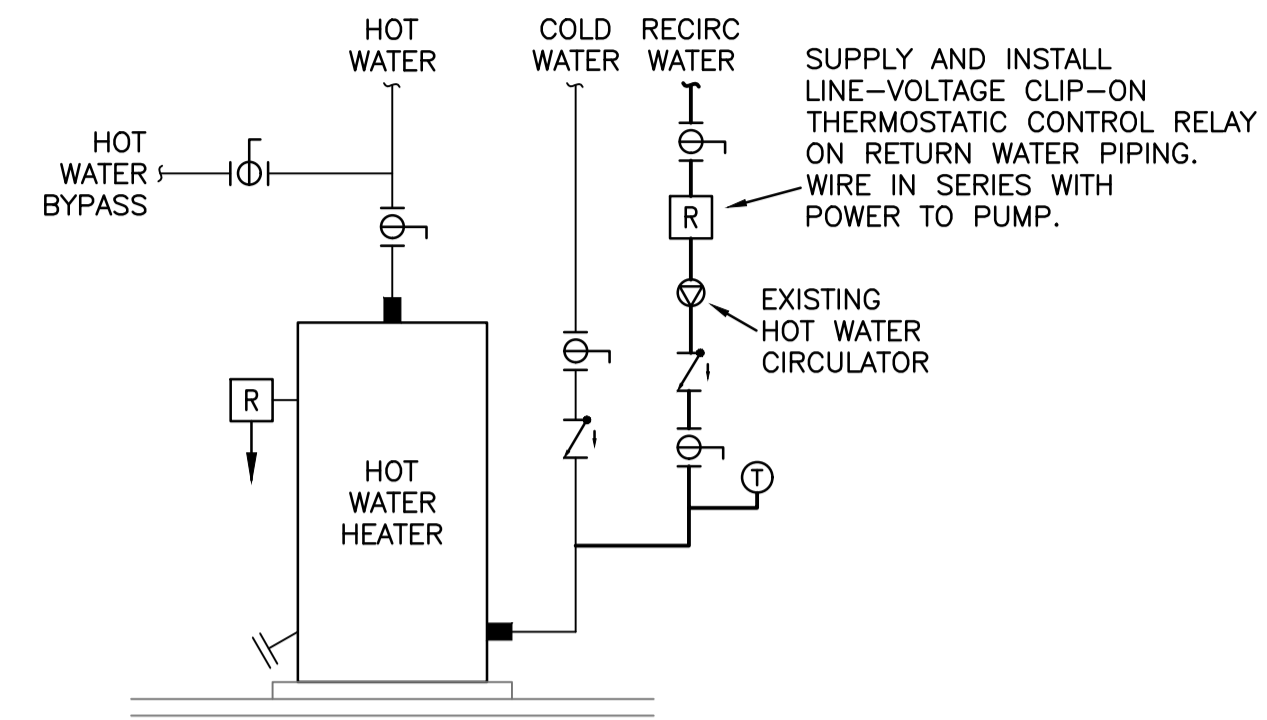

EXISTING HOT WATER HEATER SCHEMATIC

2
ME3


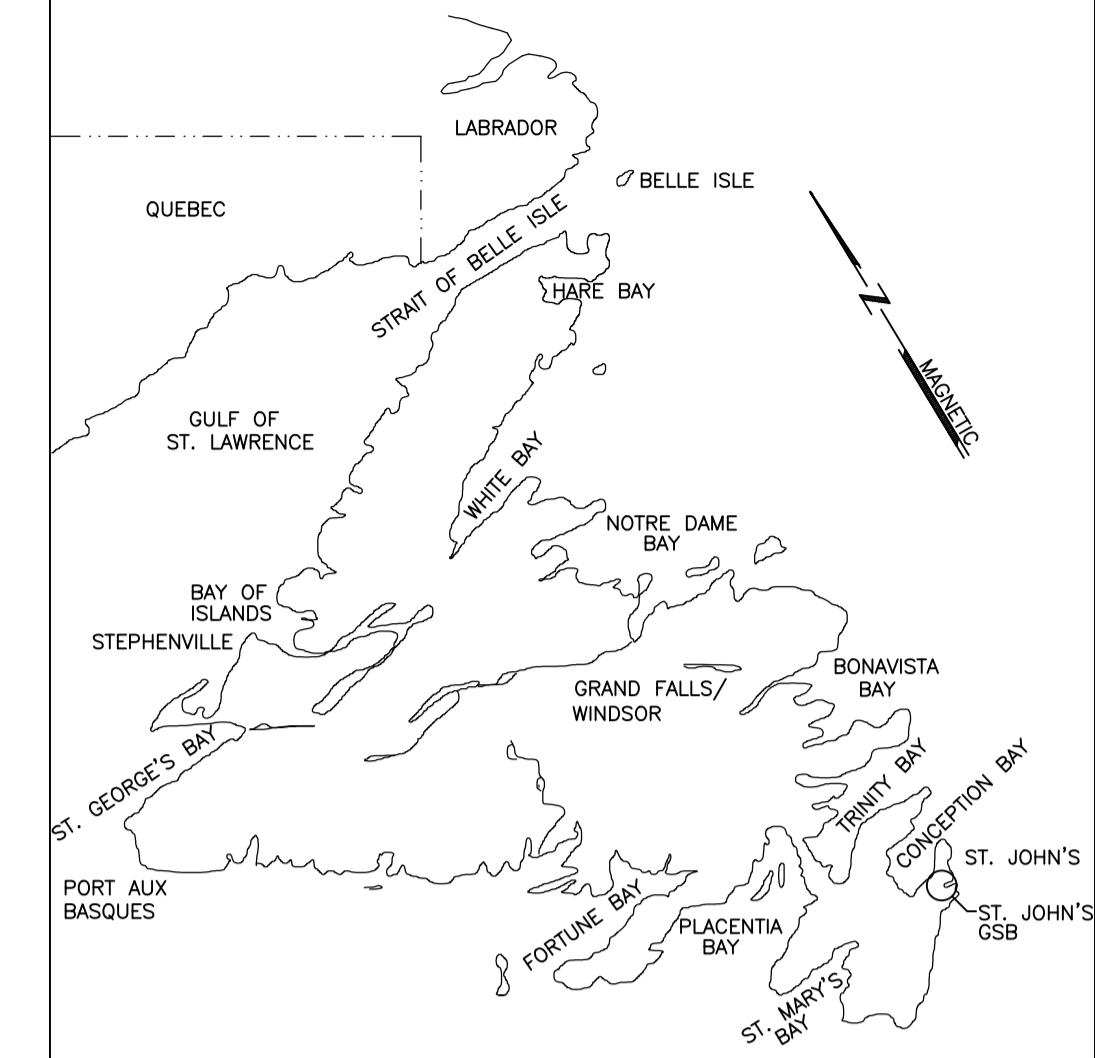


KEY LOCATION PLAN

M. LAWRENCE ENGINEERING LTD
Consulting Engineers
HALIFAX NS
902-222-5364
WWW.MLENGINEERING.CA


CONSULTANT

STAMP

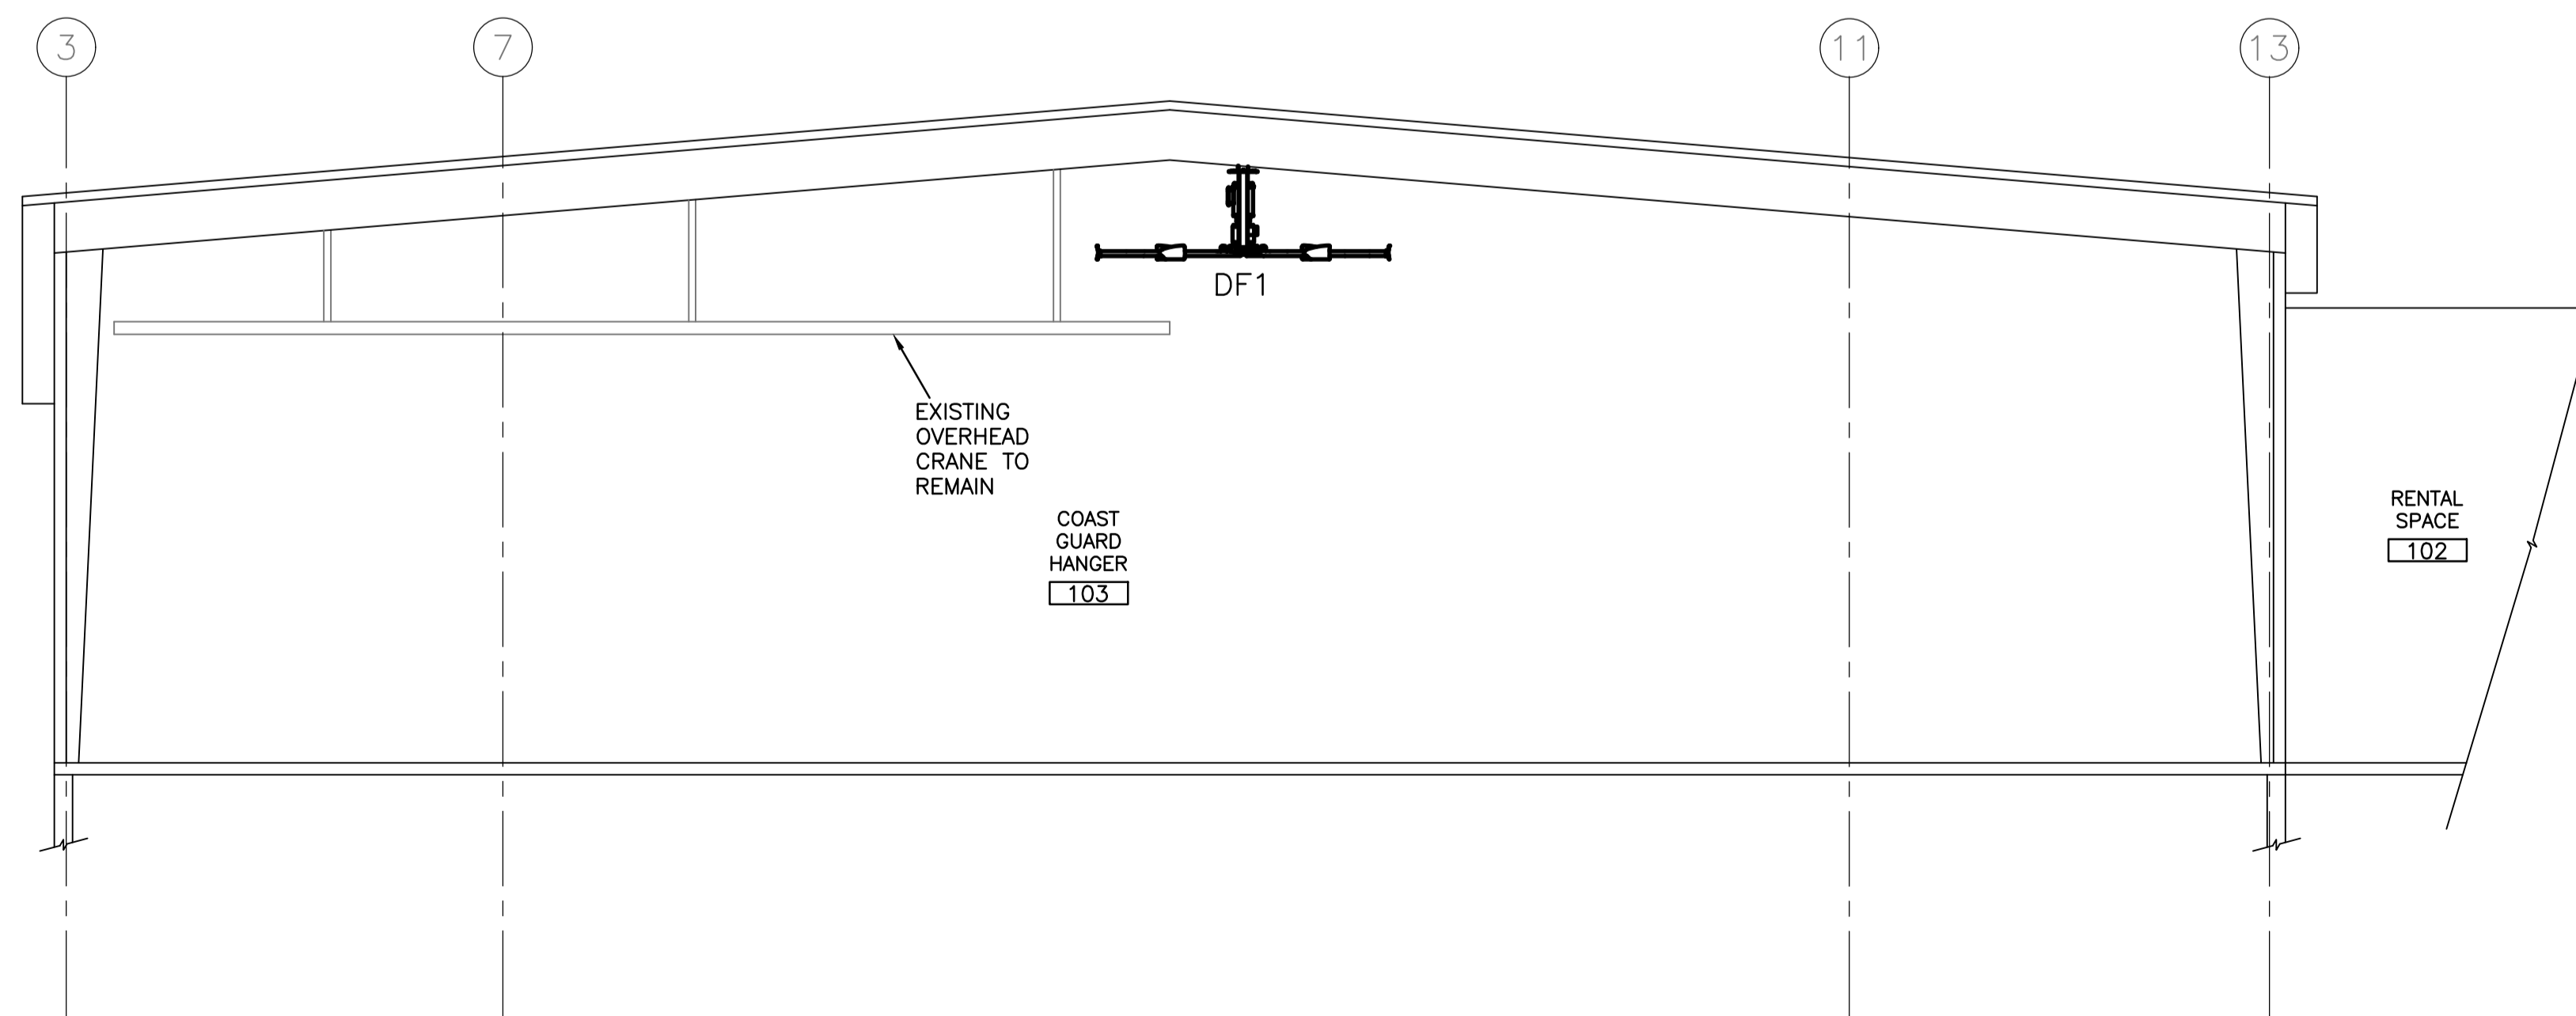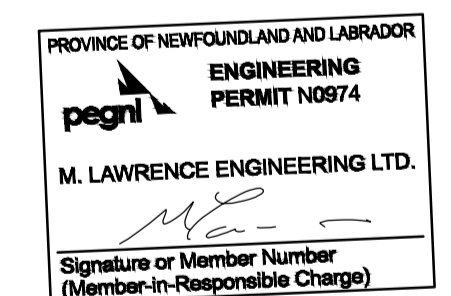

MECHANICAL - CROSS SECTION

 SCALE : 1:100



3
ME3

1	ISSUED FOR TENDER	19/01/21	M.L.	M.L.
no.	revision	date	by	approved
no.	revision	date	par	approuve

Project - projet
ST. JOHN'S GSB - GREENING OF GOVERNMENT OPERATIONS

Drawing - dessin
NEW MECHANICAL DETAILS

drawn - dessine H. OSBORNE	designed - dessine par M. LAWRENCE
date - date SEPTEMBER 2018	checked - verifie M. LAWRENCE
scale - echelle AS SHOWN	approved for tender - approuve pour l'offre

project no. - projet no. F6879-189230	drawing no. - no du dessin 01N1001H026	sheet - feuille ME-3
--	---	-------------------------