




Public Works  
Government Services  
Canada

Travaux publics  
Services gouvernementaux  
Canada


BURLINGTON, ONTARIO.  
BURLINGTON CANAL LIFT BRIDGE (BCLB)  
1157 BEACH BOULEVARD  
BARRIER FREE WASHROOM RETROFIT  
PWGSC Proj. No.: R.089504.120      DATE: 2019-02-11

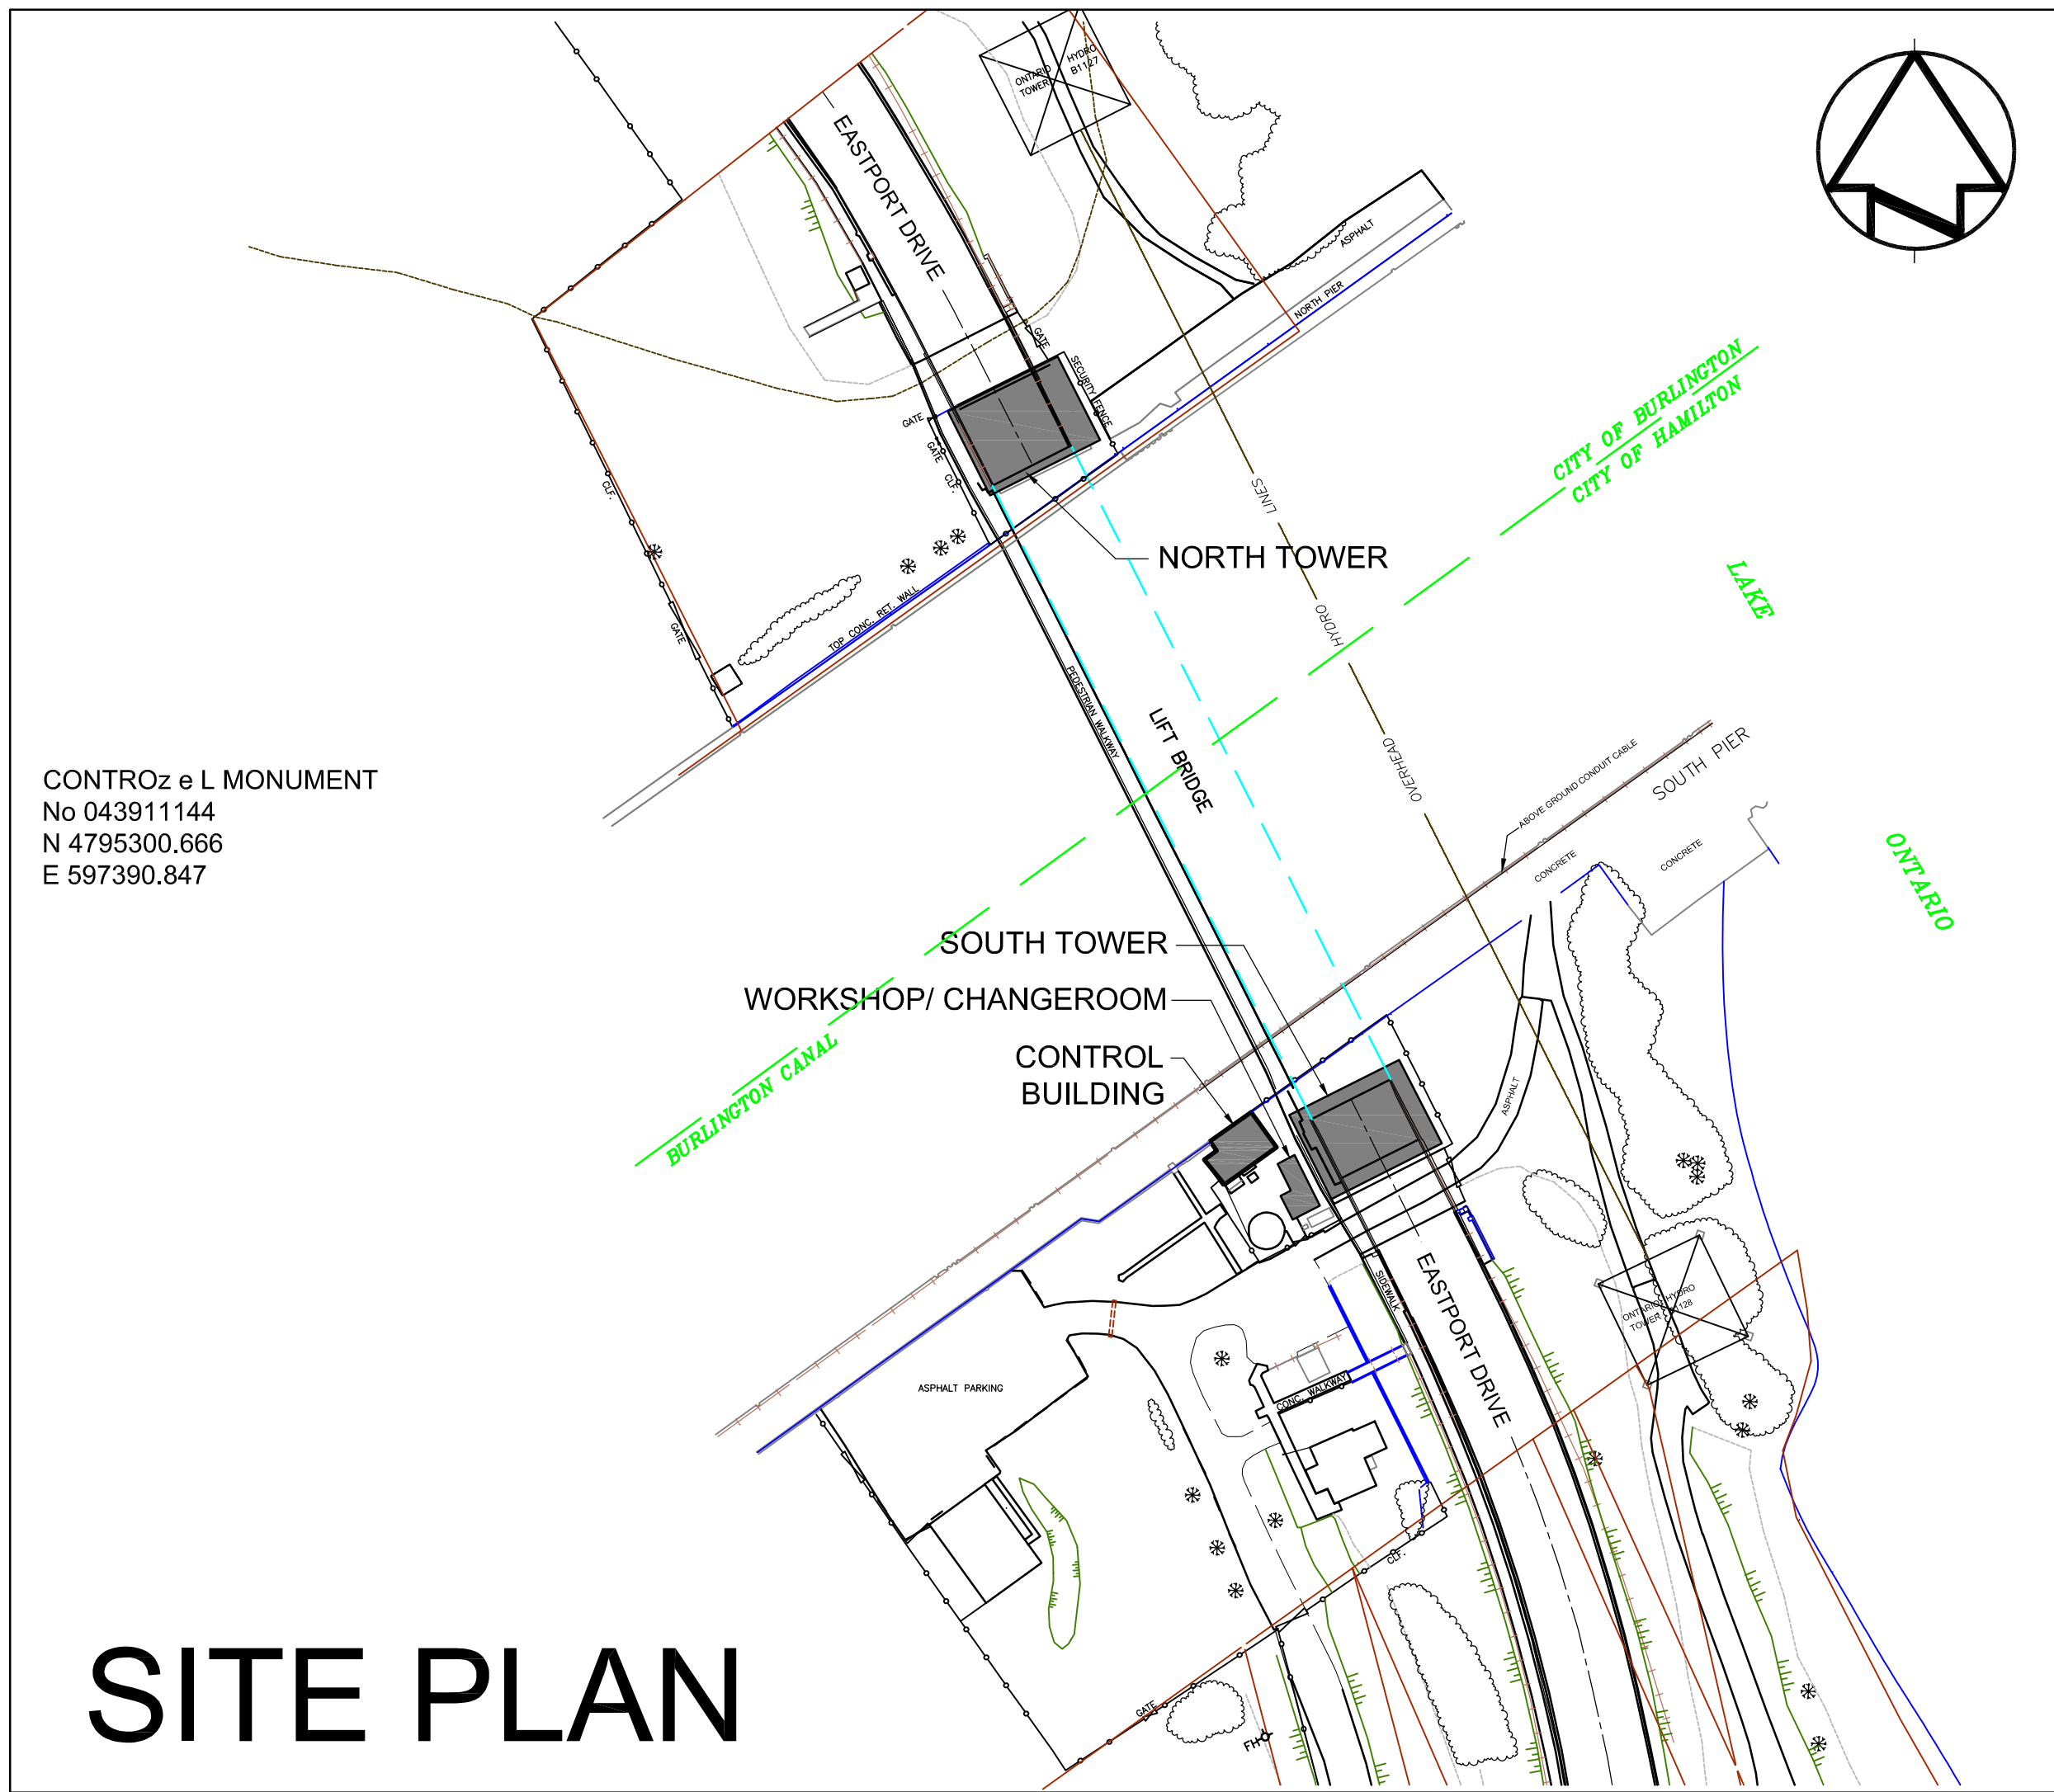

LIST OF DRAWINGS

ARCHITECTURAL

- A-01 COVER PAGE
- A-02 LEGEND & ABBREVIATIONS
- A-03 FLOOR PLAN - DEMOLITION
- A-04 FLOOR PLAN
- A-05 ELEVATIONS
- A-06 DETAILS
- E-01 ELECTRICAL
- M-01 MECHANICAL

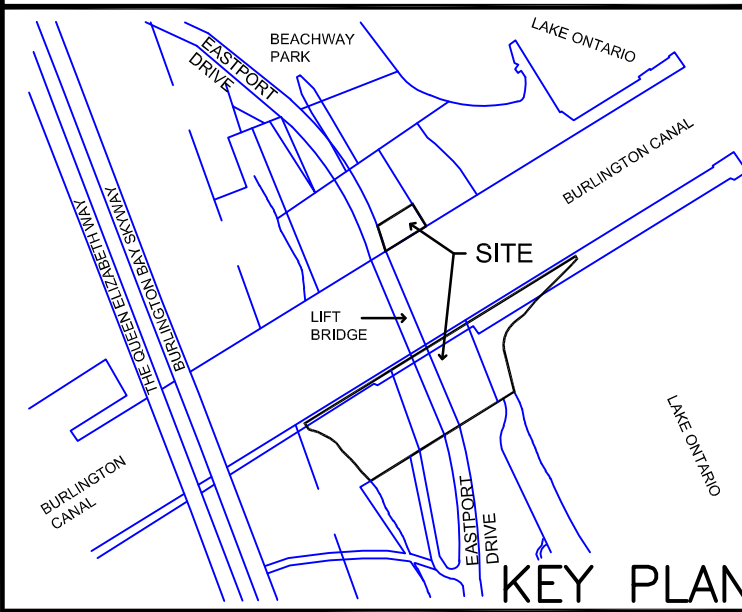

Consultant:

**MORRISON HERSHFIELD**  
Suite 300 – 125 Commerce Valley Drive W  
Markham, Ontario L3T 7W4  
Tel: 416-499-3110 Fax: 416-499-9658



revision	description	date
2	ISSUED FOR PRICING	2019/02/21
1	ISSUED FOR DESIGN REVIEW	2019/02/11

Do not scale drawings.  
Verify all dimensions and conditions on site and immediately  
notify the Departmental Representative of all discrepancies.

A	Detail No.
B	drawing no. – where detail required
C	drawing no. – where detailed

project title  
titre du projet  
**BURLINGTON CANAL LIFT BRIDGE (BCLB)**  
1157 BEACH BOULEVARD

**BARRIER-FREE WASHROOM  
RETROFIT**

drawing title  
titre du dessin  
**COVER PAGE**

drawn by  
dessiné par  
**BP**

designed by  
conçu par  
**AH**

approved by  
approuvé par  
**—**

bid  
soumission  
**—**

project date  
date du projet  
**2019-02-11**



project no.  
no. du projet  
**R.089504.120**

drawing no.  
dessiné no.  
**A-01**







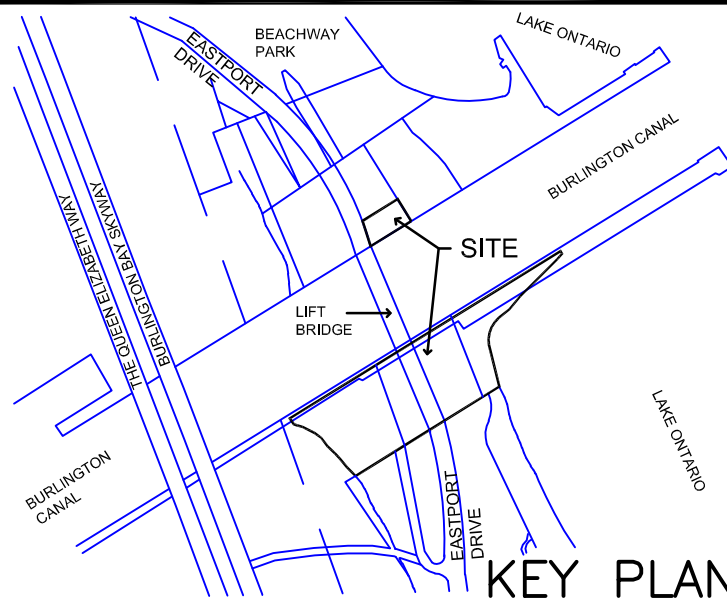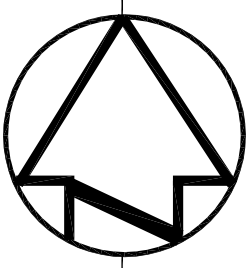

Consultant:

**MORRISON HERSHFIELD**  
Suite 300 – 125 Commerce Valley Drive W  
Markham, Ontario L3T 7W4  
Tel: 416-499-3110 Fax: 416-499-9658



revision	description	date
2	ISSUED FOR PRICING	2019/02/21
1	ISSUED FOR DESIGN REVIEW	2019/02/11

Do not scale drawings.  
Verify all dimensions and conditions on site and immediately  
notify the Departmental Representative of all discrepancies.

<div><div>A</div><div>B</div><div>C</div></div>	<div>A Detail No. No. du détail</div> <div>B drawing no. – where detail required dessin no. – où détail exigé</div> <div>C drawing no. – where detailed dessin no. – où détaillé</div>
---	--

project title  
titre du projet  
**BURLINGTON ONTARIO**  
**BURLINGTON CANAL LIFT BRIDGE (BCLB)**  
**1157 BEACH BOULEVARD**

**BARRIER-FREE WASHROOM  
RETROFIT**

drawing title  
titre du dessin  
**BARRIER FREE WASHROOM  
RETROFIT  
FLOOR PLAN- DEMOLITION**

drawn by  
dessiné par  
**AAA**

designed by  
conçue par  
**AAA**

approved by  
approuvé par  
**-**


bid  
soumission  
**-**

project manager  
administrateur  
de projets



project date  
date du projet  
**2019-02-11**

project no.  
no. du projet  
**R.089504.120**

drawing no.  
dessiné no.  
**A-03**

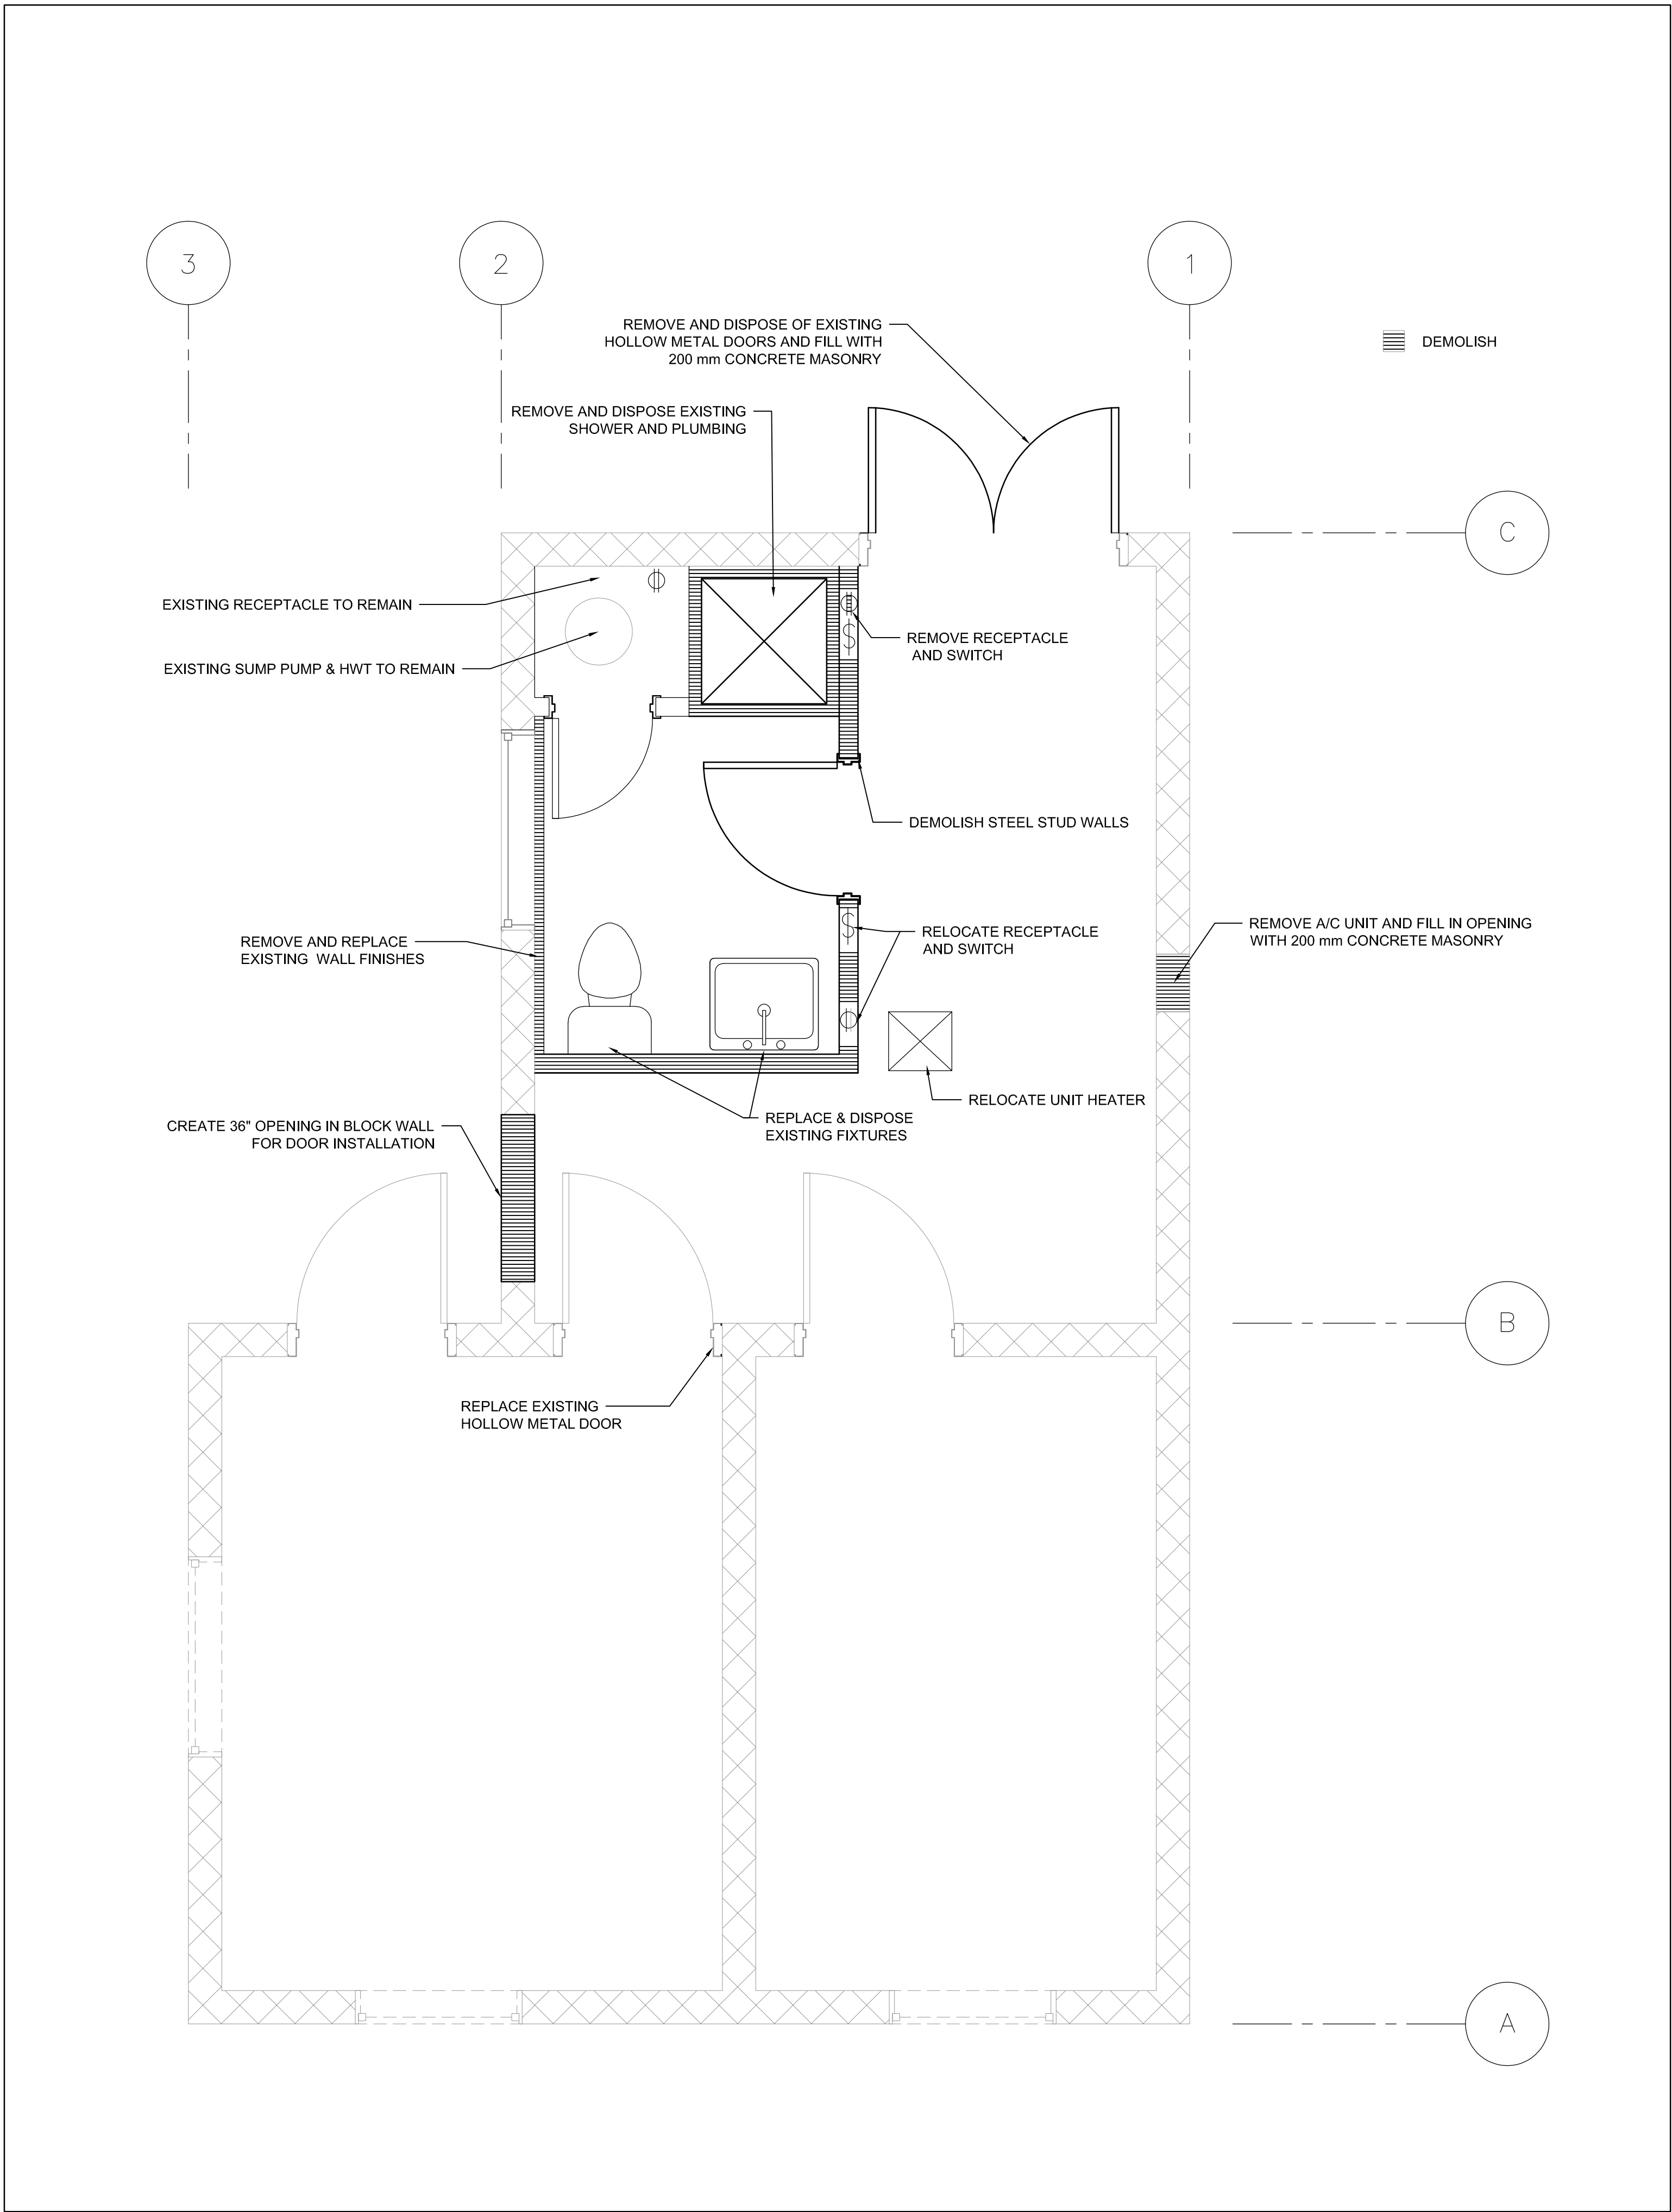

**1 DEMOLITION PLAN**  
A-03 1:25  
0 0.25m 1.5m 2.5m

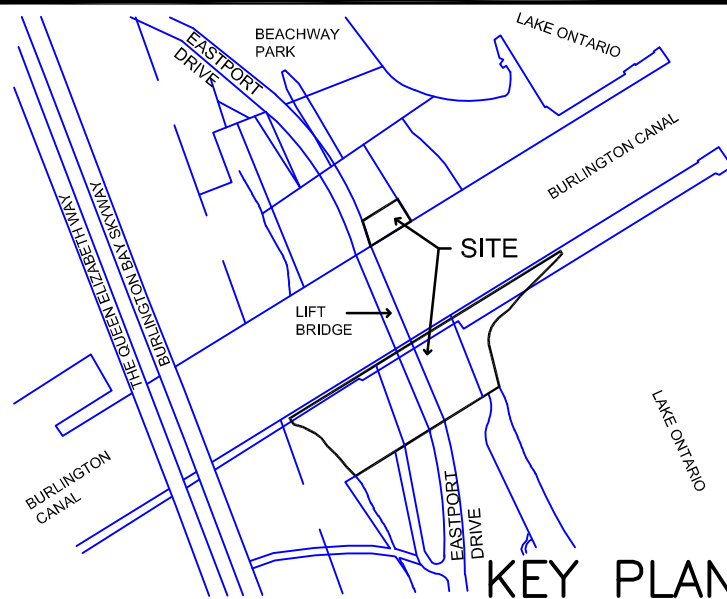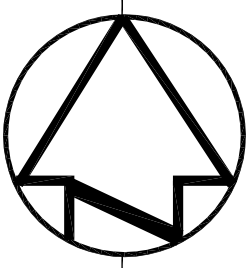

Consultant:

**MORRISON HERSHFIELD**  
Suite 300 – 125 Commerce Valley Drive W  
Markham, Ontario L3T 7W4  
Tel: 416-499-3110 Fax: 416-499-9658



revision	description	date
2	ISSUED FOR PRICING	2019/02/29
1	ISSUED FOR DESIGN REVIEW	2019/02/11

Do not scale drawings.  
Verify all dimensions and conditions on site and immediately  
notify the Departmental Representative of all discrepancies.

A	Detail No.
B	No. du détail
C	drawing no. – where detail required dessin no. – où détail exigé
	drawing no. – where detailed dessin no. – où détaillé

project title  
titre du projet  
**BURLINGTON** ONTARIO  
**BURLINGTON CANAL LIFT BRIDGE (BCLB)**  
**1157 BEACH BOULEVARD**

**BARRIER-FREE WASHROOM  
RETROFIT**

drawing title  
titre du dessin  
**BARRIER FREE WASHROOM  
RETROFIT  
FLOOR PLAN**

drawn by  
dessiné par  
**AAA**

designed by  
conc par  
**AAA**

approved by  
approuvé par  
**—**



bid  
soumission  
**—**

project manager  
administrateur  
de projets









project date  
date du projet  
**2019-02-11**

project no.  
no. du projet  
**R.089504.120**

drawing no.  
dessiné no.  
**A-04**

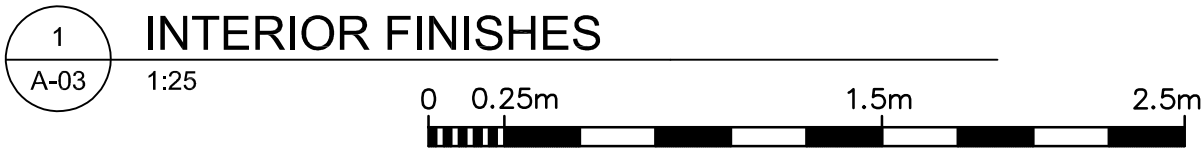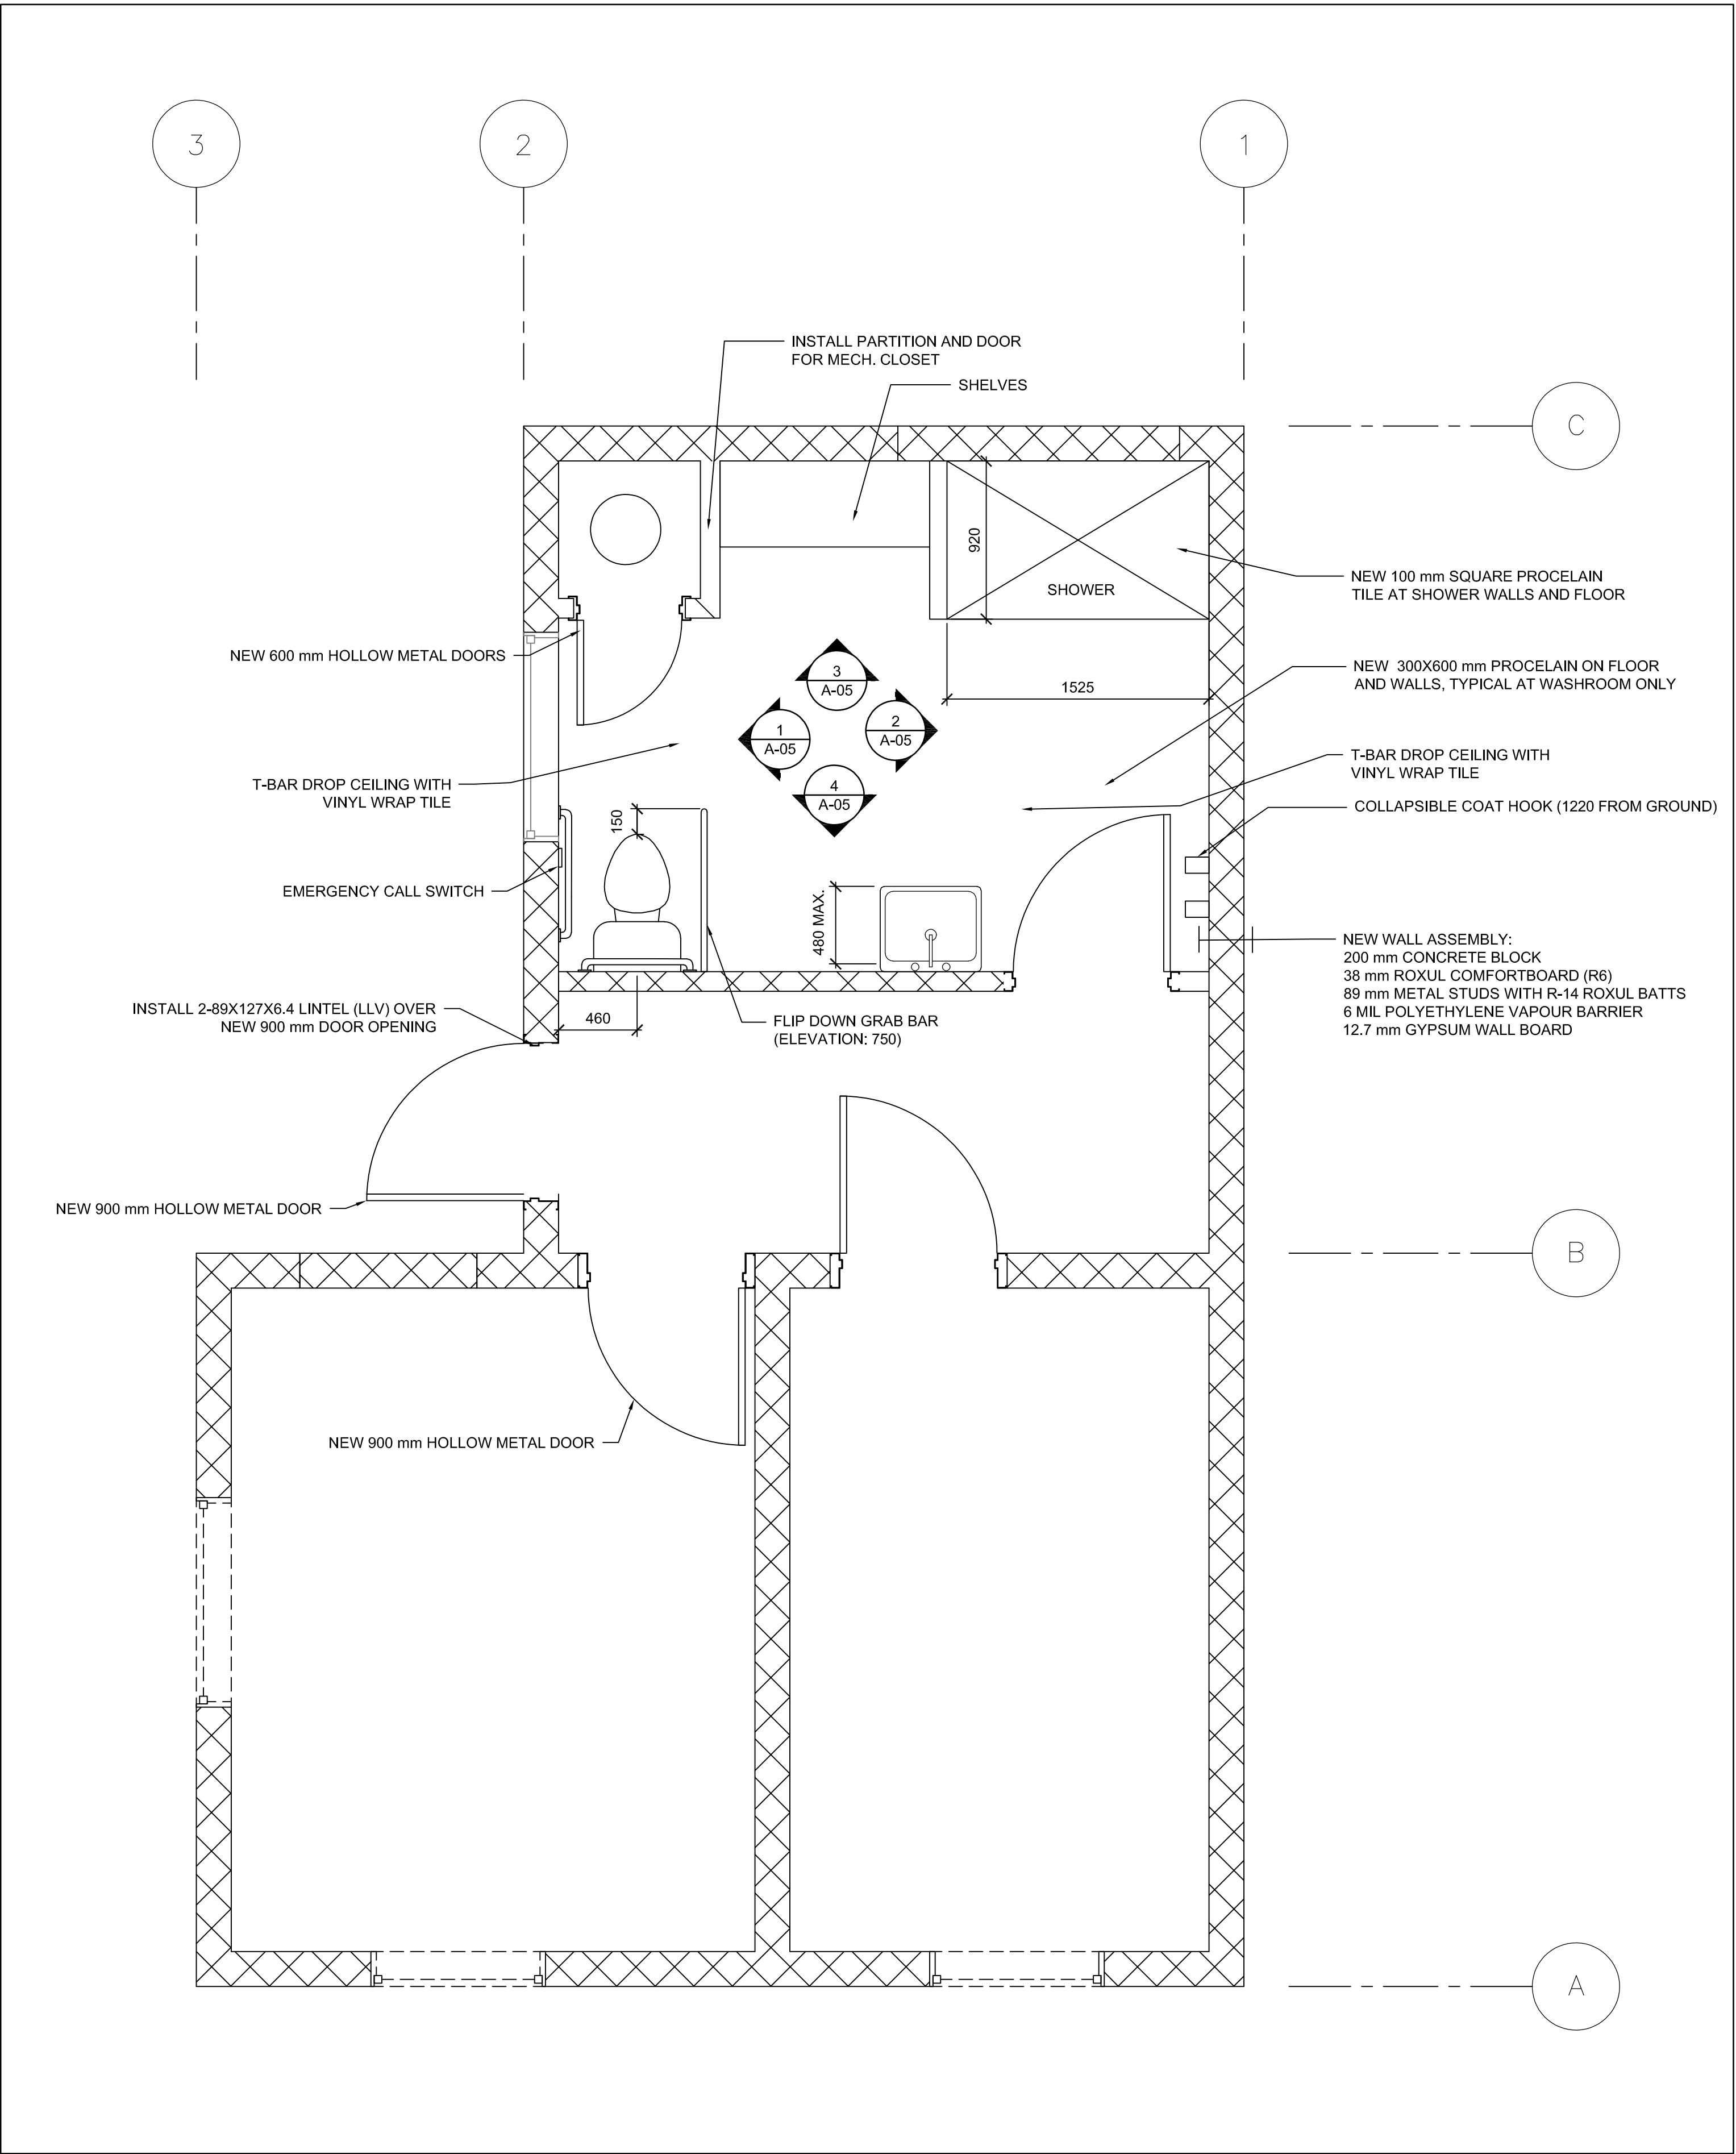



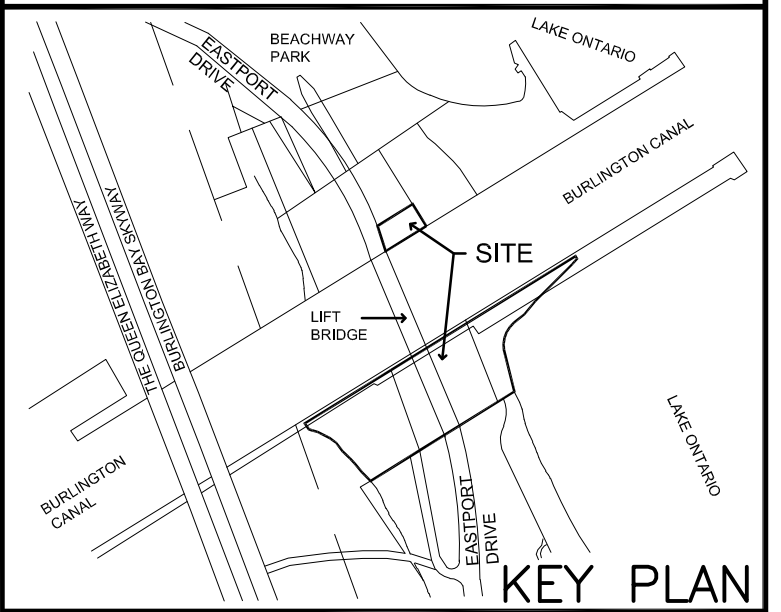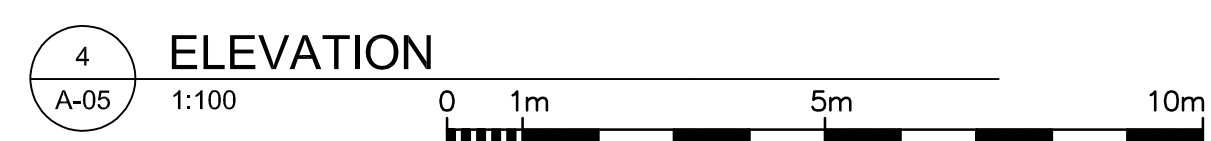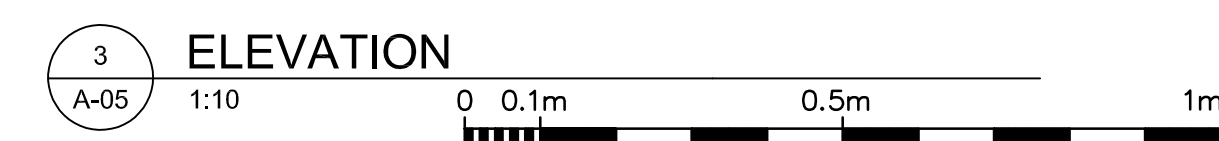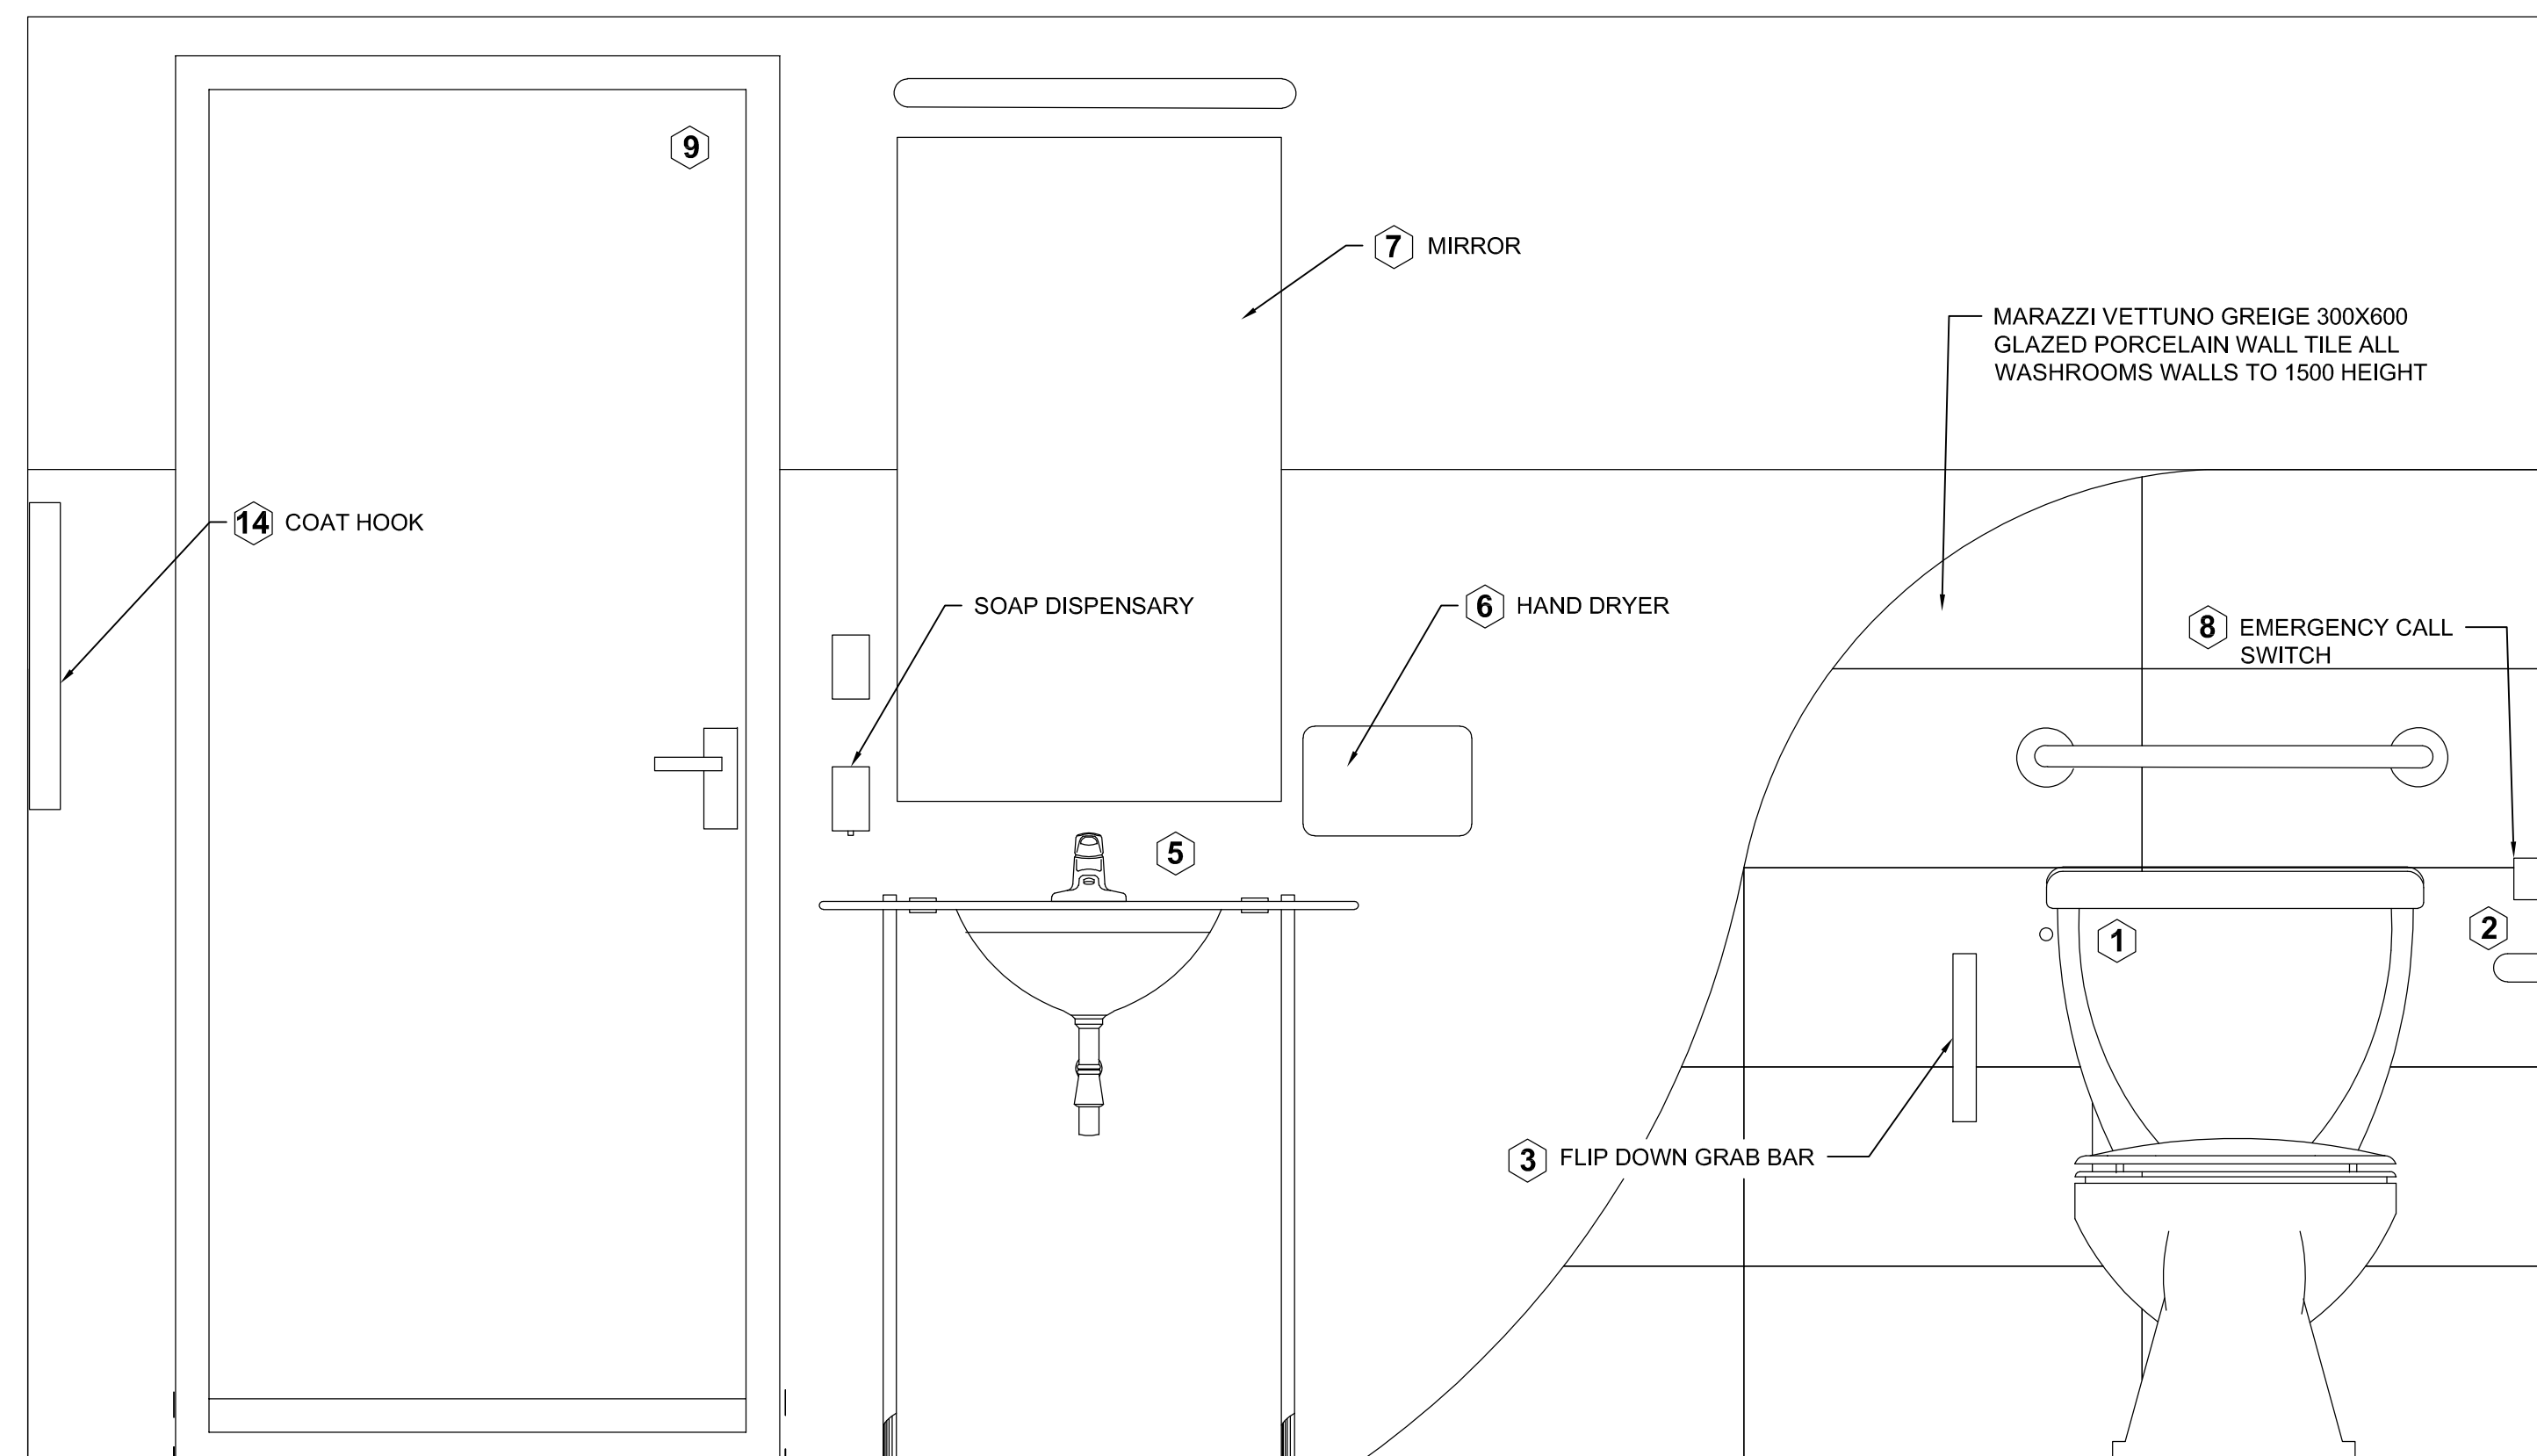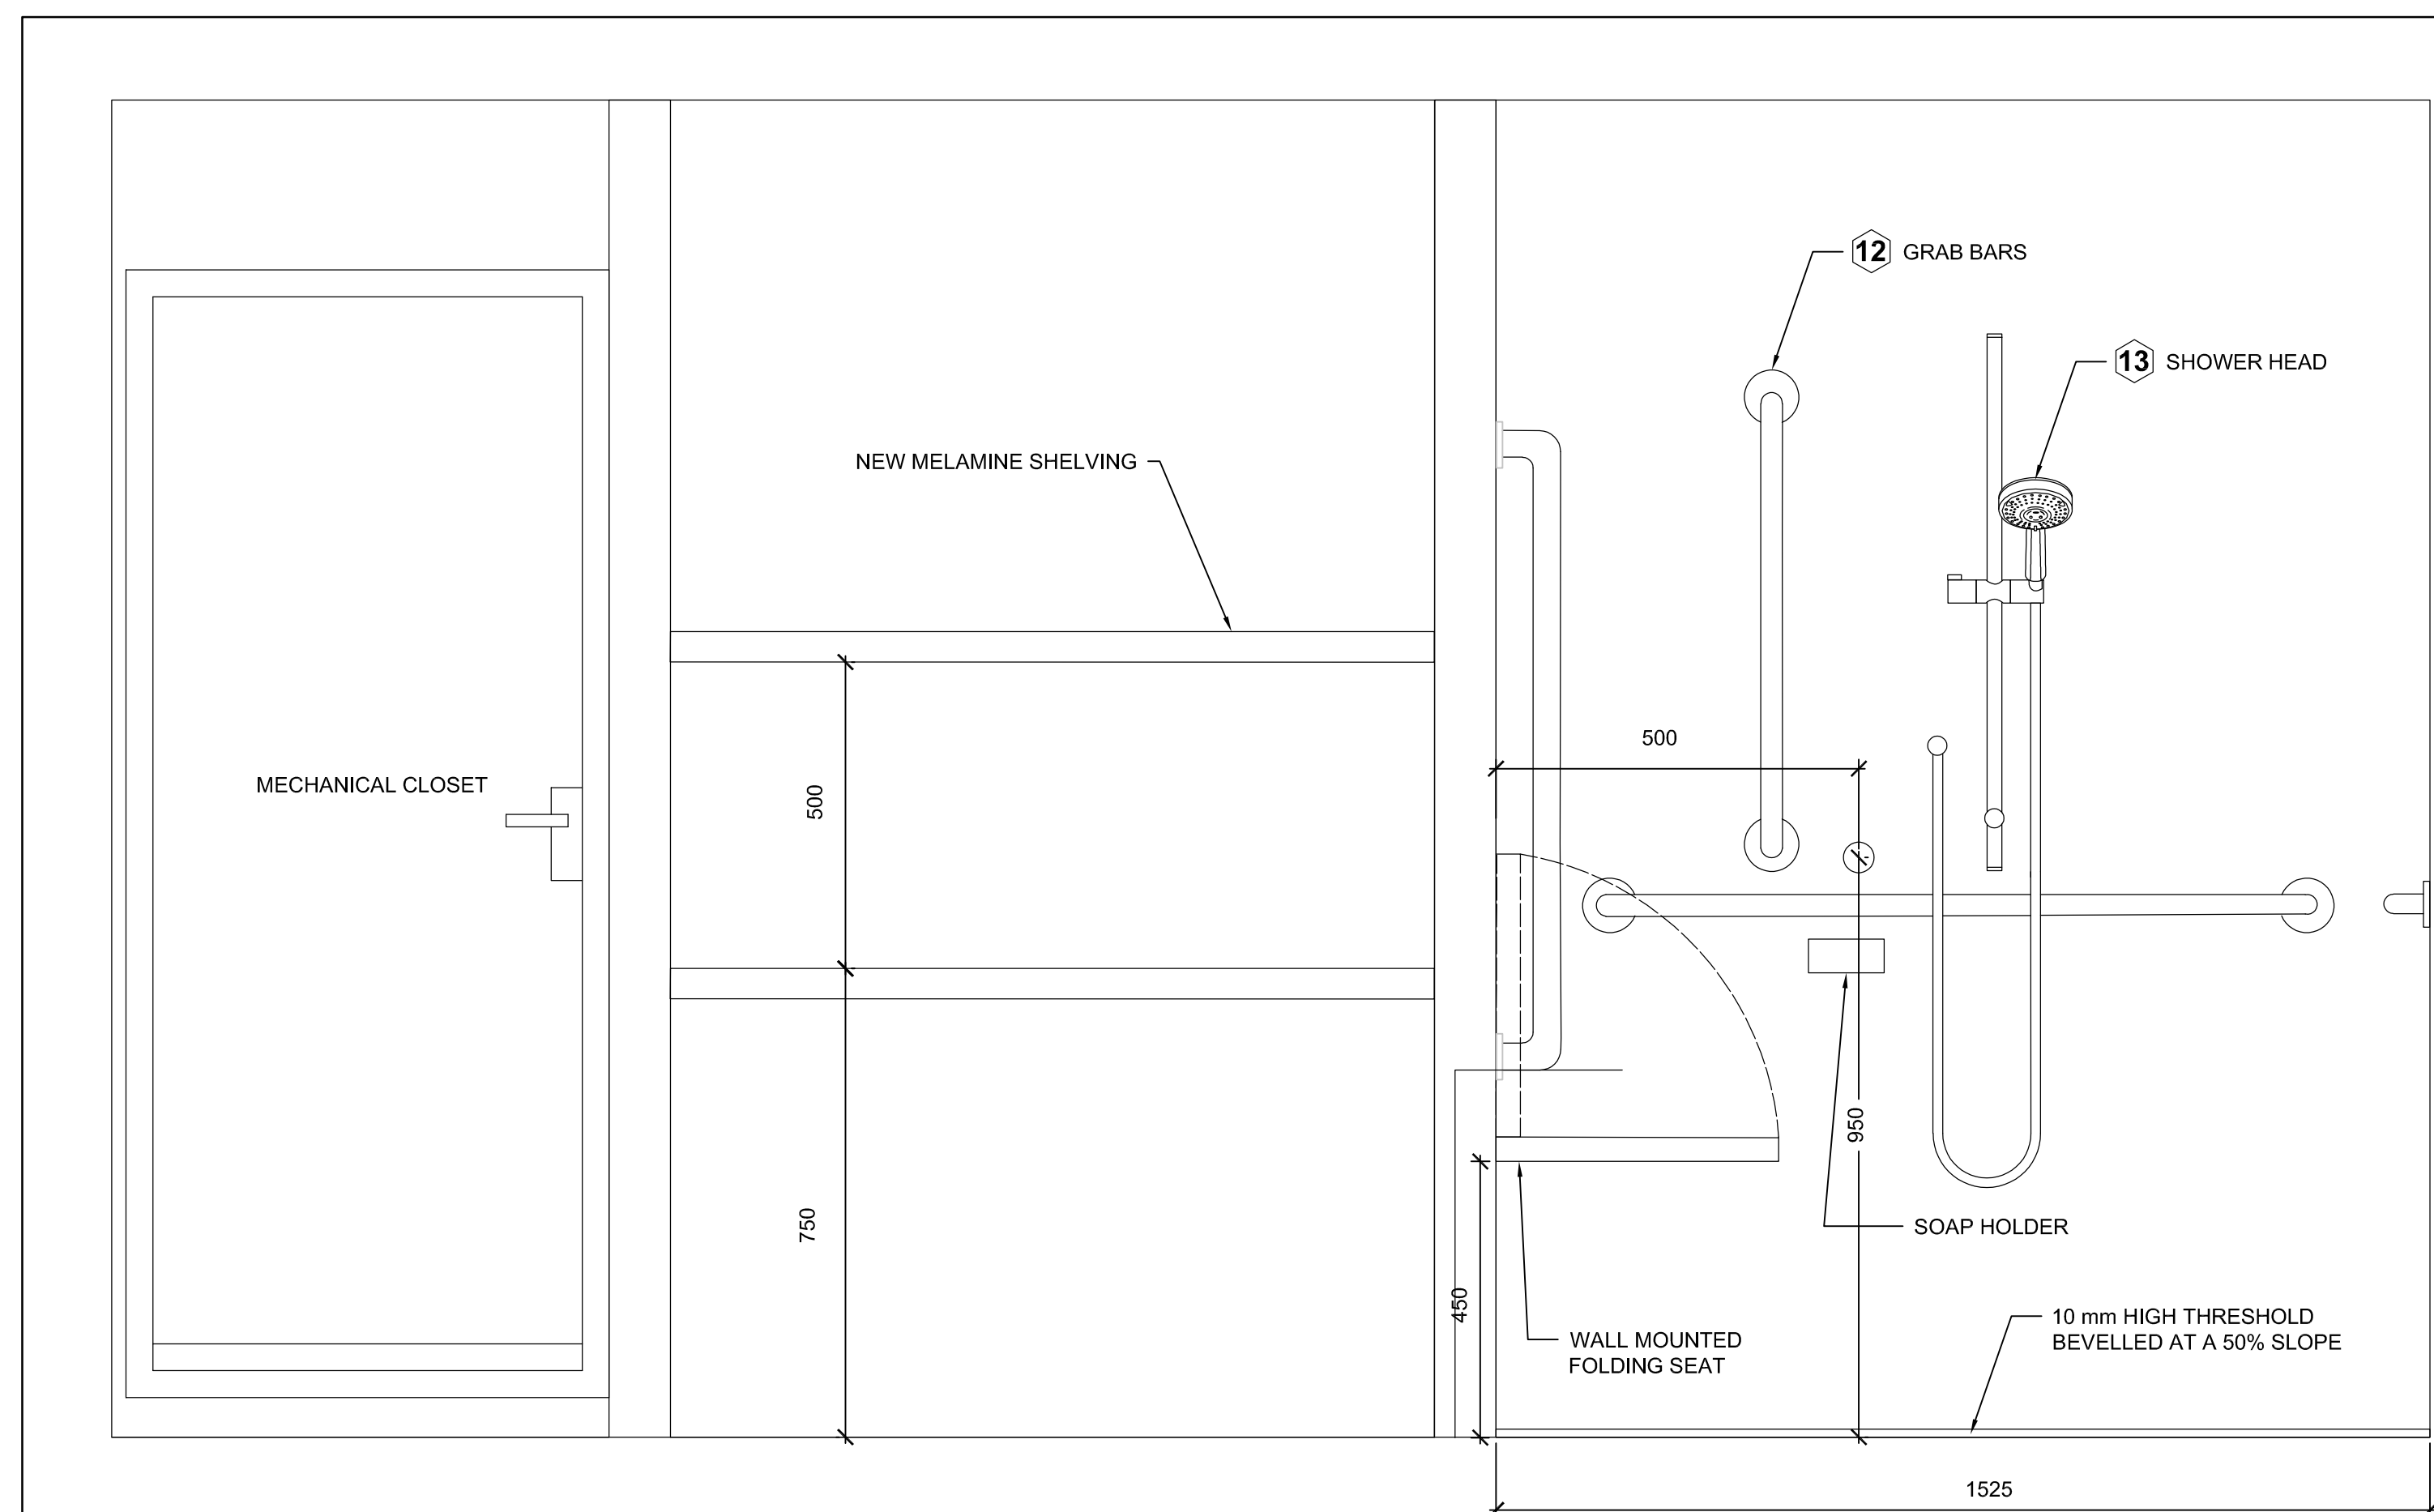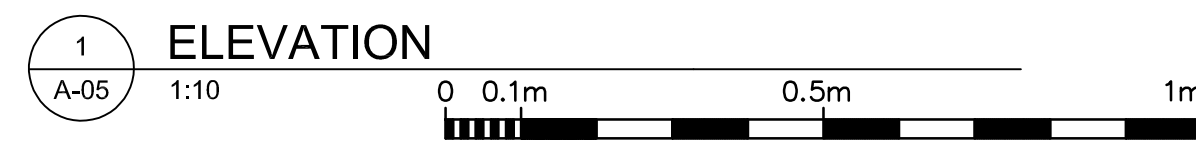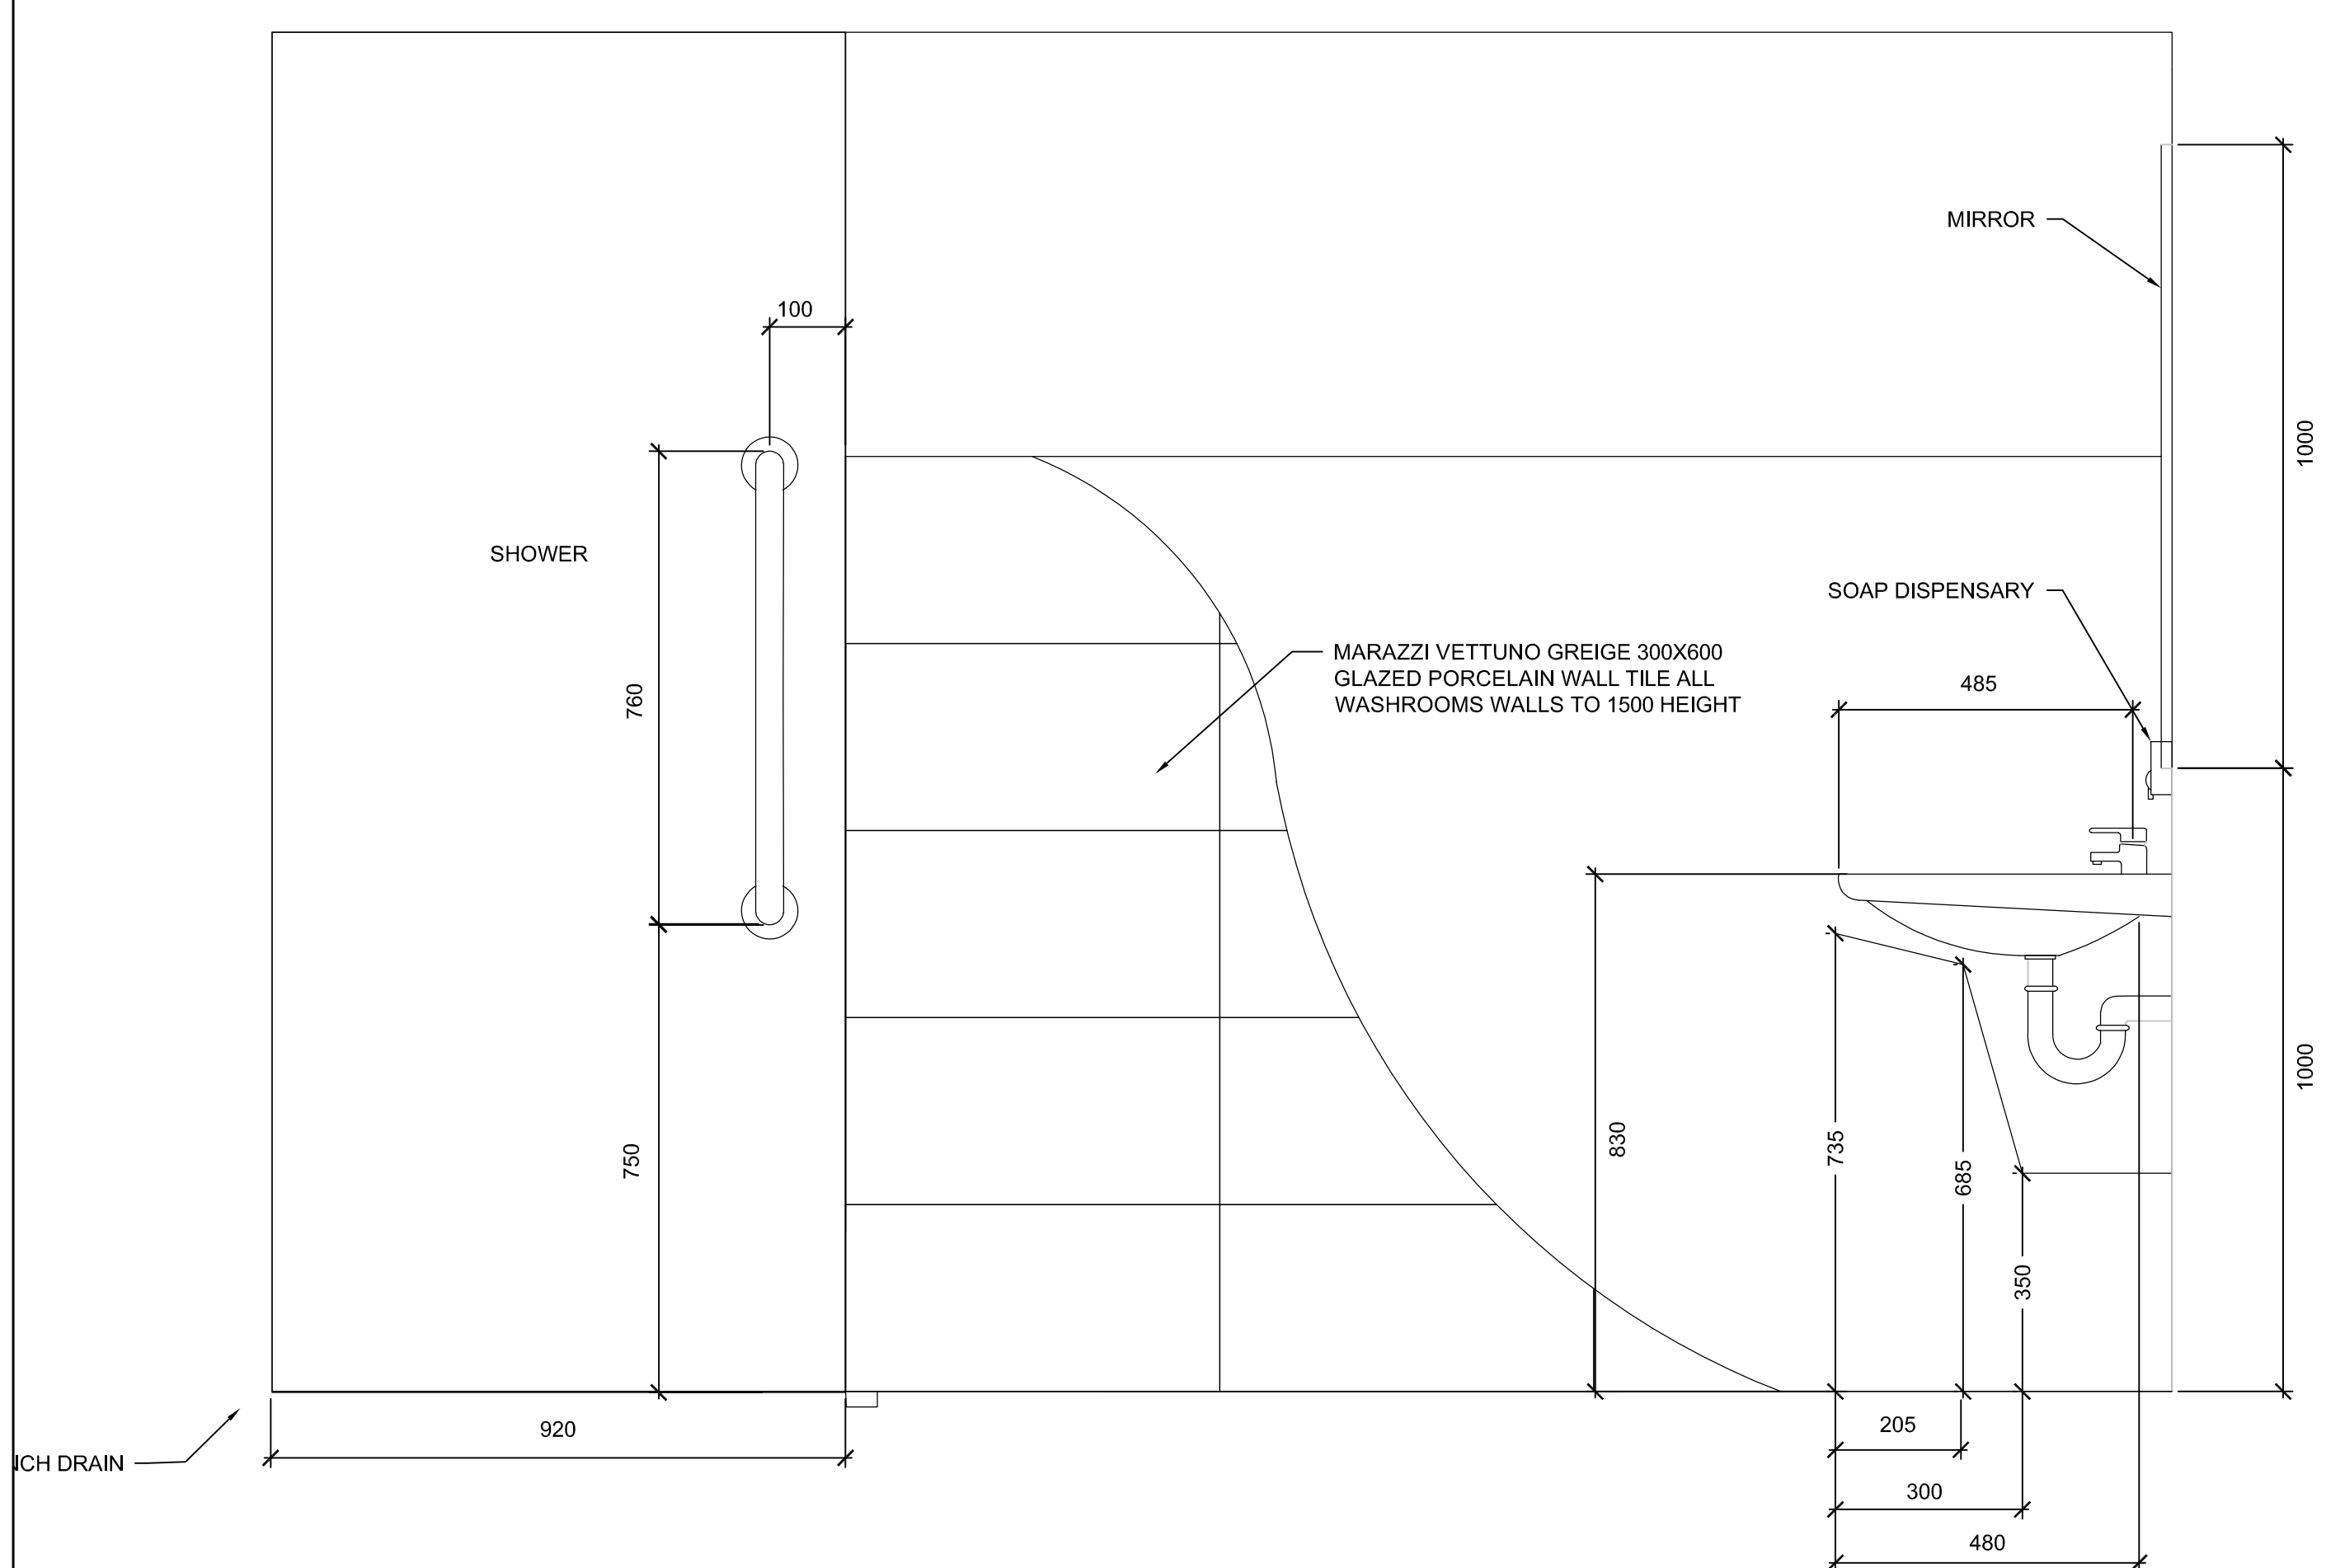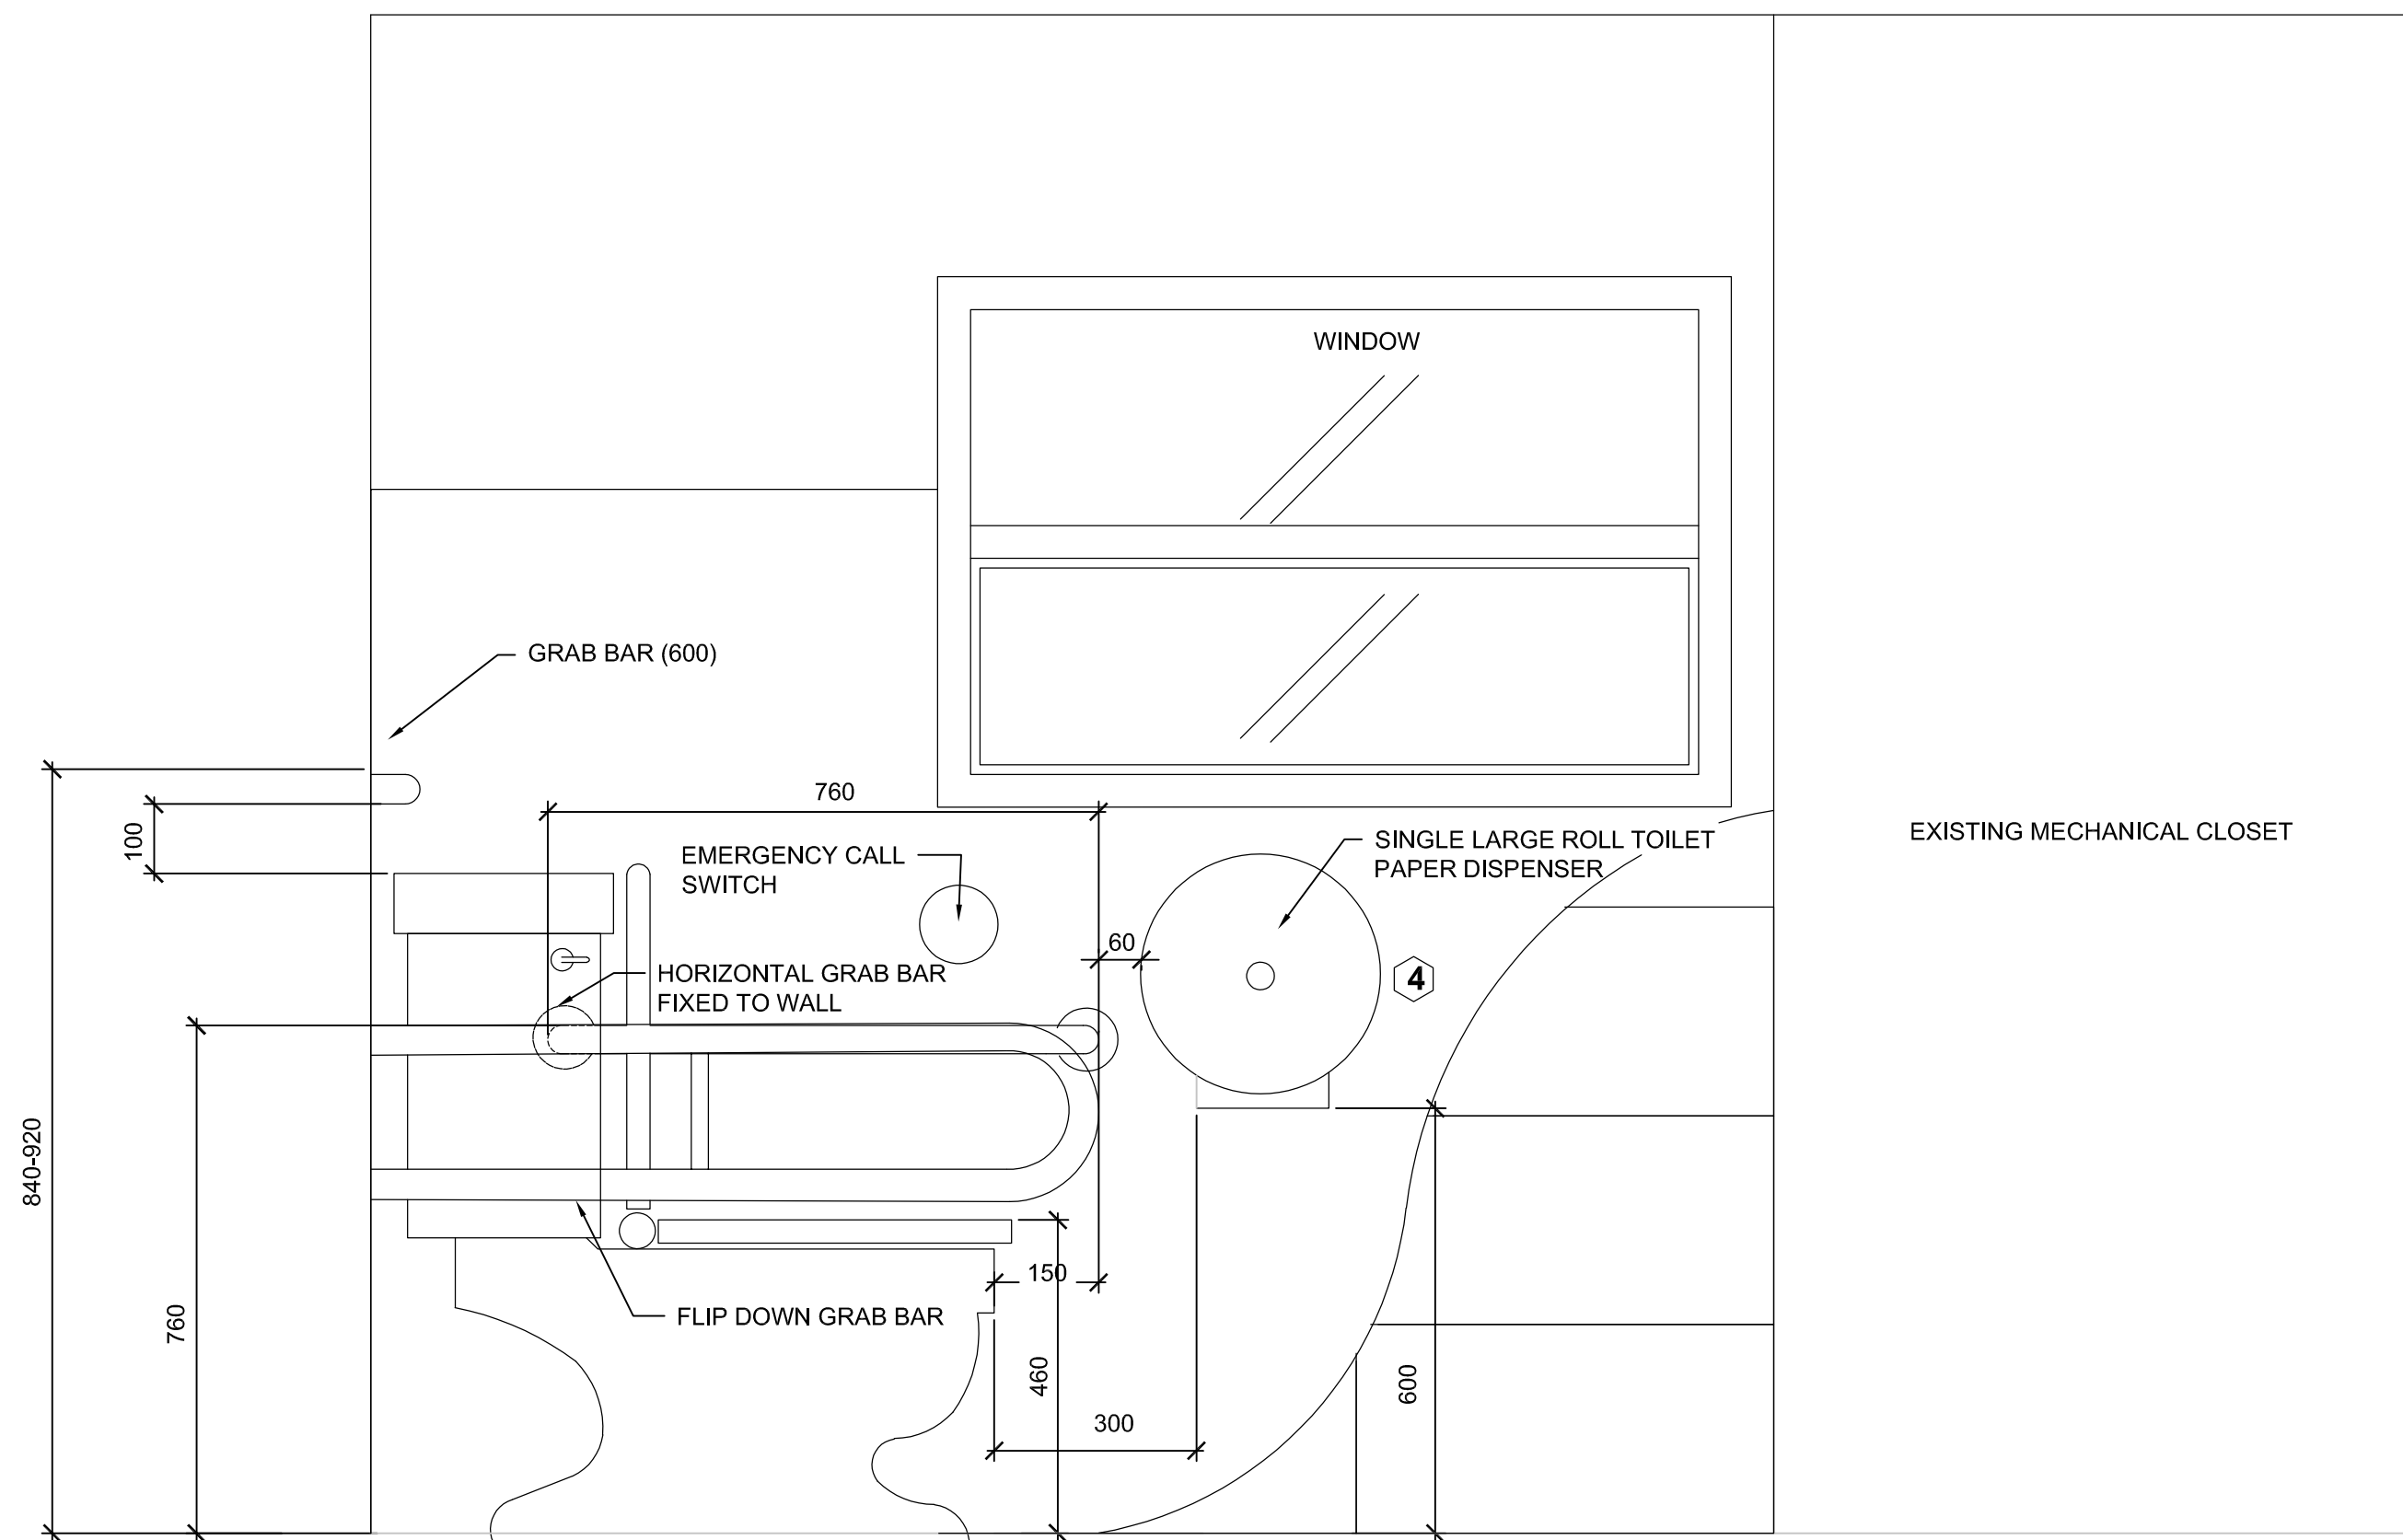

Consultant:

**MORRISON HERSHFIELD**

Suite 300 – 125 Commerce Valley Drive W  
Markham, Ontario L3T 7W4  
Tel: 416-499-3110 Fax: 416-499-9658



revision	description	date
1	ISSUED FOR PRICING	2019/02/21
1	ISSUED FOR DESIGN REVIEW	2019/02/11

Do not scale drawings.  
Verify all dimensions and conditions on site and immediately notify the Departmental Representative of all discrepancies.

A	Detail No.
B	drawing no. – where detail required
C	drawing no. – where detailed

project title  
titre du projet  
**BURLINGTON CANAL LIFT BRIDGE (BCLB)**  
1157 BEACH BOULEVARD

**BARRIER-FREE WASHROOM RETROFIT**

drawing title  
titre du dessin  
**BARRIER FREE WASHROOM RETROFIT ELEVATIONS**

drawn by  
dessiné par  
**AAA**

designed by  
conçu par  
**AAA**


approved by  
approuvé par  
**RY**

bid  
soumission  
**AK**

project date  
date du projet  
**2019-02-11**


project no.  
no. du projet  
**R.089504.120**

drawing no.  
dessiné no.  
**A-05**

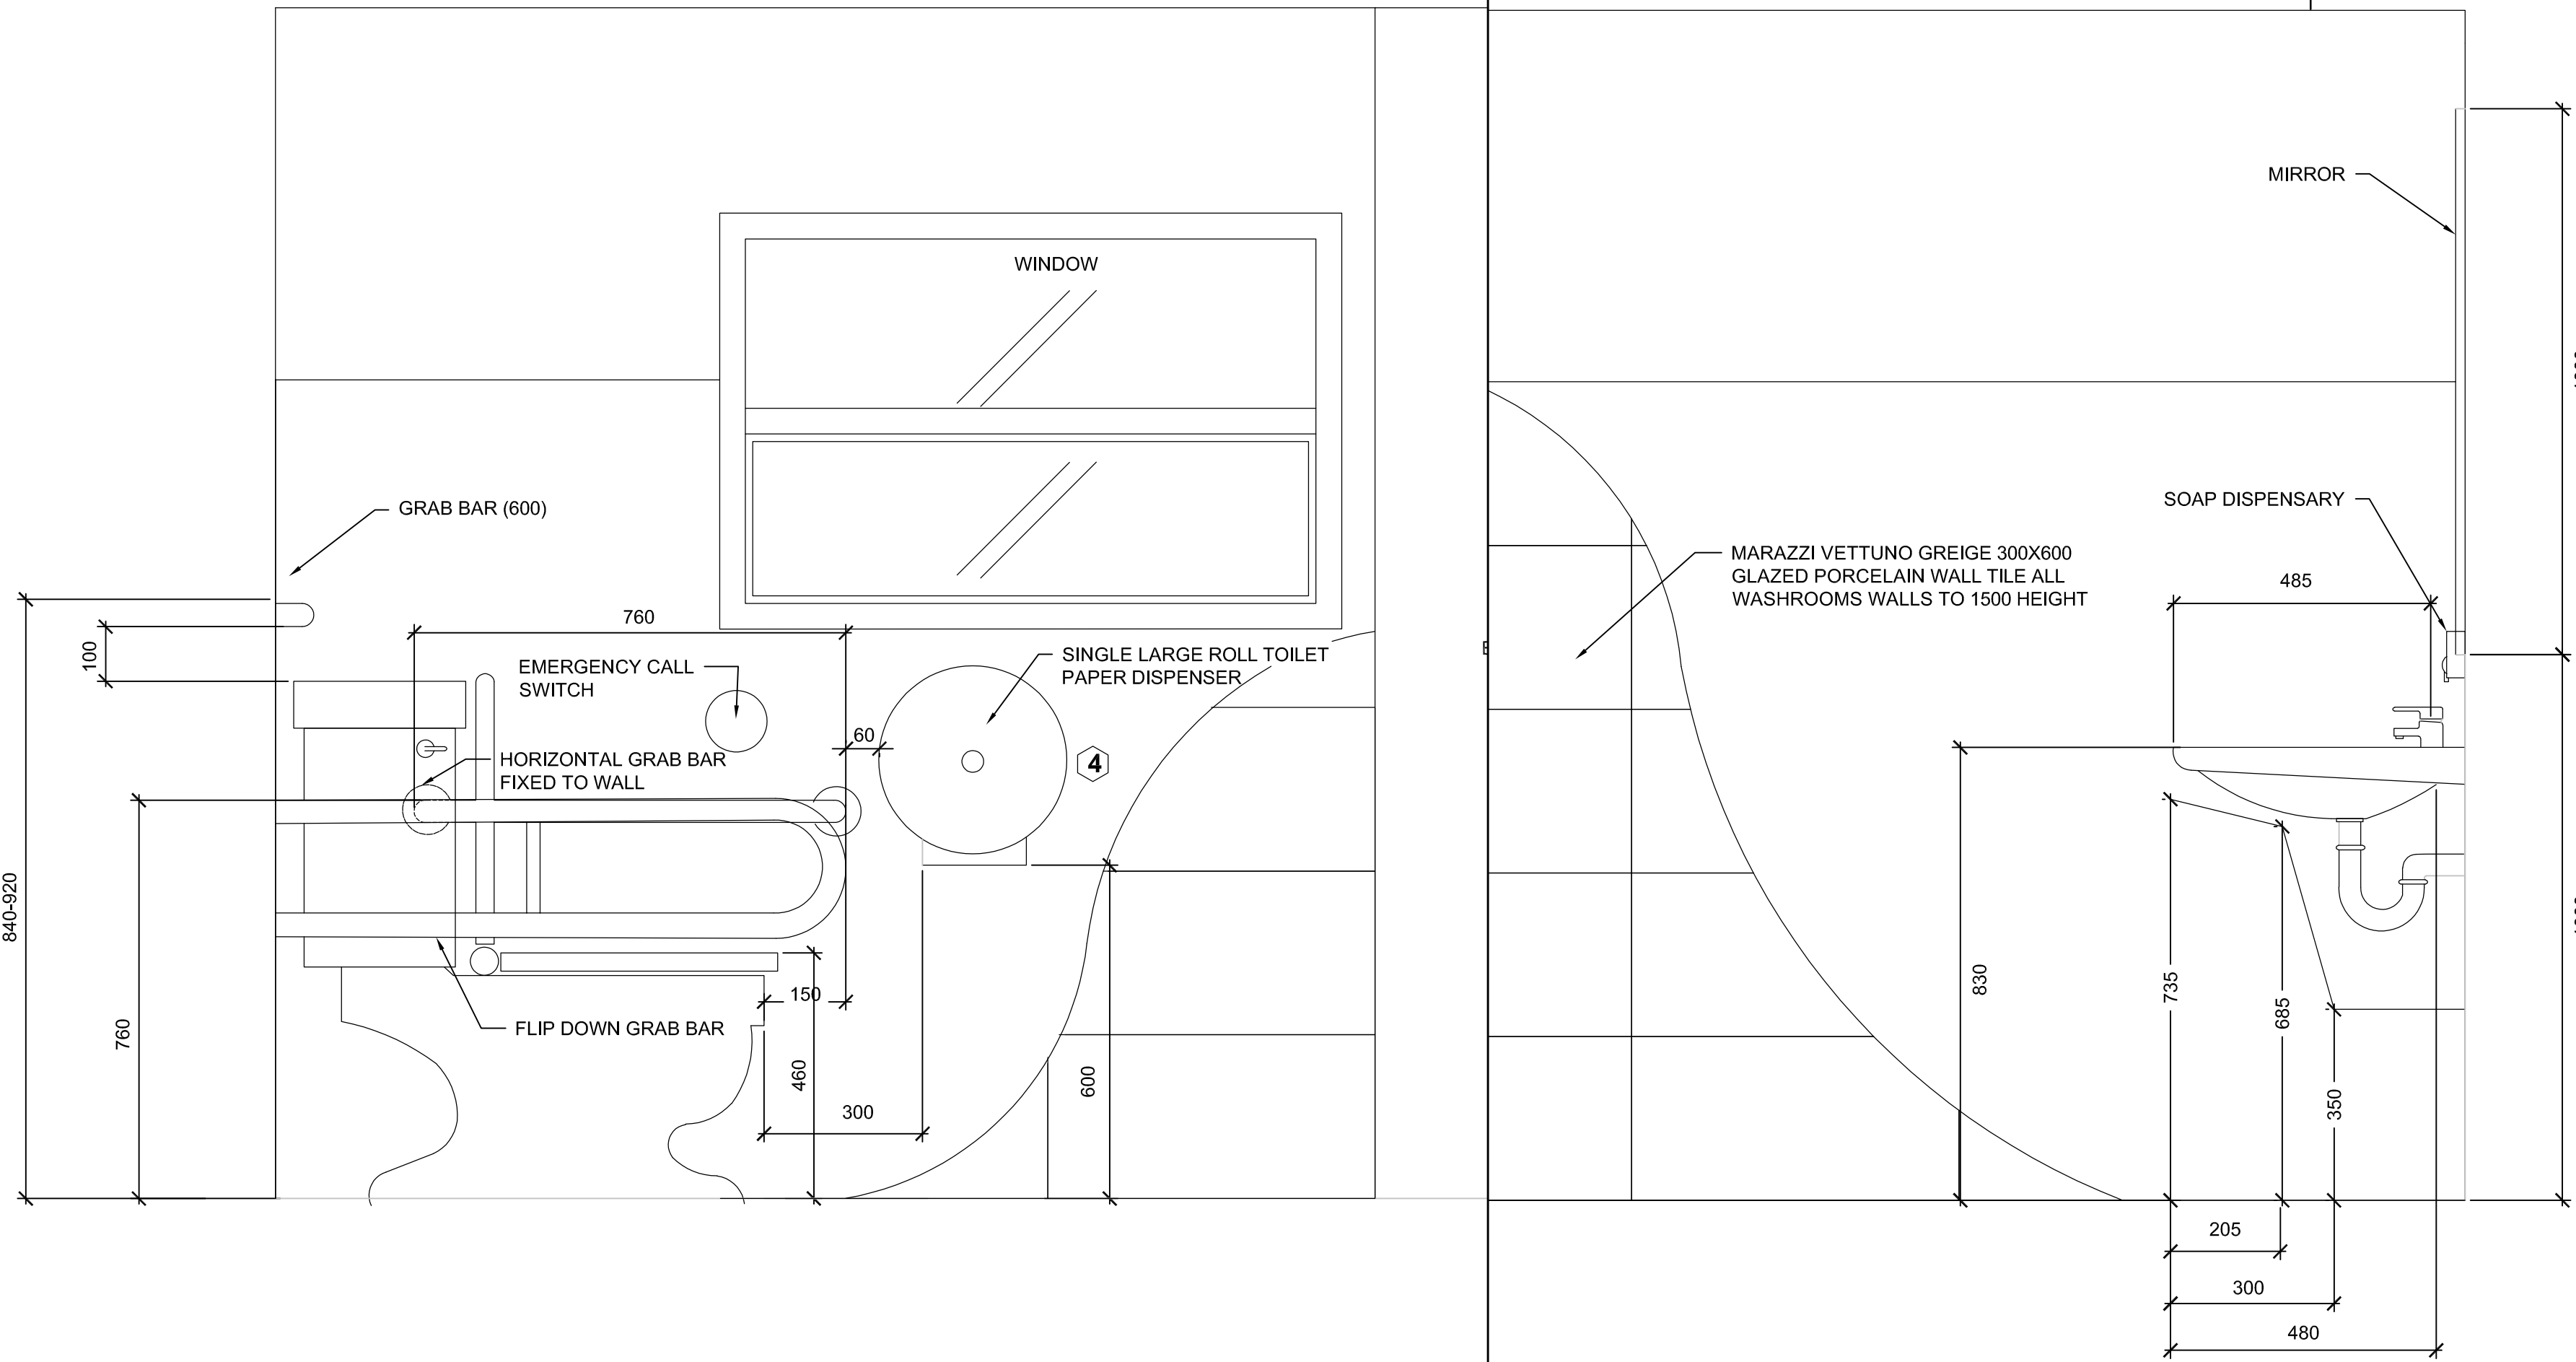


1 TOILET ELEVATION  
A-06 1:10  
0 0.1m 0.5m 1m


2 LAVATORY ELEVATION  
A-06 1:10  
0 0.1m 0.5m 1m

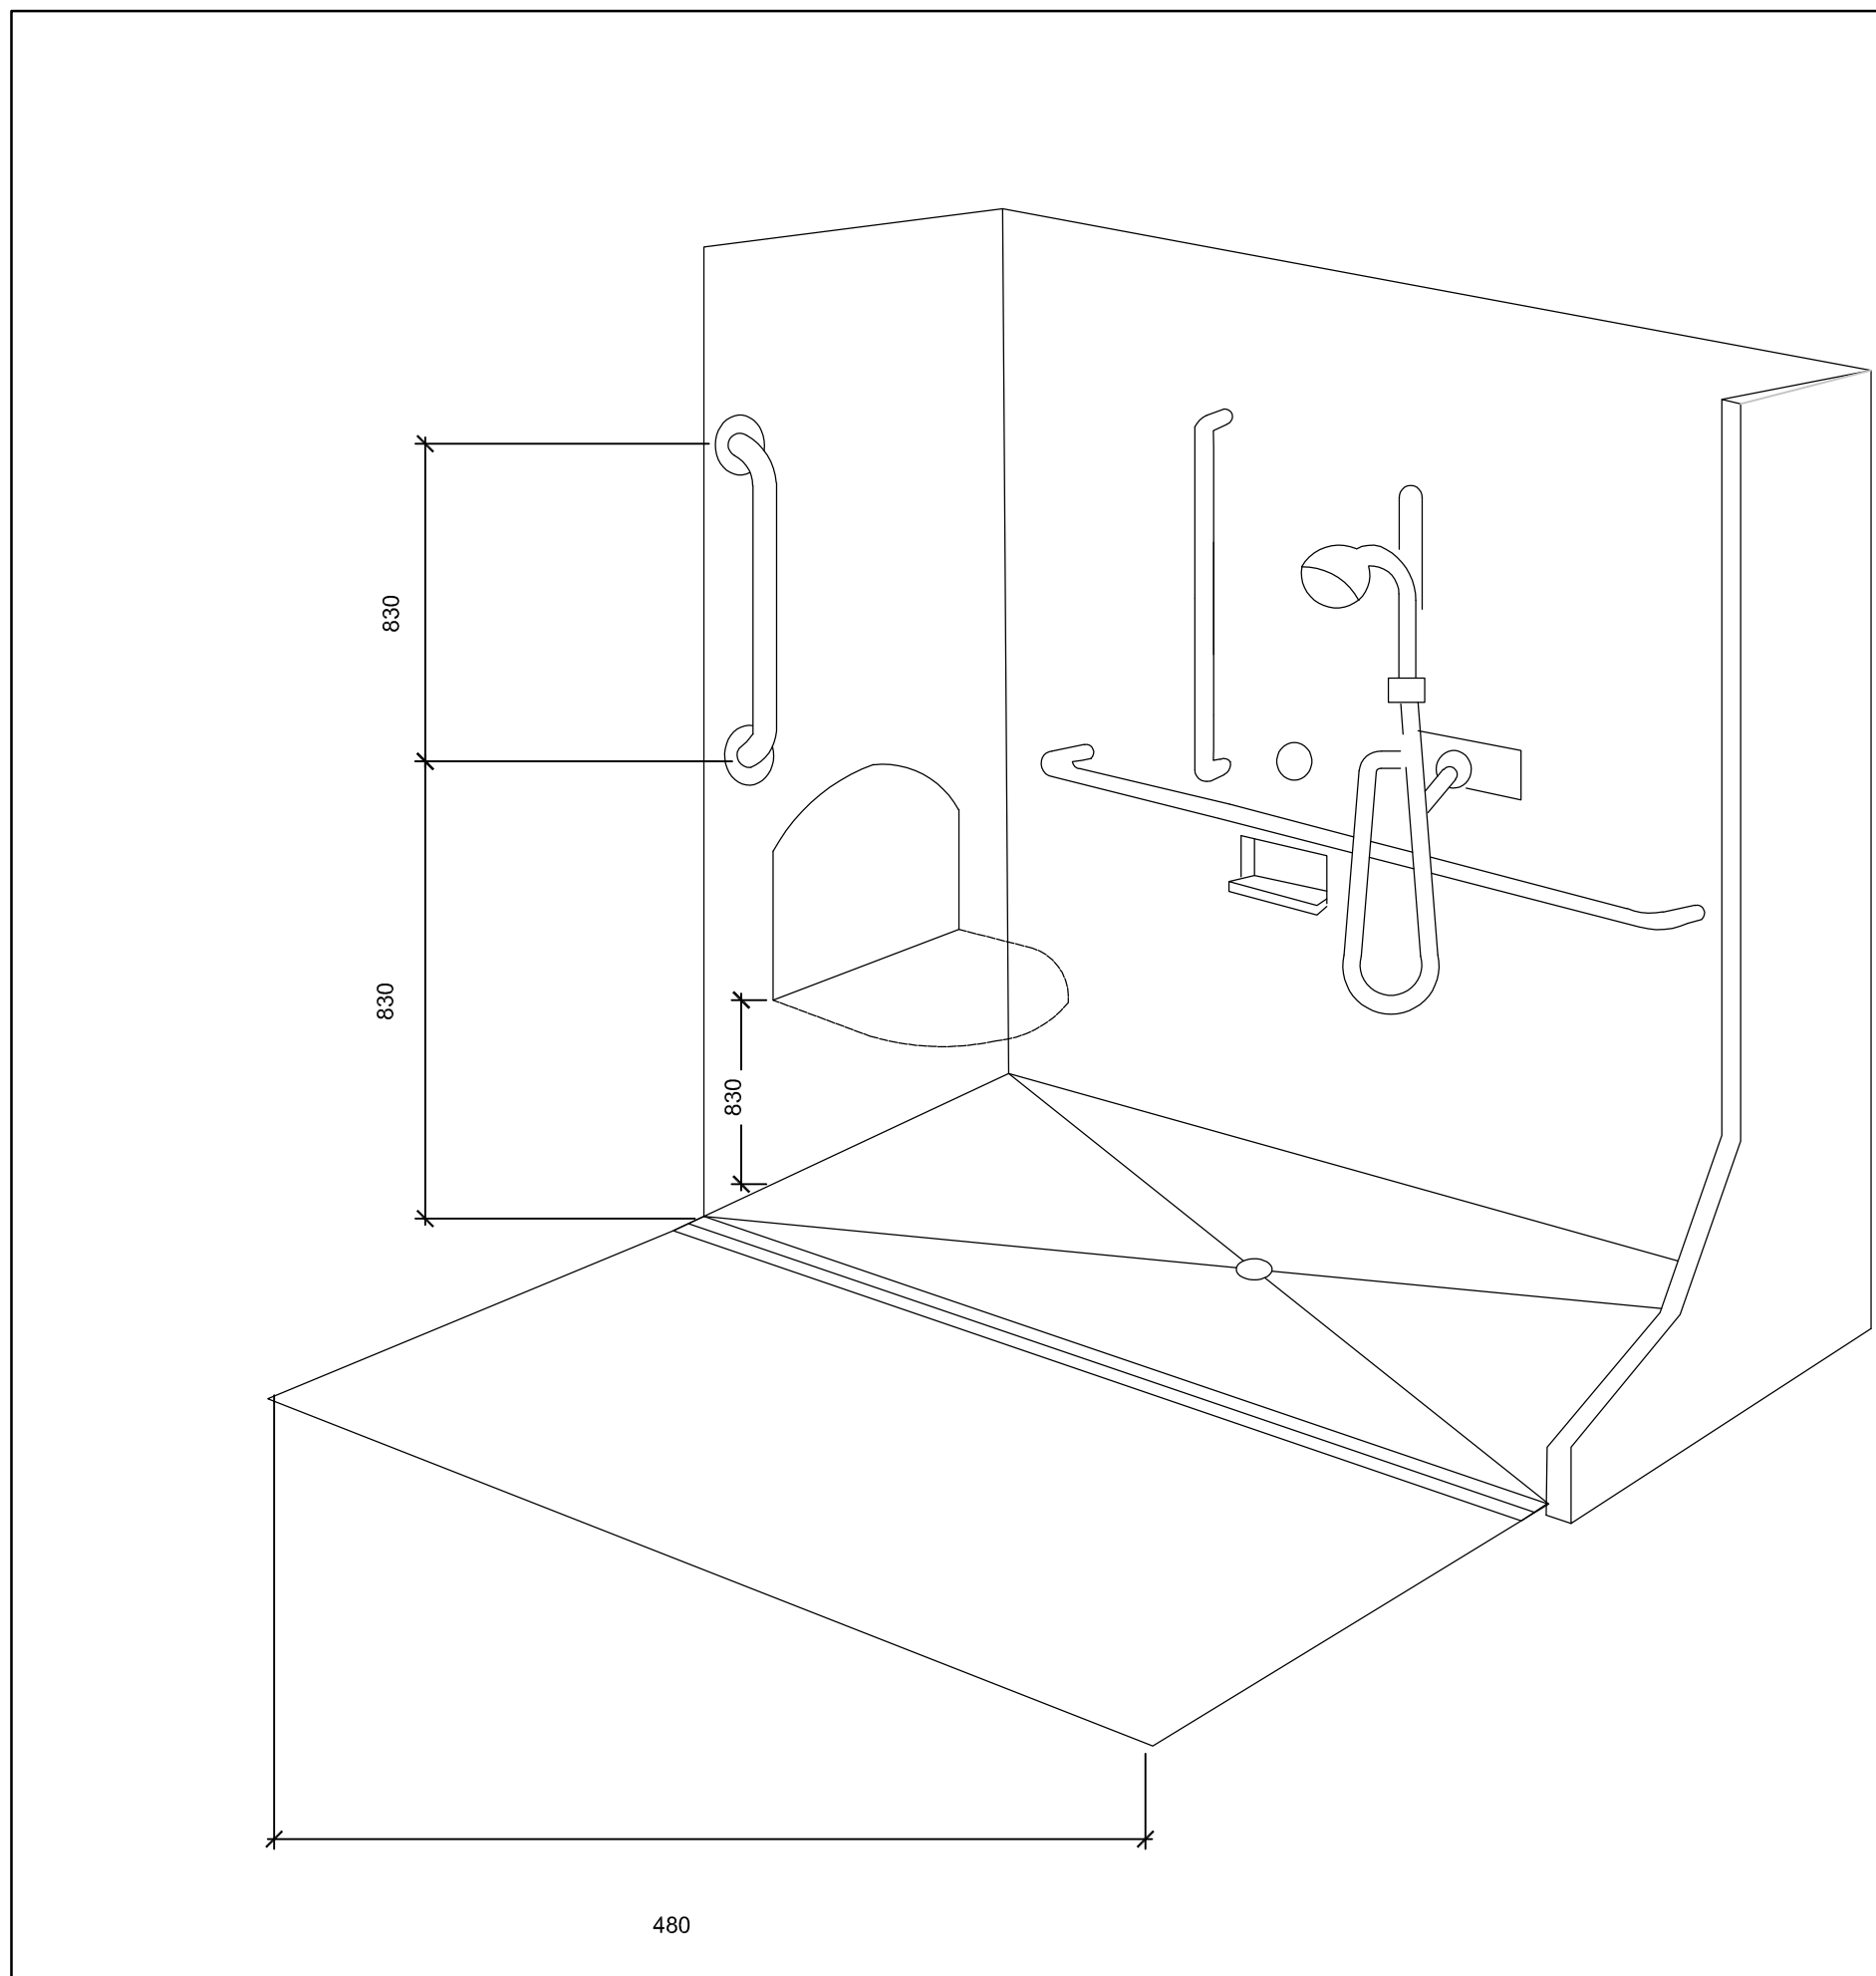


3 SHOWER ELEVATION  
A-06 1:10  
0 0.1m 0.5m 1m

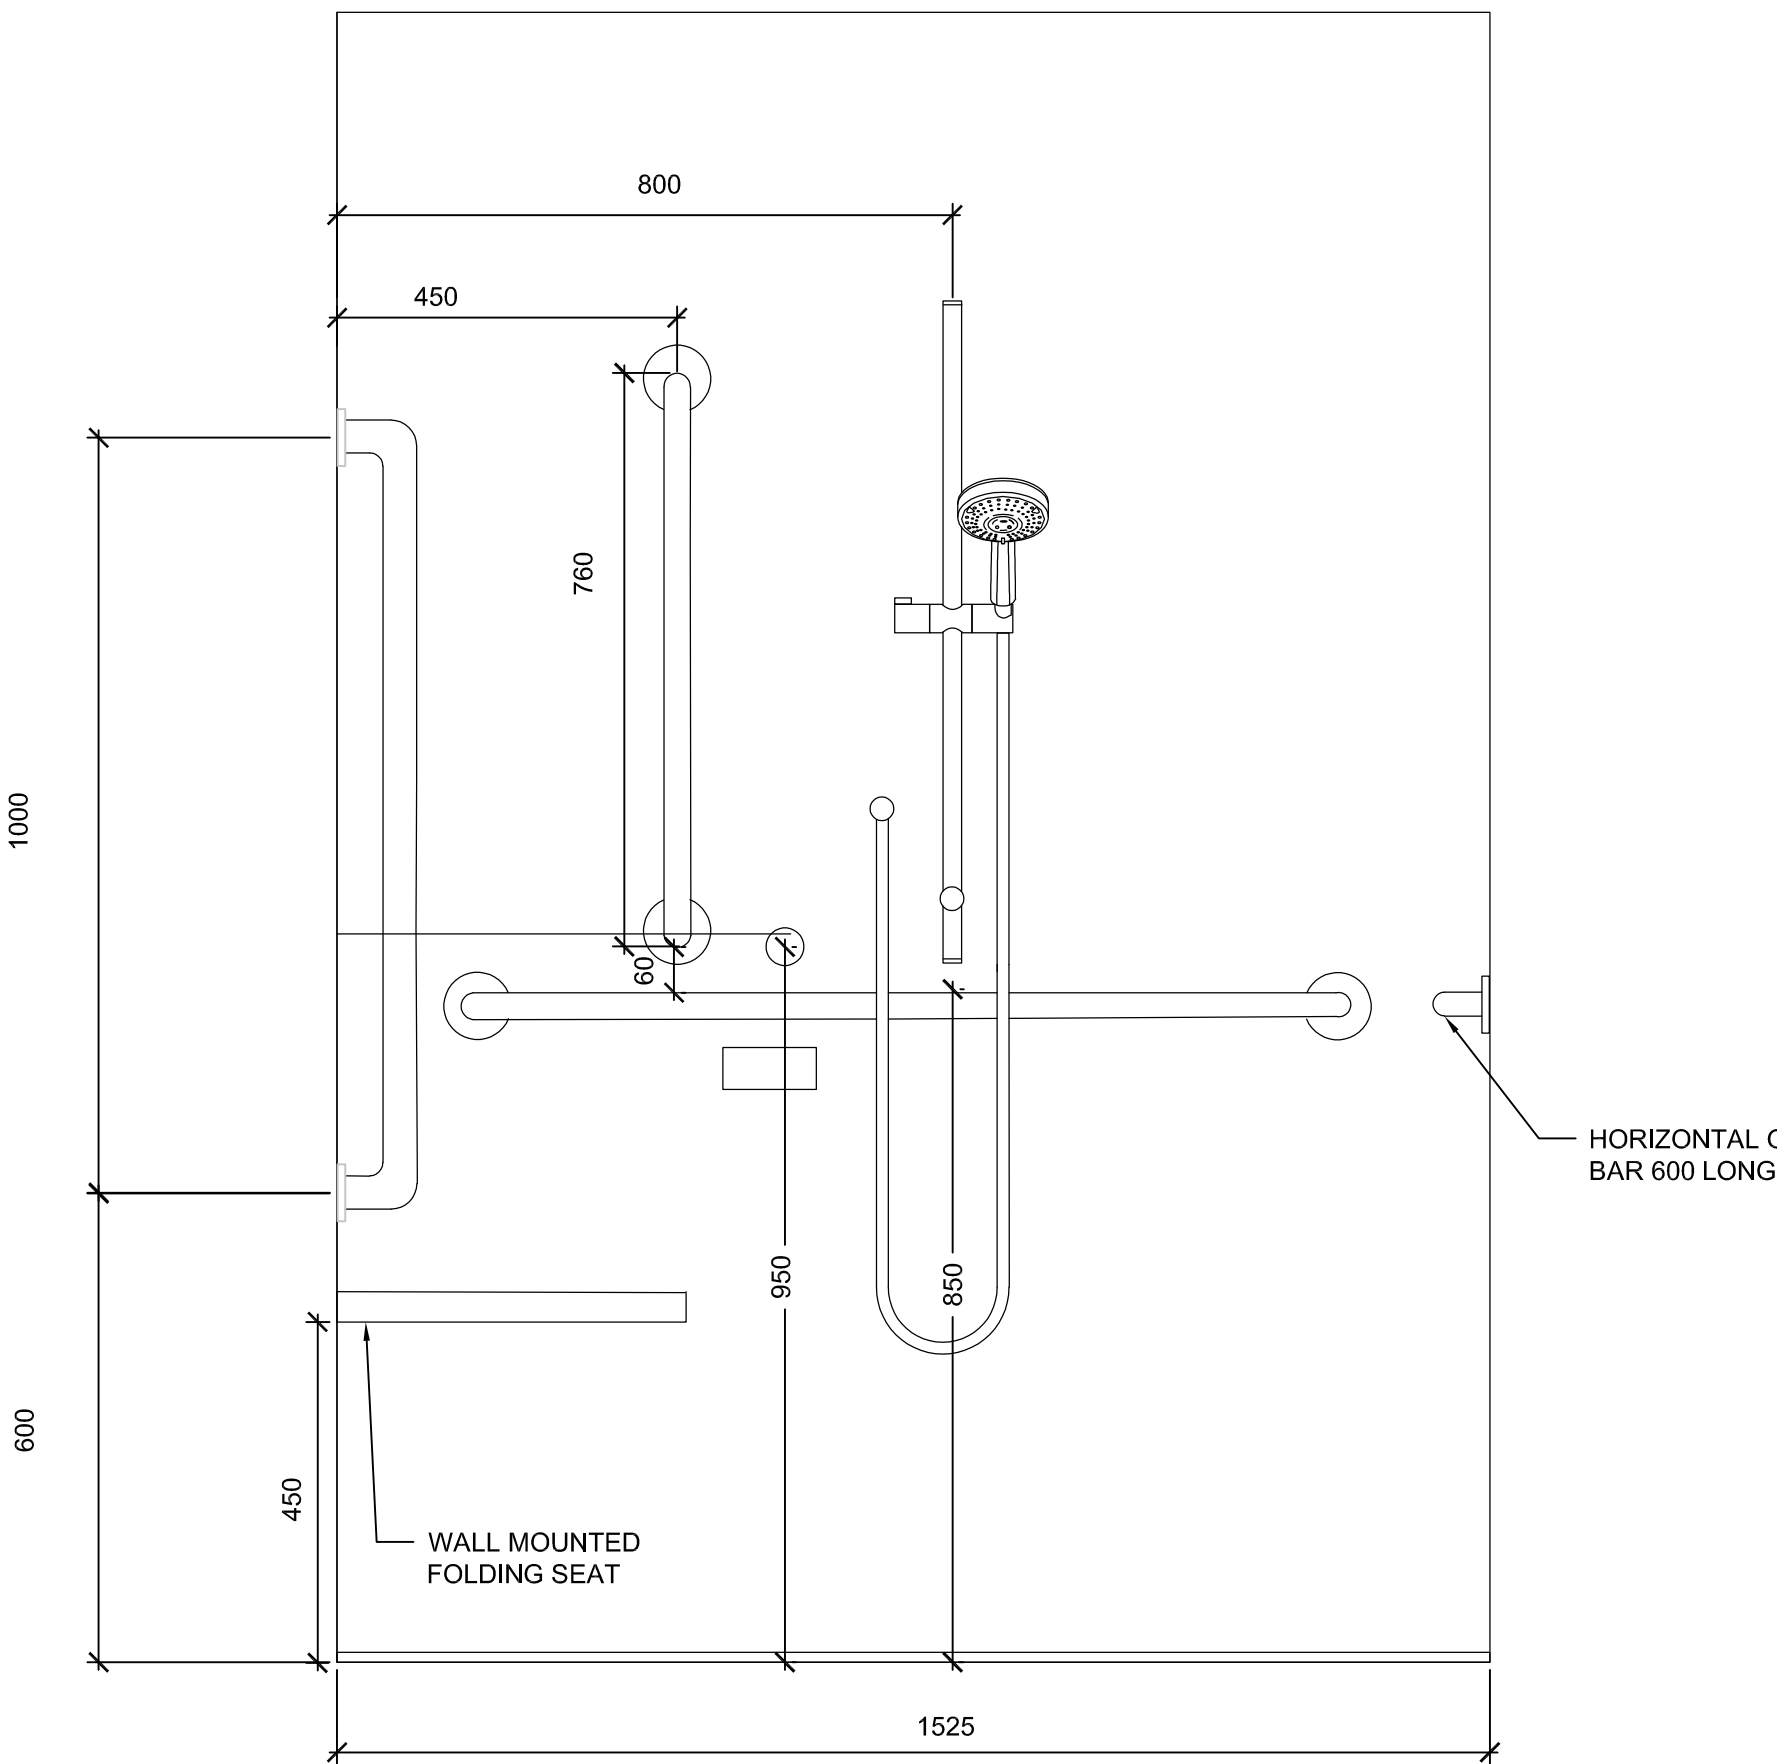

4 SHOWERWALL ELEVATION  
A-06 1:10  
0 0.1m 0.5m 1m

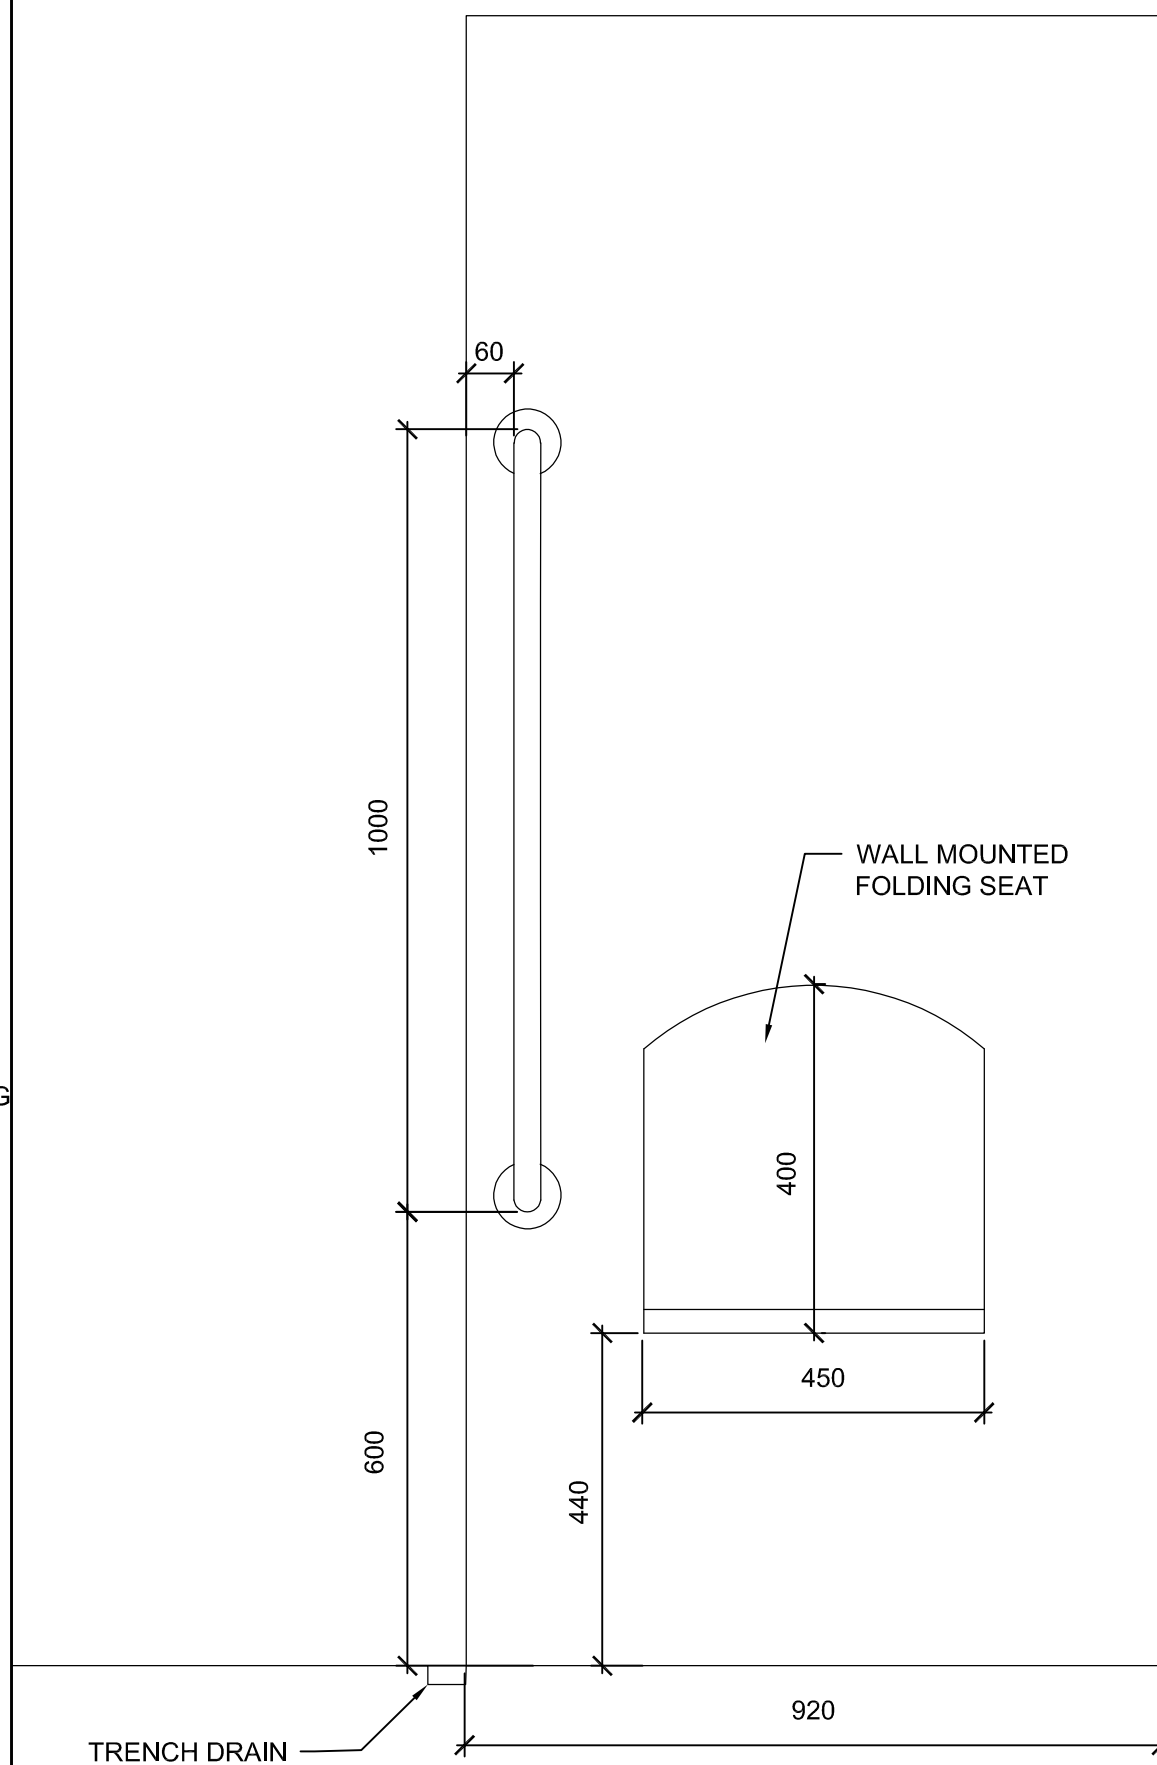

5 SHOWER WALL ELEVATION  
A-06 1:100  
0 1m 5m 10m

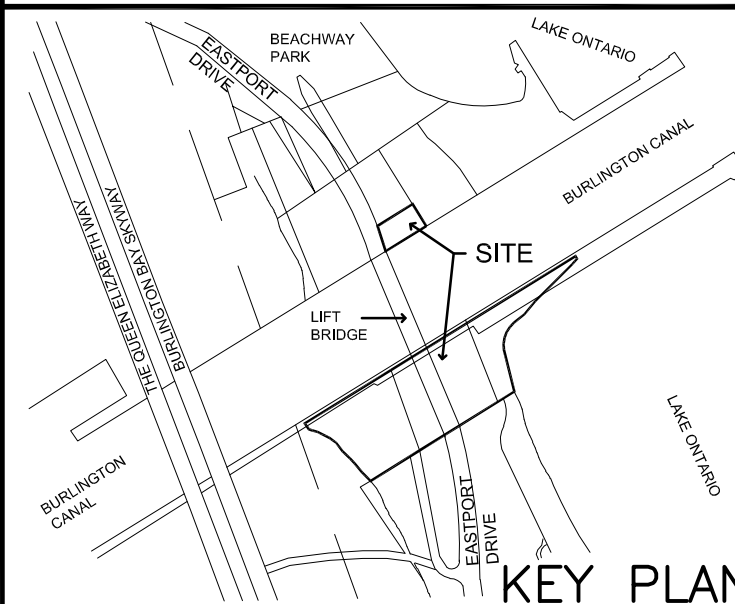

Consultant:

**MORRISON HERSHFIELD**  
Suite 300 – 125 Commerce Valley Drive W  
Markham, Ontario L3T 7W4  
Tel: 416-499-3110 Fax: 416-499-9658



revision	description	date
2	ISSUED FOR PRICING	2019/02/29
1	ISSUED FOR DESIGN REVIEW	2019/02/11

Do not scale drawings.  
Verify all dimensions and conditions on site and immediately  
notify the Departmental Representative of all discrepancies.

A	Detail No.
B	drawing no. – where detail required
C	drawing no. – where detailed

project title  
titre du projet  
**BURLINGTON** ONTARIO  
**BURLINGTON CANAL LIFT BRIDGE (BCLB)**  
**1157 BEACH BOULEVARD**

**BARRIER-FREE WASHROOM  
RETROFIT**

drawing title  
titre du dessin  
**BARRIER FREE WASHROOM  
RETROFIT  
DETAILS**

drawn by  
dessiné par  
**AAA**

designed by  
conçue par  
**AAA**

approved by  
approuvée par  
**–**



bid  
soumission  
**–**

project date  
date du projet  
**2019-02-11**

project no.  
no. du projet  
**R.089504.120**

drawing no.  
dessiné no.  
**A-06**



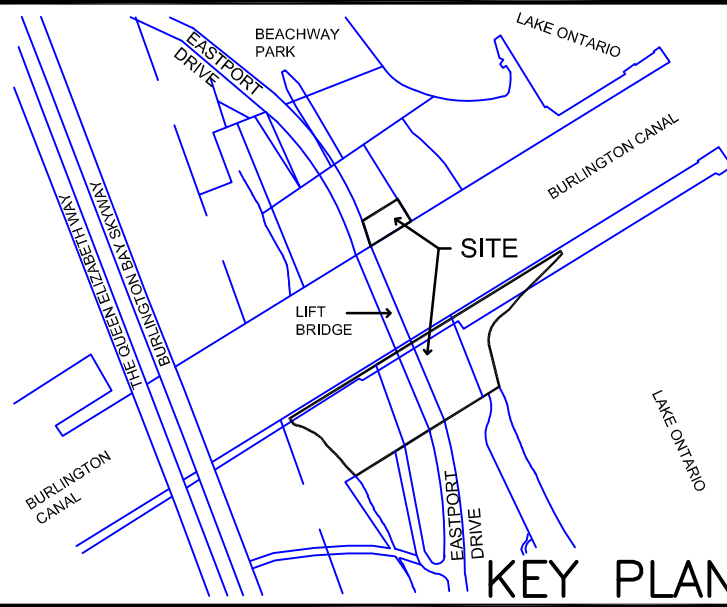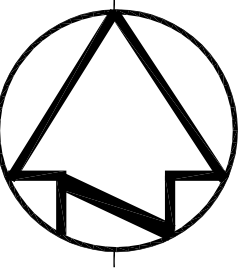

Consultant:

**MORRISON HERSHFIELD**  
Suite 300 – 125 Commerce Valley Drive W  
Markham, Ontario L3T 7W4  
Tel: 416-499-3110 Fax: 416-499-9658



revision	description	date
1	ISSUED FOR DESIGN REVIEW	2019/06/08

Do not scale drawings.  
Verify all dimensions and conditions on site and immediately  
notify the Departmental Representative of all discrepancies.

<b>A</b>	Detail No.
<b>B</b>	No. du détail
<b>C</b>	drawing no. – where detail required dessin no. – où détail exigé
<b>C</b>	drawing no. – where detailed dessin no. – où détaillé

project title  
titre du projet  
**BURLINGTON** ONTARIO  
**BURLINGTON CANAL LIFT BRIDGE (BCLB)**  
**1157 BEACH BOULEVARD**

**BARRIER-FREE WASHROOM  
RETROFIT**

drawing title  
titre du dessin  
**BARRIER FREE WASHROOM  
RETROFIT  
ELECTRICAL**

drawn by  
dessiné par  
**AAA**

designed by  
conçue par  
**AAA**

approved by  
approuvé par  
**–**


bid  
soumission  
**–**

project manager  
administrateur  
de projets



project date  
date du projet  
**2019-02-11**

project no.  
no. du projet  
**R.089504.120**

drawing no.  
dessiné no.  
**E-01**

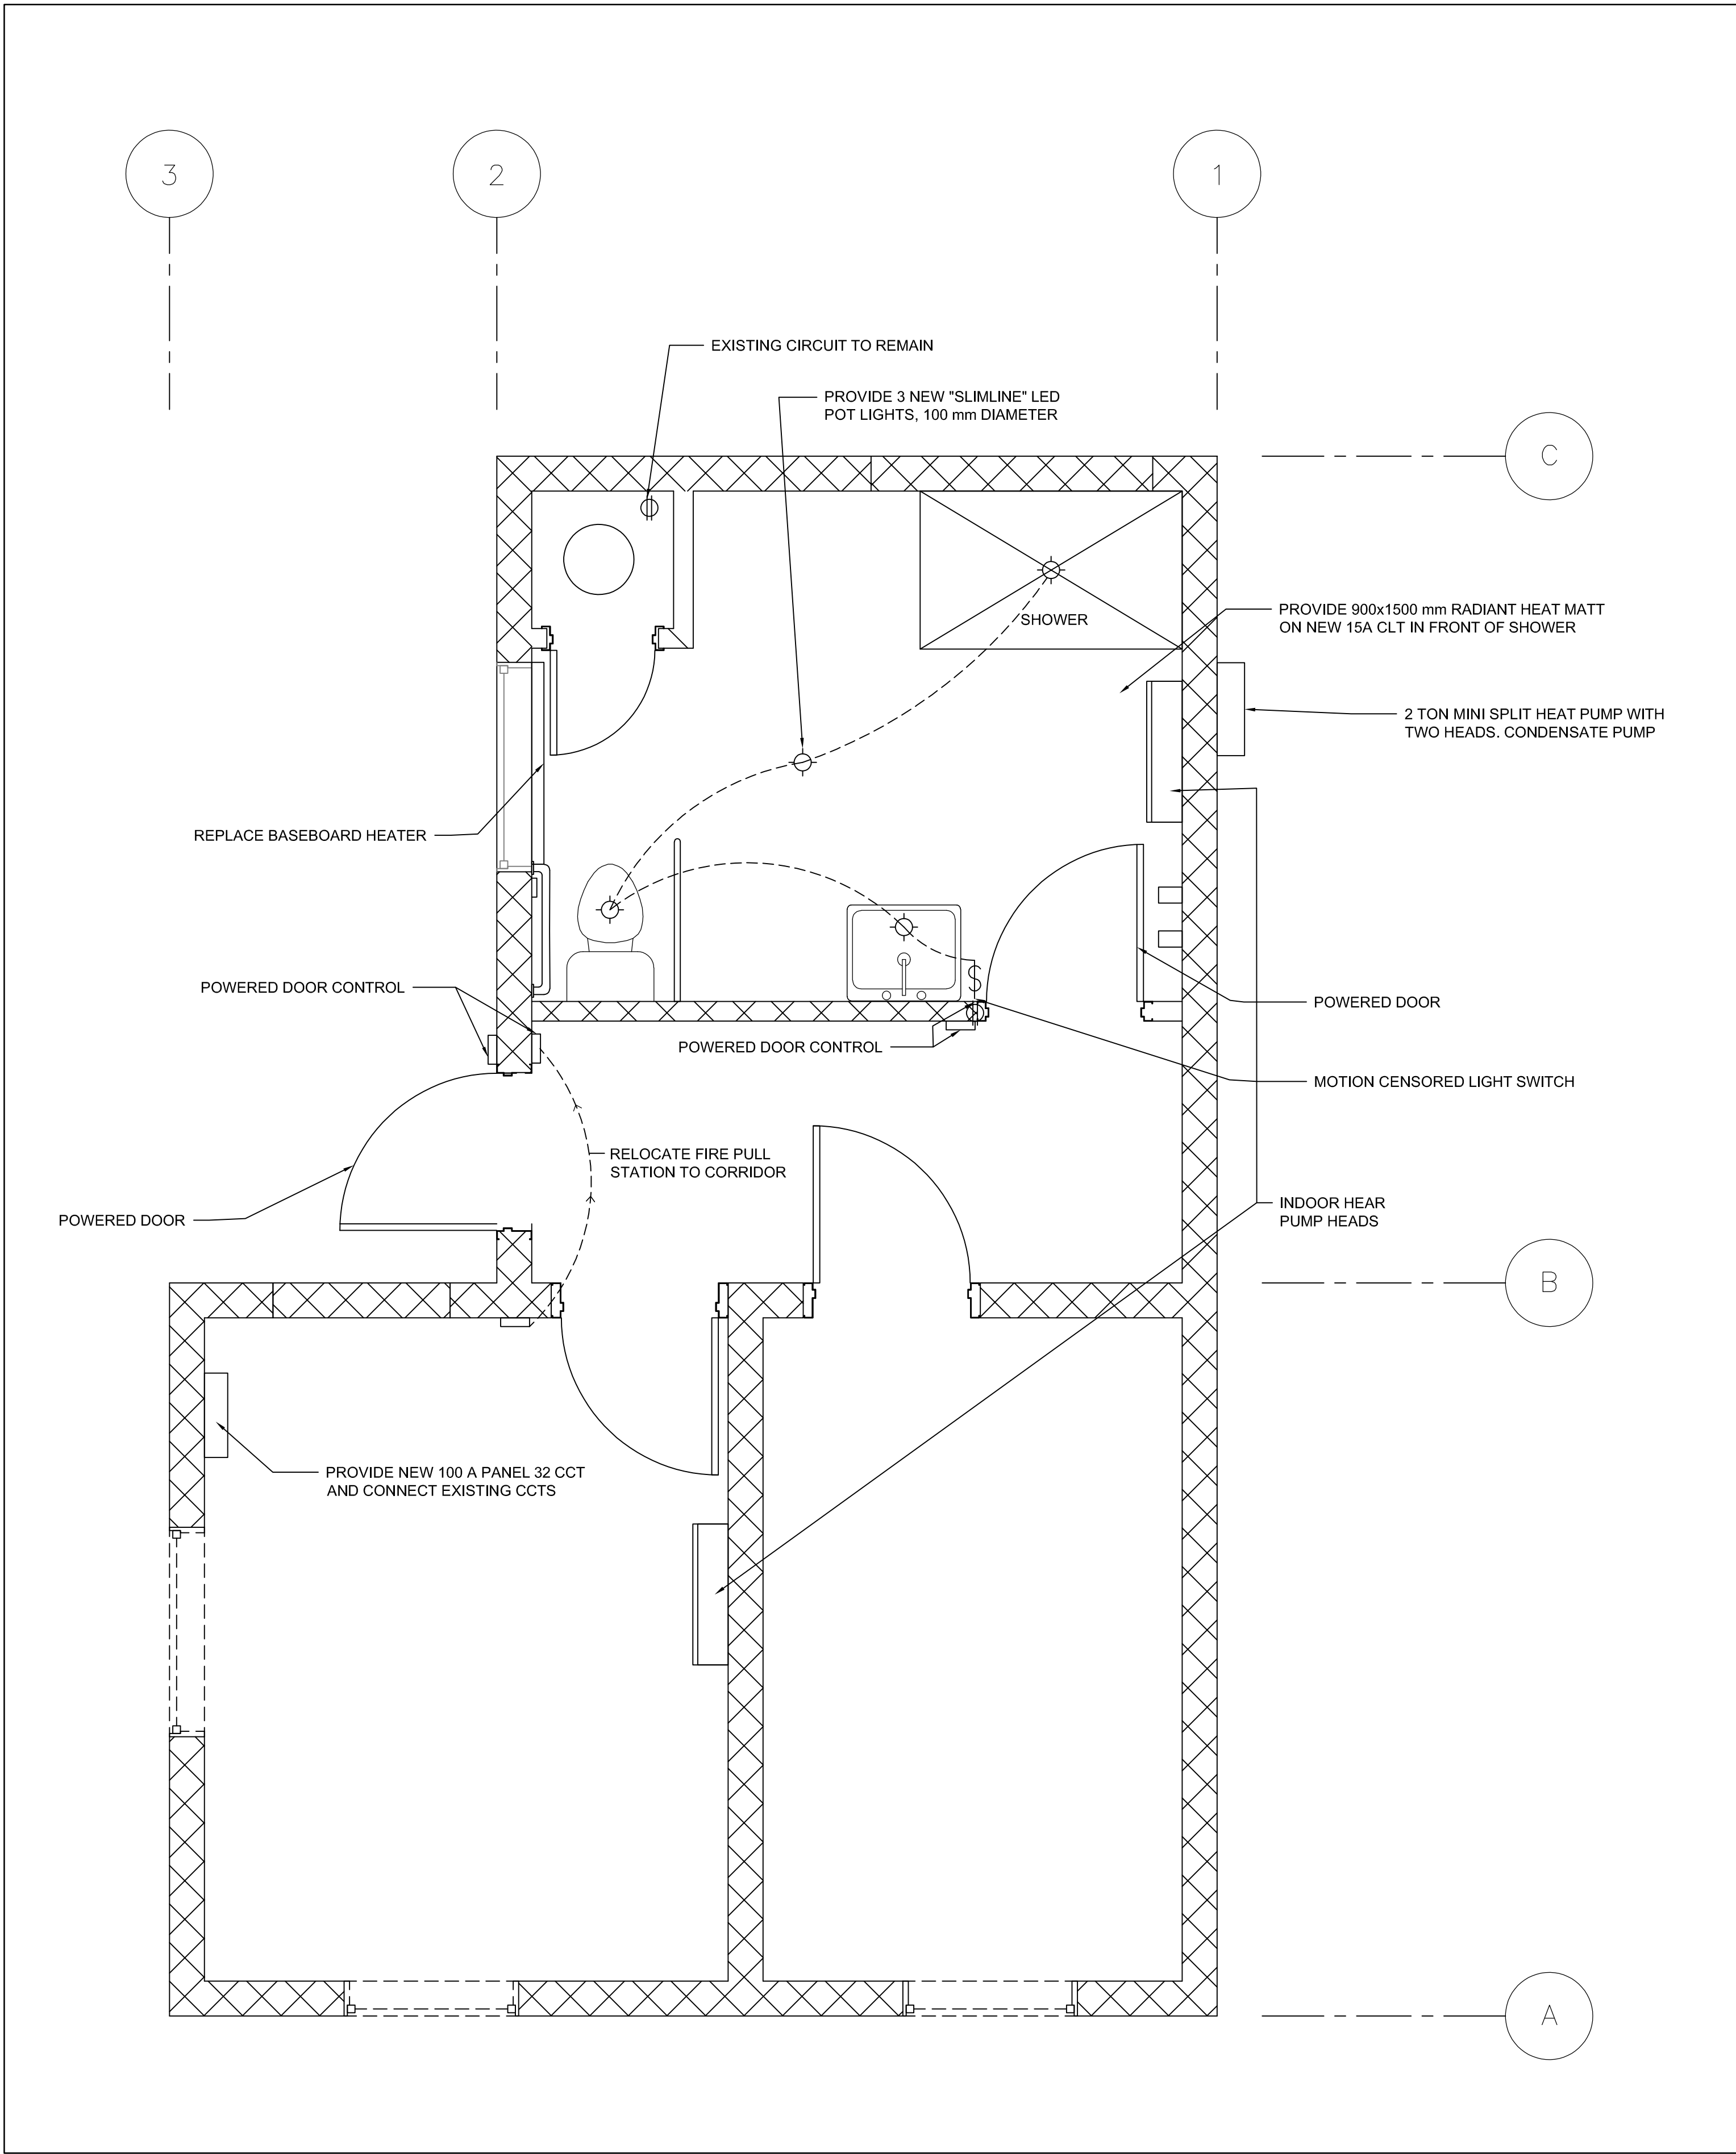

**2**  
**A-03**  
**ELECTRICAL**  
1:25  
0 0.25m 1.5m 2.5m

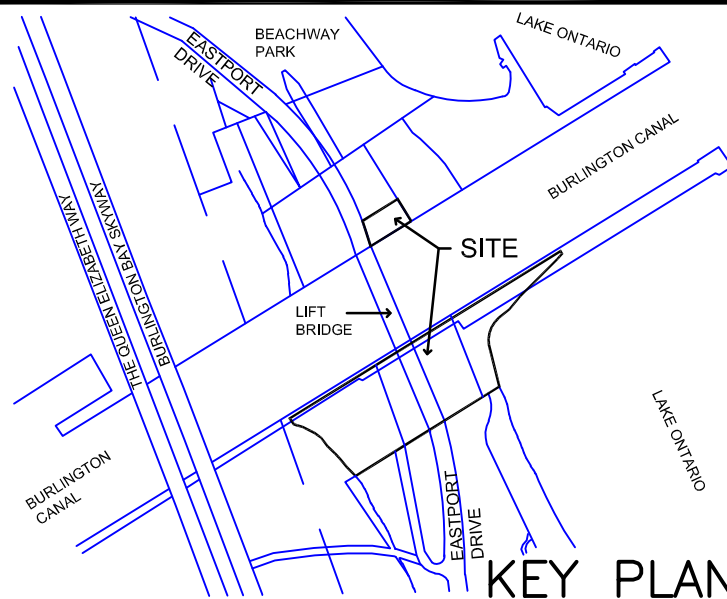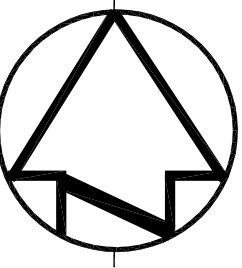

Consultant:

**MH MORRISON HERSHFIELD**  
Suite 300 – 125 Commerce Valley Drive W  
Markham, Ontario L3T 7W4  
Tel: 416-499-3110 Fax: 416-499-9658



revision	description	date
1	ISSUED FOR PRICING	2019/06/08

Do not scale drawings.  
Verify all dimensions and conditions on site and immediately  
notify the Departmental Representative of all discrepancies.

<div><div>A</div><div>B</div><div>C</div></div>	<div>A Detail No. No. du détail</div> <div>B drawing no. – where detail required dessin no. – où détail exigé</div> <div>C drawing no. – where detailed dessin no. – où détaillé</div>
---	--

project title  
titre du projet  
**BURLINGTON ONTARIO**  
**BURLINGTON CANAL LIFT BRIDGE (BCLB)**  
**1157 BEACH BOULEVARD**

**BARRIER-FREE WASHROOM  
RETROFIT**

drawing title  
titre du dessin  
**BARRIER FREE WASHROOM  
RETROFIT  
MECHANICAL PLAN**

drawn by  
dessiné par  
**AAA**

designed by  
conc par  
**AAA**

approved by  
approuvé par  
**—**

bid  
soumission  
**—**

project manager  
administrateur  
de projets

project date  
date du projet  
**2019-02-11**

project no.  
no. du projet  
**R.089504.120**

drawing no.  
dessiné no.  
**M-01**

