





NOTE: COORDINATE
CONDUIT ROUTE WITH
EXISTING PANEL LOCATION.

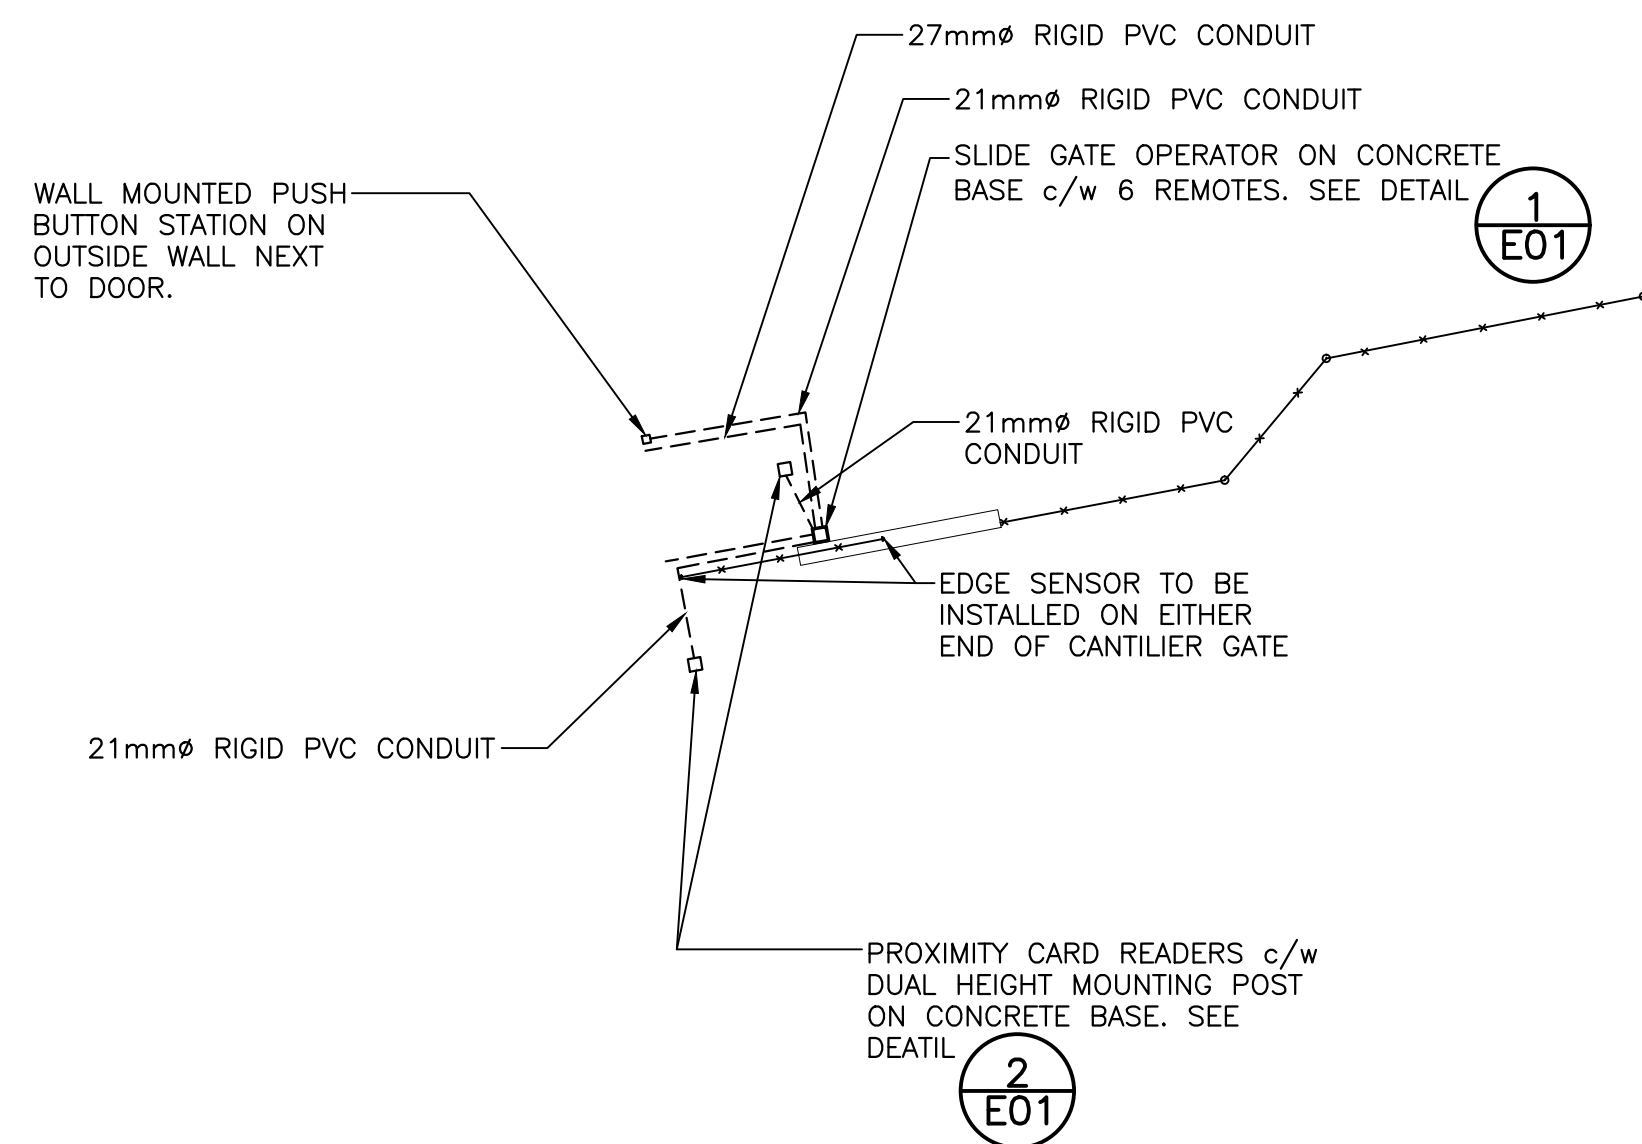

PARTIAL SITE PLAN — ELECTRICAL GATE INSTALLATION

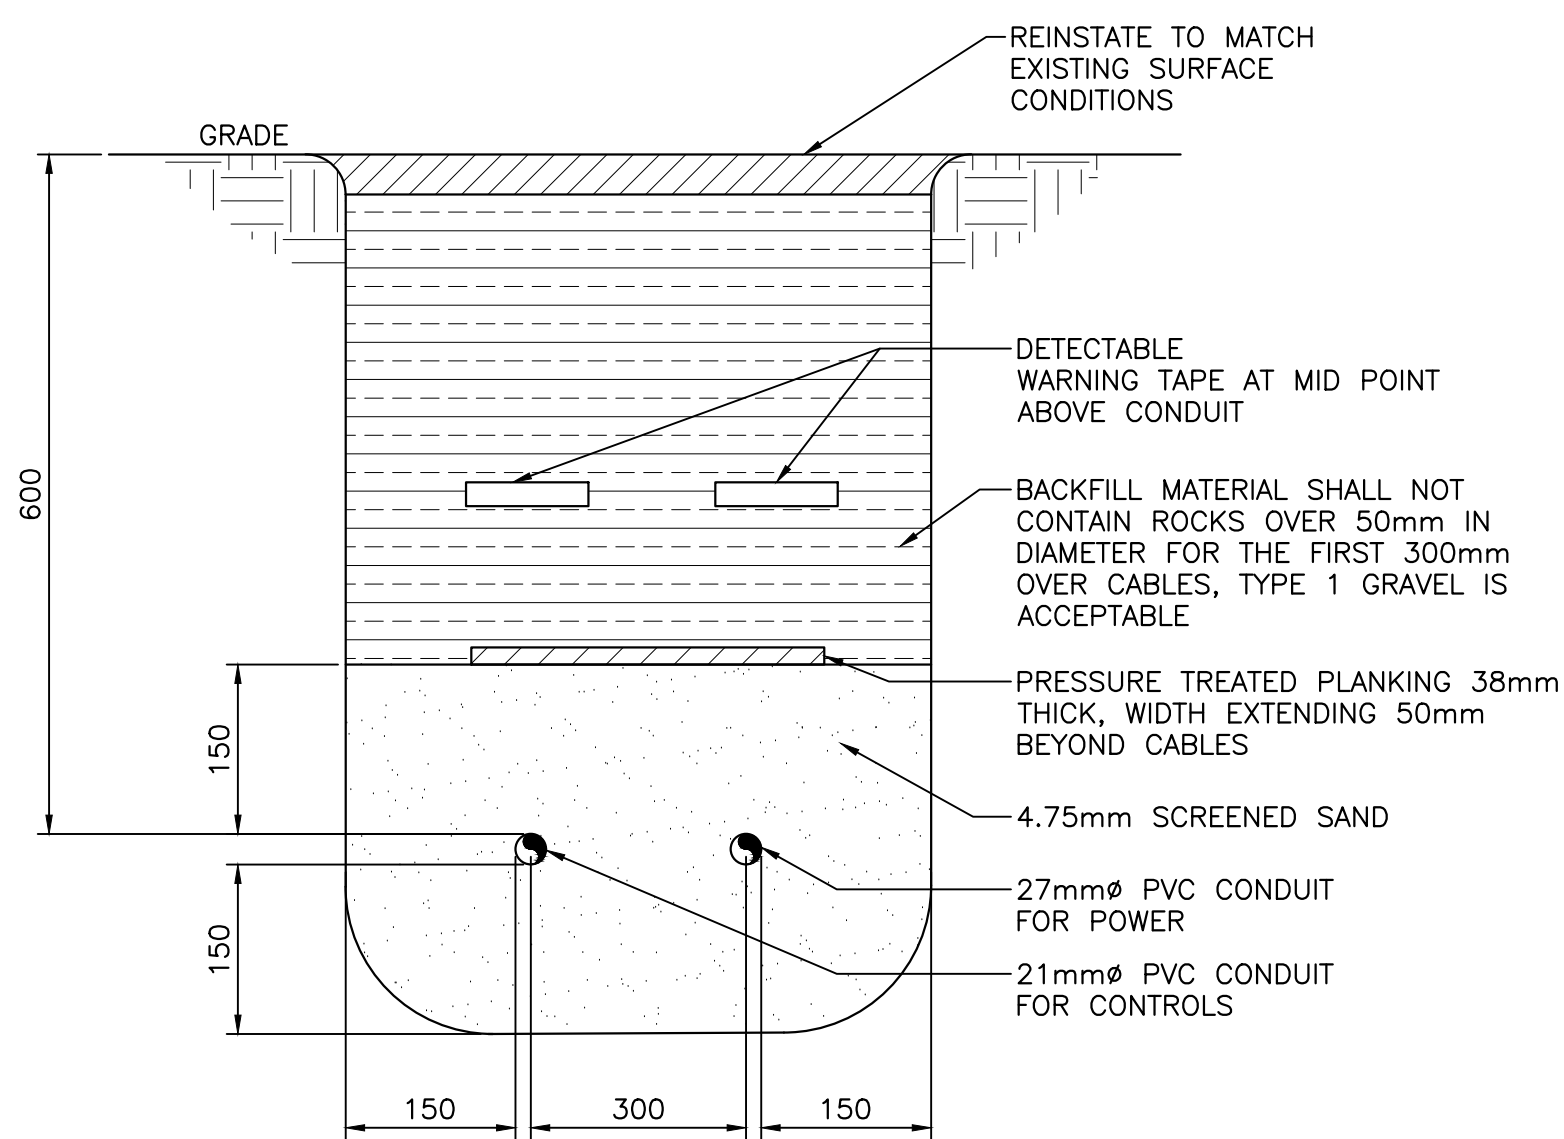


NOTES:

- ALL DIMENSIONS SHOWN ARE MINIMUMS.
- DEPTH OF BURIAL CAN BE REDUCED TO 450 IN NON-VEHICULAR AREAS


SECTION — CONDUIT TRENCH (TYP)

SCALE : N.T.S.

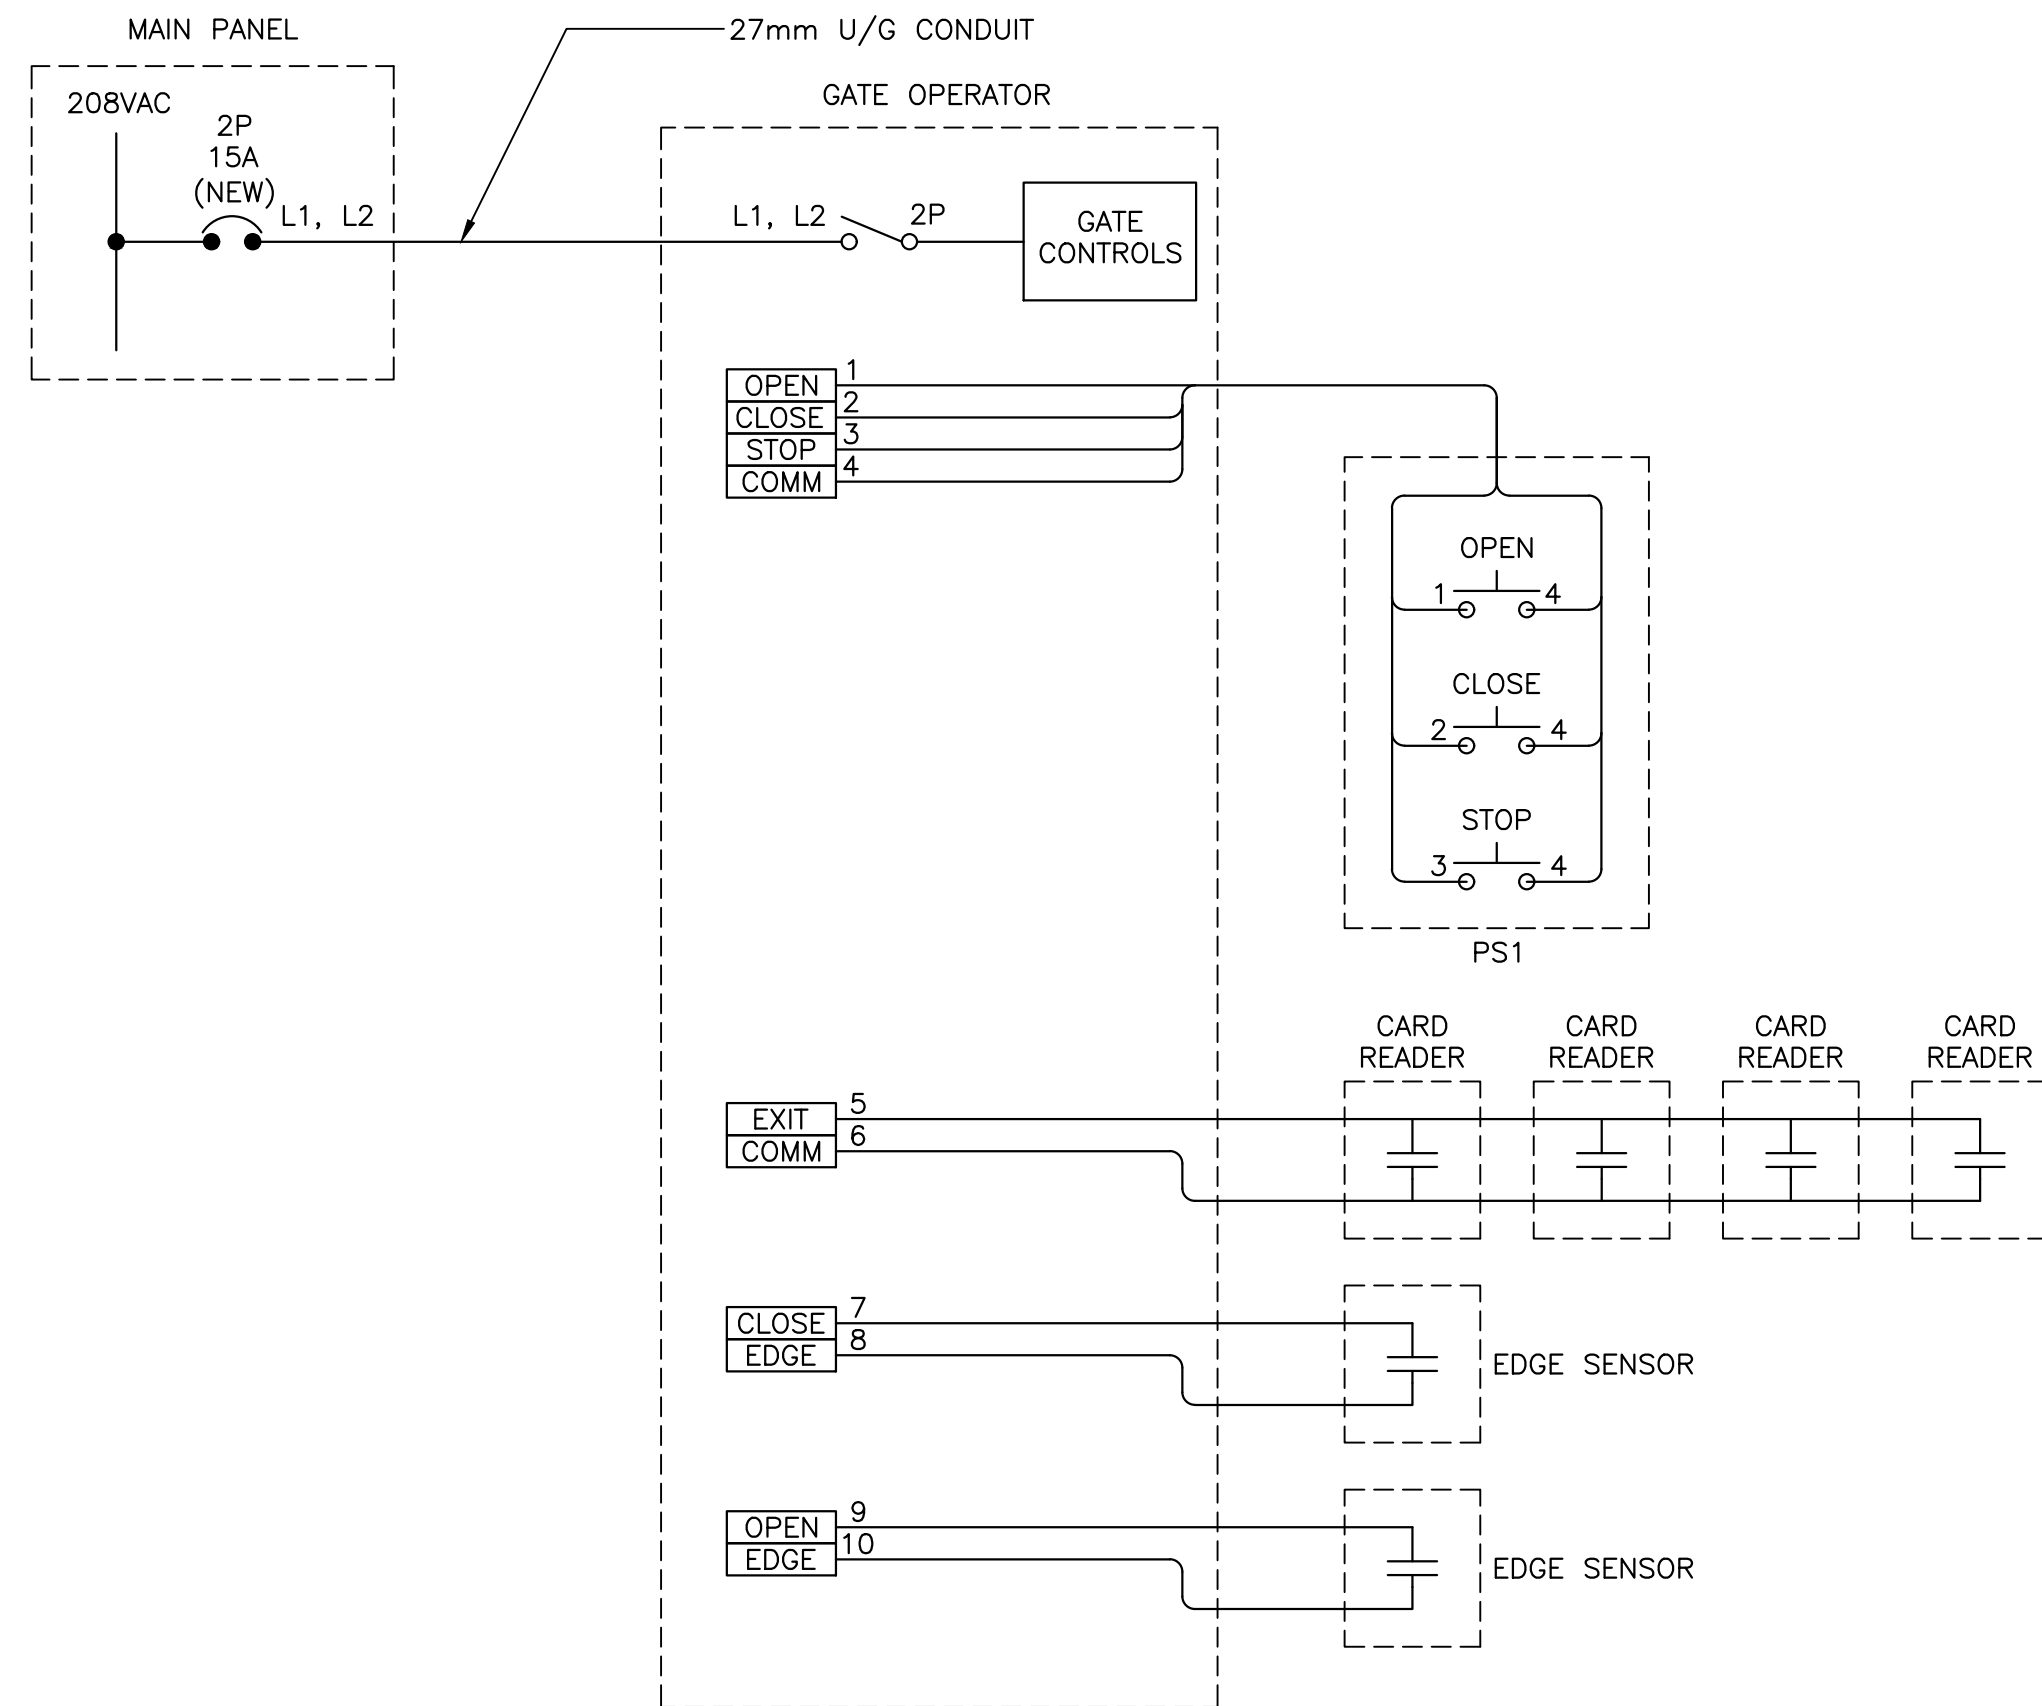


DETAIL — GATE OPERATOR WIRING DIAGRAM (TYPICAL)

SCALE : N.T.S.

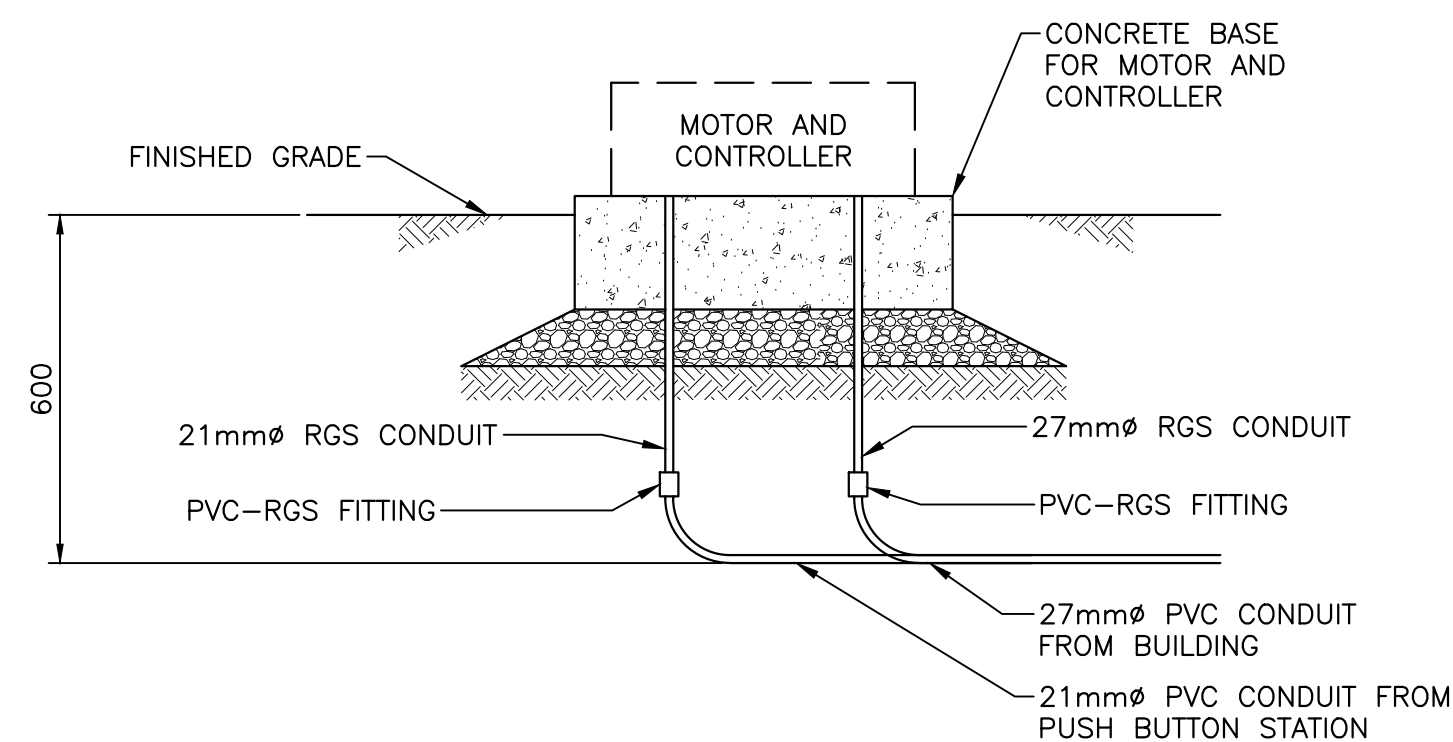

DETAIL — CONCRETE BASE

SCALE : N.T.S.

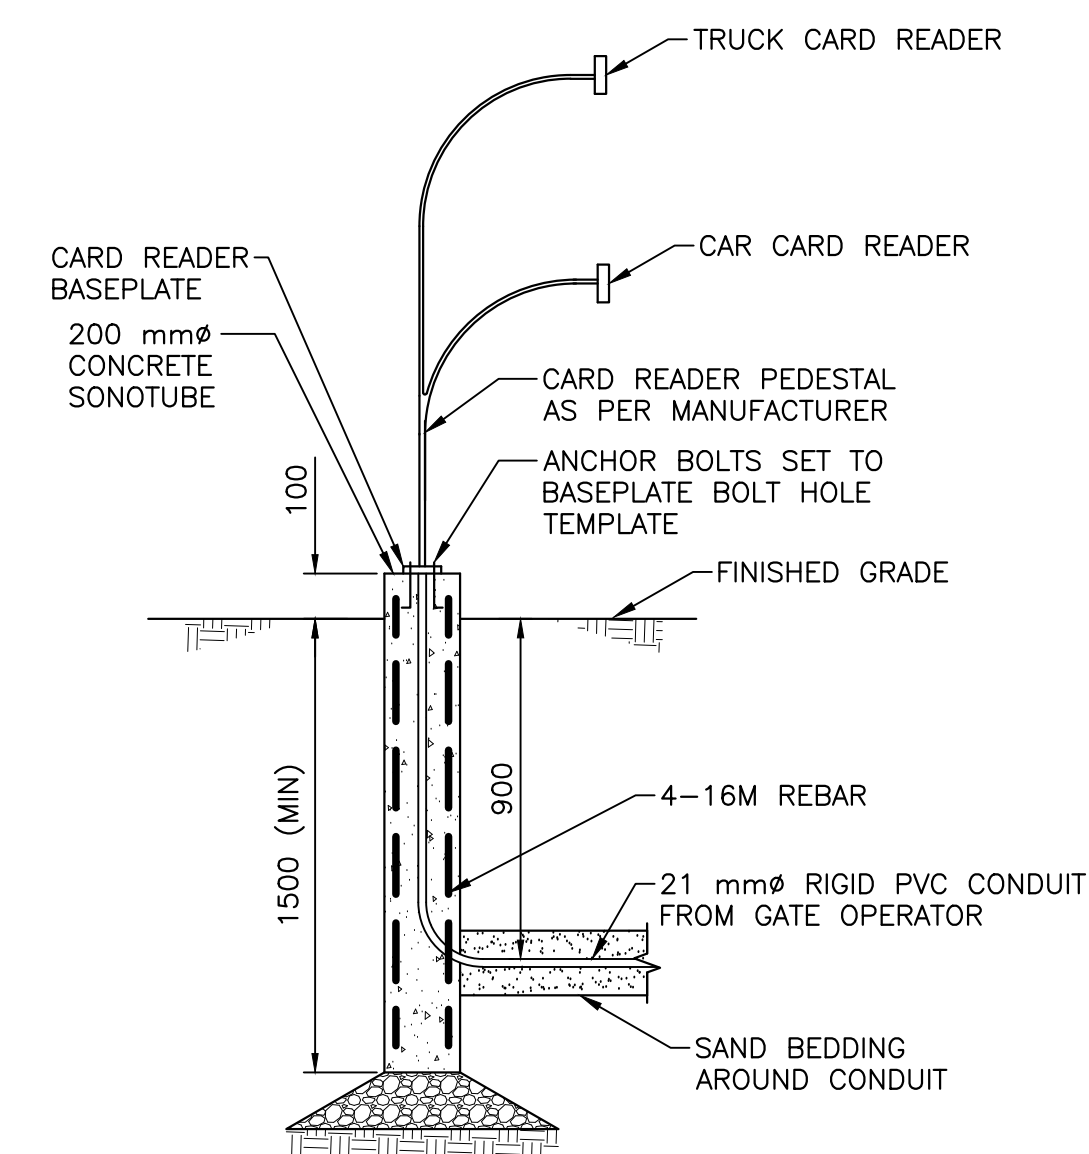

DETAIL — CARD READER

SCALE : N.T.S.