


D Konycan Nov. 26, 2019

#2018-6019

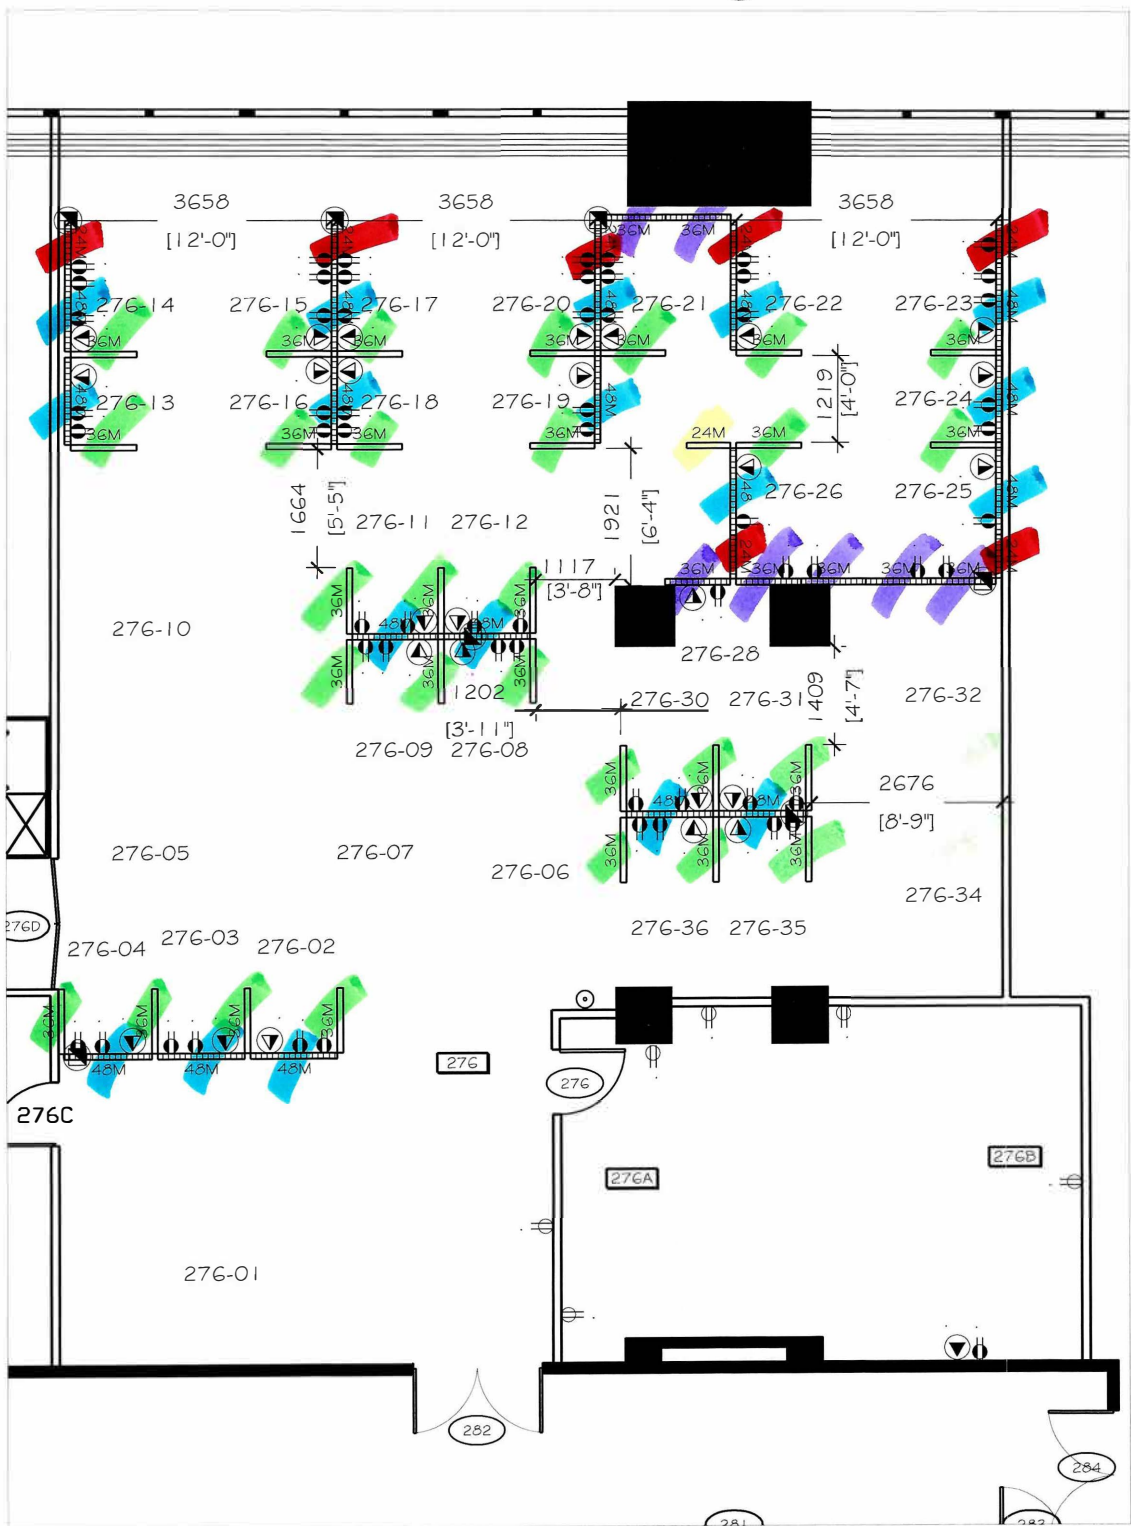

- PO
- 1-TH
- 2-TH
- MEC
- 3-S/I
- BUIL
- 4-EN
- AND
- 5-CC
- PRO
- 8-RE
- 9-AF
- ENTI
- 10-E
- EQUI

Screens, Power & Communications Plan

Scale: 1:100