




Canada Revenue Agency
 Agence du revenu du Canada

SCOPE OF WORK

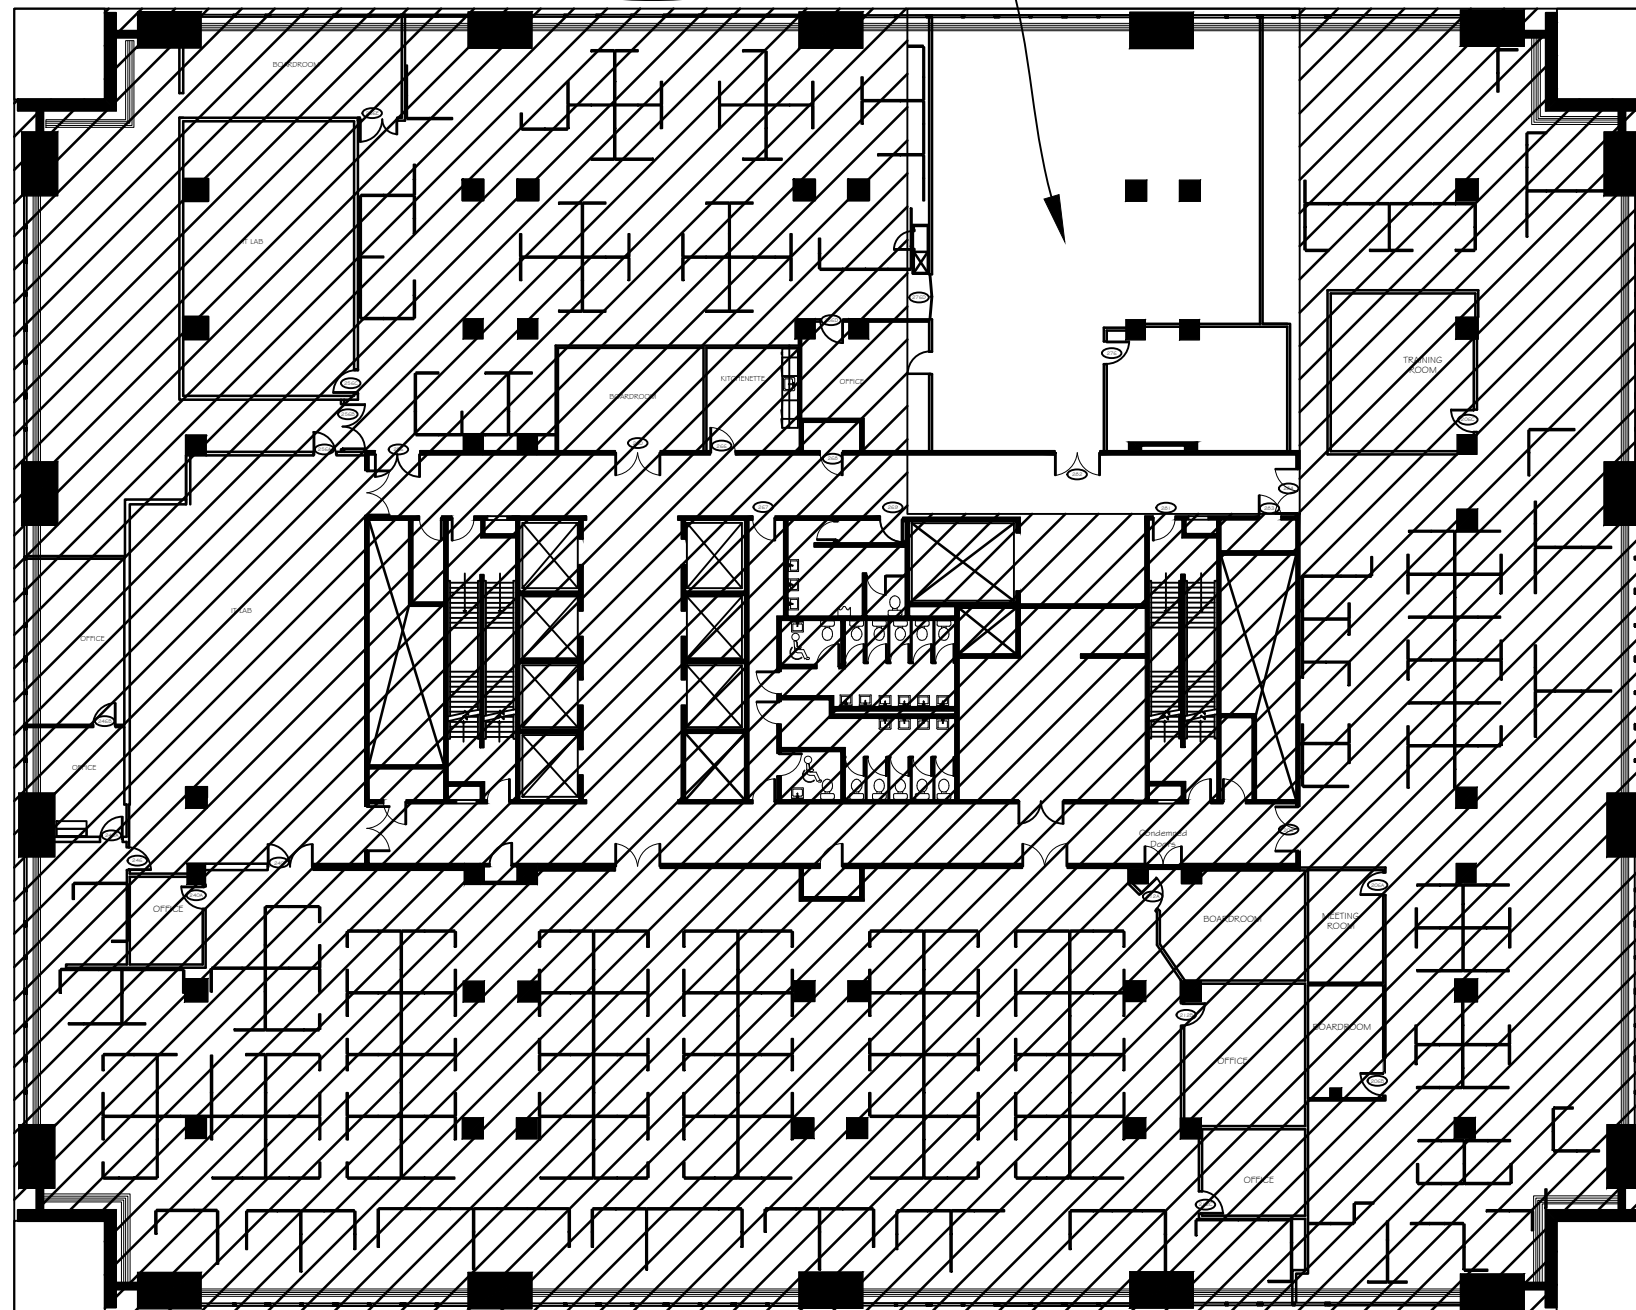

Key Plan
 Scale: 1:300

DRAWING LIST

- A0 KEY PLAN & DRAWING LIST
- A1 REPAIR & FINISHES PLAN
- A2 SCREEN & ELECTRICAL PLAN
- A3 FURNITURE PLAN

IMPORTANT

This drawing is the property of CRA HQ Real Property and Service Integration Directorate and all copyright is reserved. No use may be made of this drawing without express written consent.

Dimensions on drawing for estimating purposes only. It is the responsibility of each contractor to check all dimensions and conditions on site prior to implementation and to adhere to all pertinent codes and bylaws. Any discrepancies or omissions are to be reported to the designer prior to construction for verification.

DO NOT scale off the drawing unless it is otherwise noted.



A. detail no.



B. indicated on page no.

C. drawn on page no.

REVISIONS

NO.	DESCRIPTION	DATE

PROJECT
 CANADA REVENUE AGENCY
 875 HERON
 2nd FLOOR
 ROOM 265

DRAWING TITLE
 TITLE PAGE

DESIGNED	DRAWN BY	PROJECT NO.
E. THIBODEAU	E. THIBODEAU	2018-6019
SCALE	DATE	DRAWING NO.
AS SHOWN	15 OCT 2019	A0