


1 DEMOLITION
NTS

DRAWING NOTES

1. REMOVE EXISTING CONDUCTORS BETWEEN BOTH AT'S AND THE GENERATOR CONTROL PANELS THEY ARE SUPPLIED FROM.
2. CONTROL WIRING IS TO BE ARMORED CABLES AND ARE TO RUN FROM CONTACT IN AT'S TO A TERMINAL BLOCK IN NEW TAP BOX. CONTROL IS BY NEW SELECTOR SWITCHES TO BE PROVIDED AND INSTALLED BY CONTRACTOR. REFER TO E-8-P2 DETAIL 3 FOR FURTHER INFORMATION.
3. PROVIDE LABEL TO INDICATE THAT THE TEMPORARY GENERATOR WYE POINT IS TO BE BONDED TO GROUND.

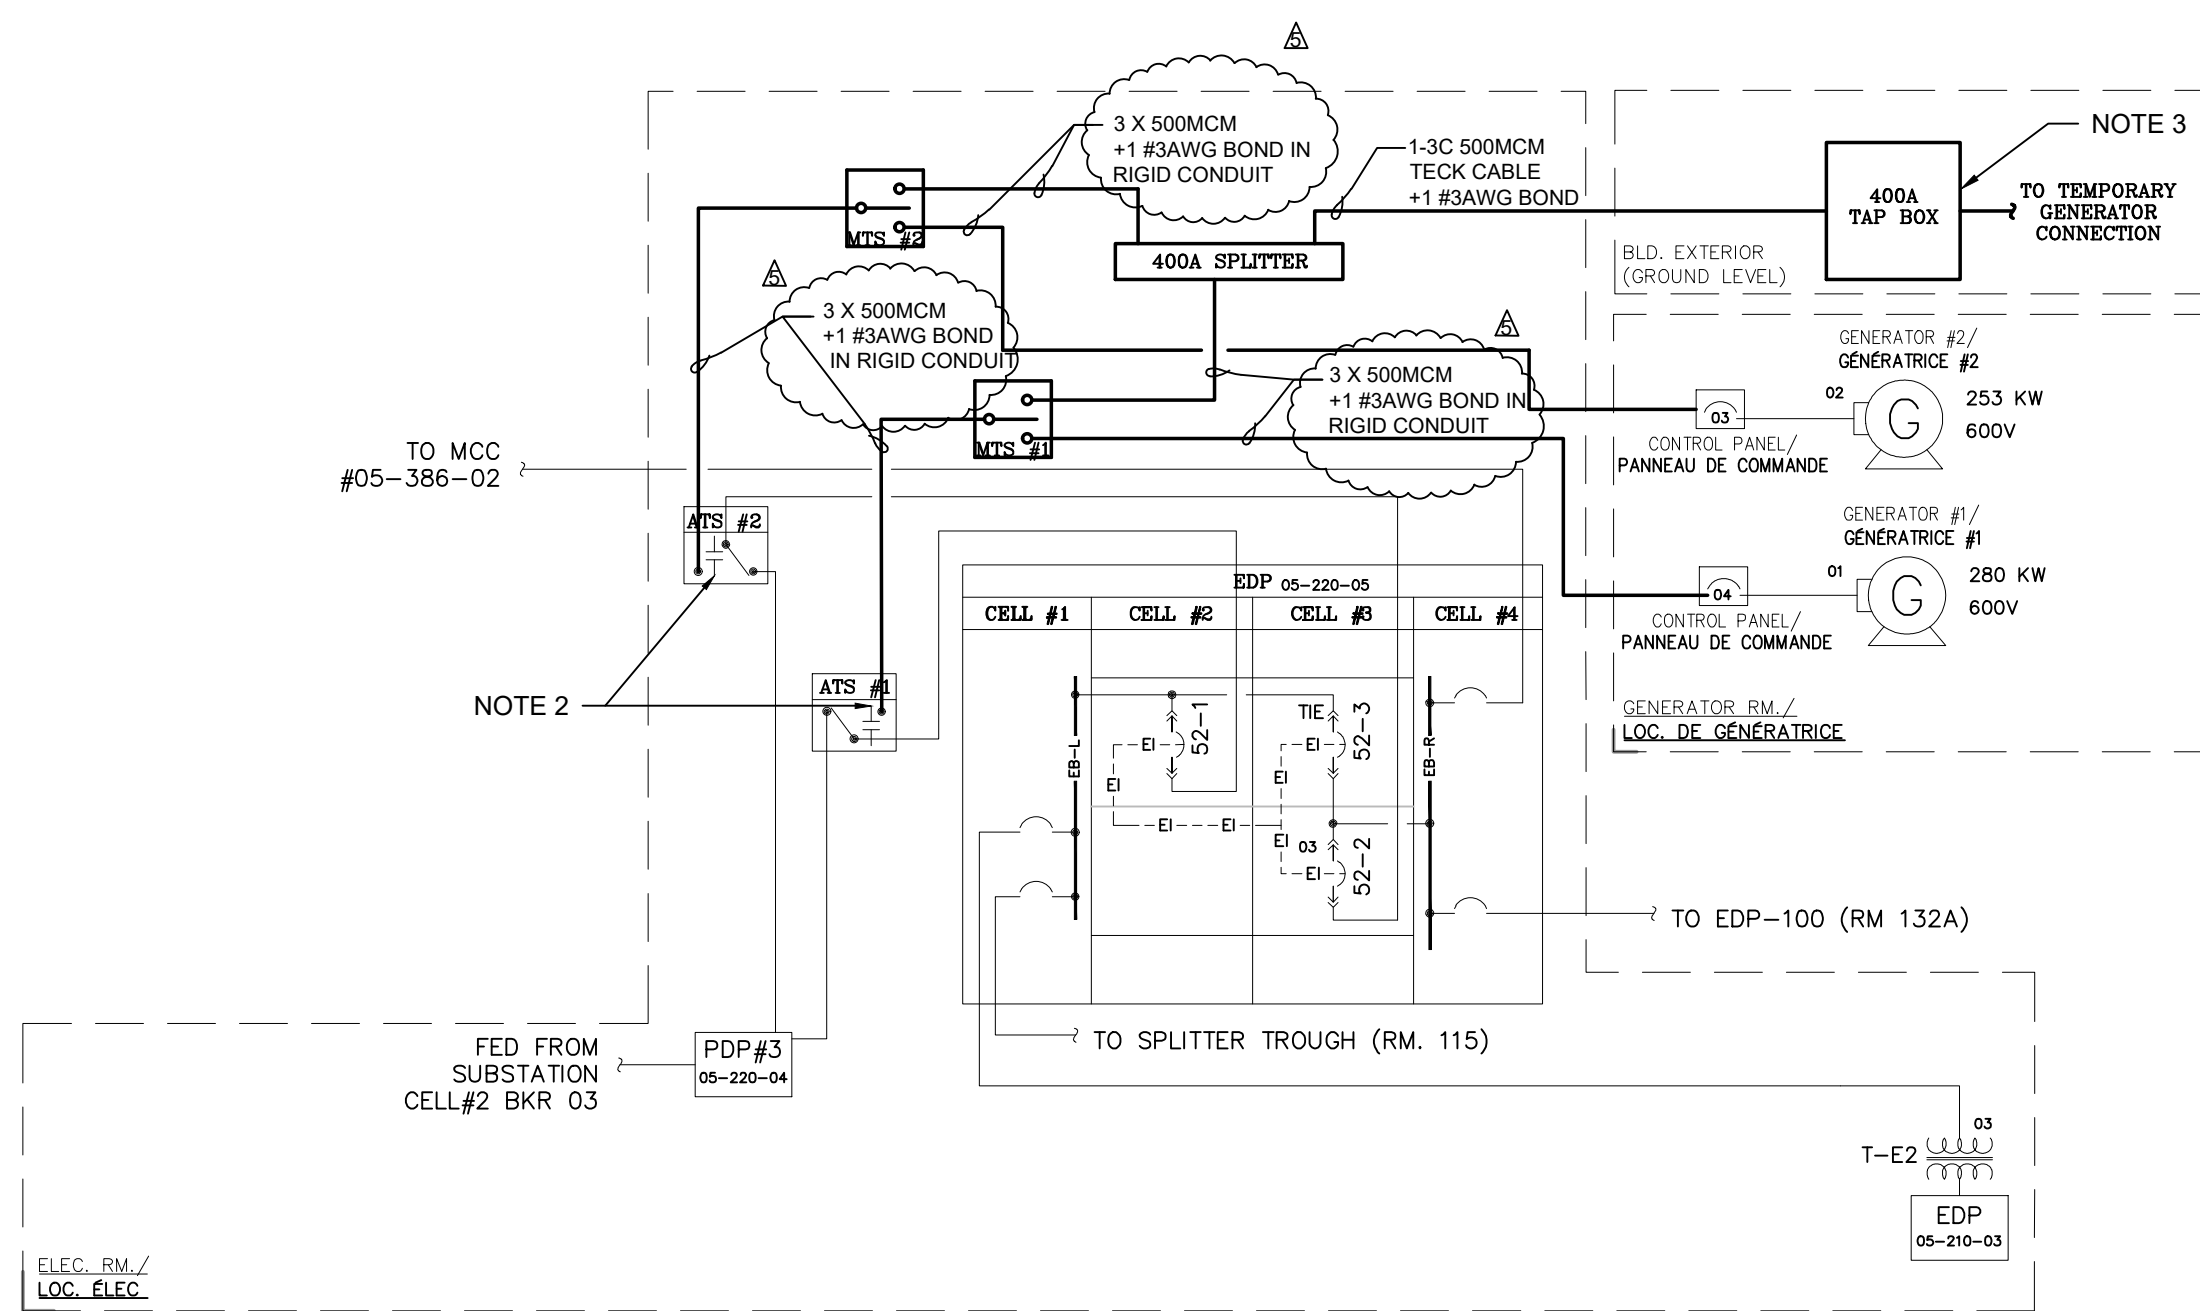

2 NEW WORK
NTS

STAMP:

CONSULTANT:
MH MORRISON HERSHFIELD
200-2932 Baseline Road
Ottawa, ON K2H 1B1
Tel: (613) 739-2910 Fax: (613) 739-4926

REV	DESCRIPTION	DATE	BY
5	RESPONSE TO QUESTION #1	2020.01.14	WJS
4	ISSUED FOR TENDER - REV. 2	2019.12.23	WJS
3	ISSUED FOR TENDER - REV. 1	2019.12.11	WJS
2	ISSUED FOR TENDER	2019.12.09	WJS
1	ISSUED FOR 75% CLIENT REVIEW	2019.11.28	WJS

DO NOT SCALE DRAWINGS. CONTRACTOR MUST VERIFY ALL DIMENSIONS AND ADVISE CONSULTANTS OF ANY ERRORS OR OMISSIONS. NO VARIATIONS OR MODIFICATIONS TO WORK SHOWN SHALL BE IMPLEMENTED WITHOUT PRIOR WRITTEN APPROVAL. ALL PREVIOUS ISSUES OF THIS DRAWING ARE SUPERSEDED BY THE LATEST REVISION. ALL DRAWINGS AND SPECIFICATIONS REMAIN THE PROPERTY OF MORRISON HERSHFIELD LIMITED.

SHEET TITLE:
RADIATION PROTECTION BUILDING SINGLE LINE DIAGRAM

DRAWN BY: PW	DATE: 2019.11.22
DESIGNED BY: WJS	CHECKED BY: KS
SCALE: NTS	DWG FILE:
Project No: 1904432.00	Drawing No: E-3-P2