 



LEVEL 1\_NEW REFLECTED CEILING PLAN

SCALE : 1:100




4

A201

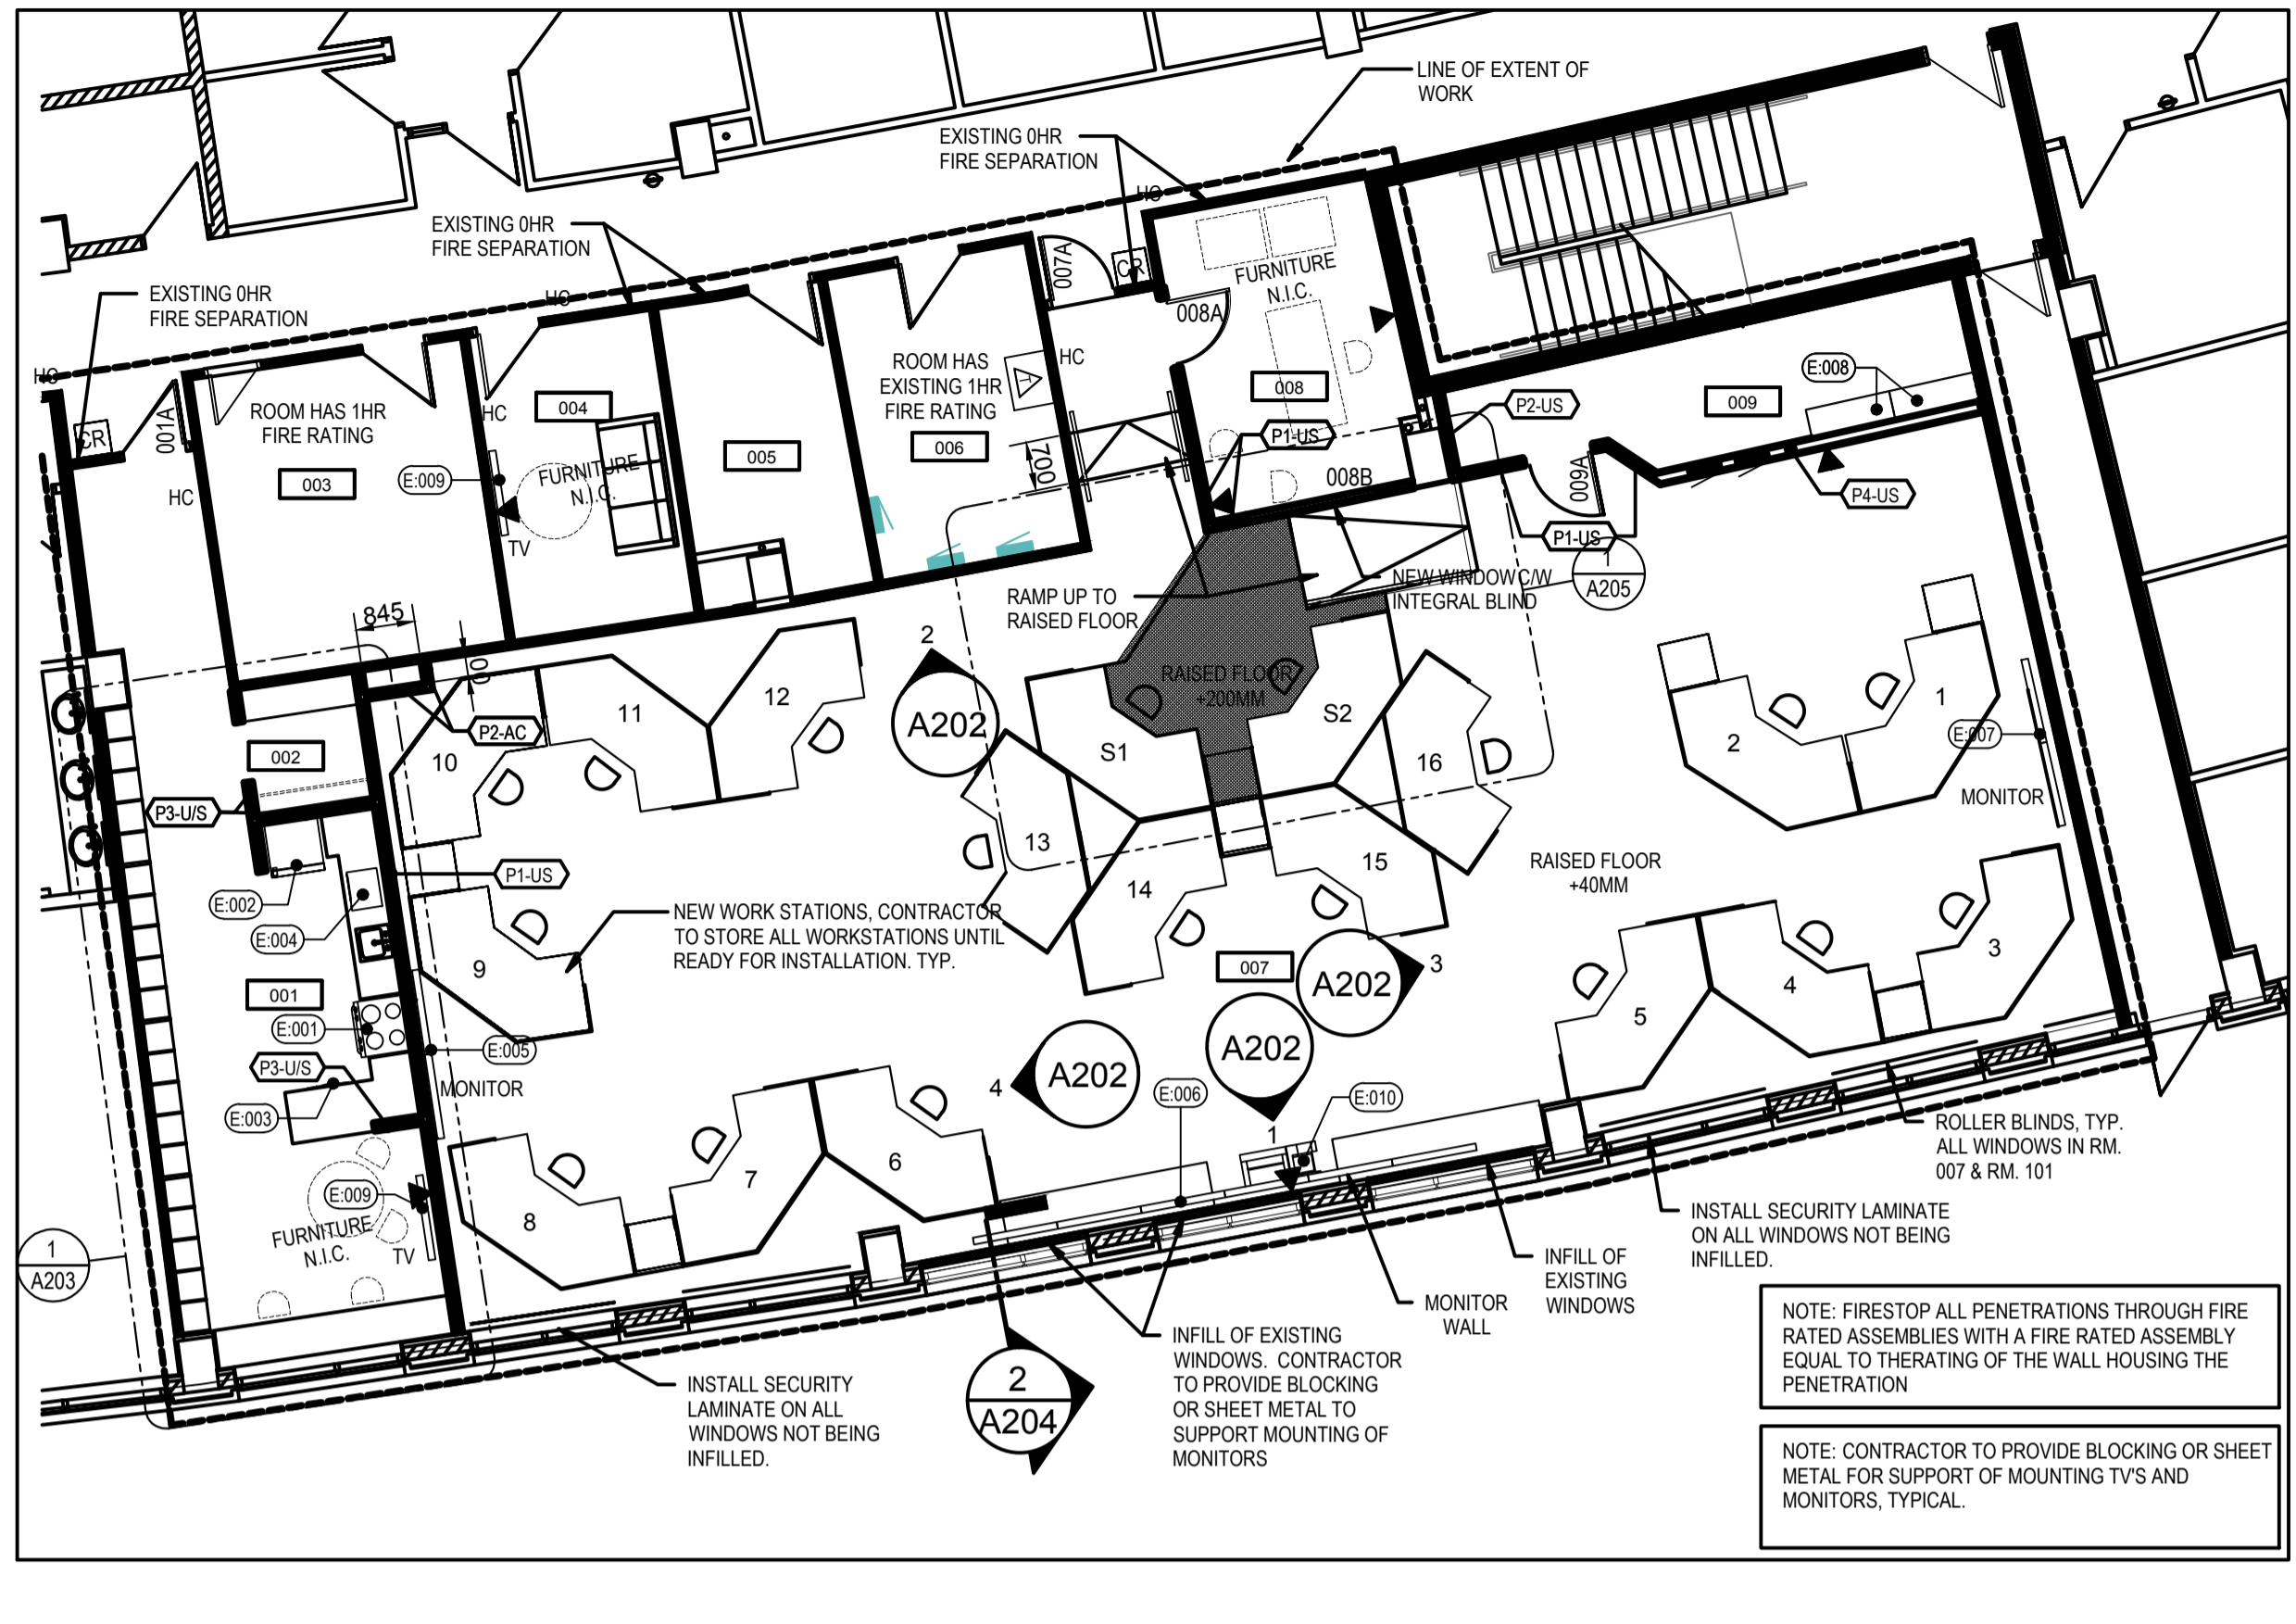

LEVEL 1\_NEW GENERAL FLOOR PLAN

 SCALE : 1:100




2

A201




LEVEL 1\_EXISTING / DEMO REFLECTED CEILING PLAN

 SCALE : 1:100




3

A201

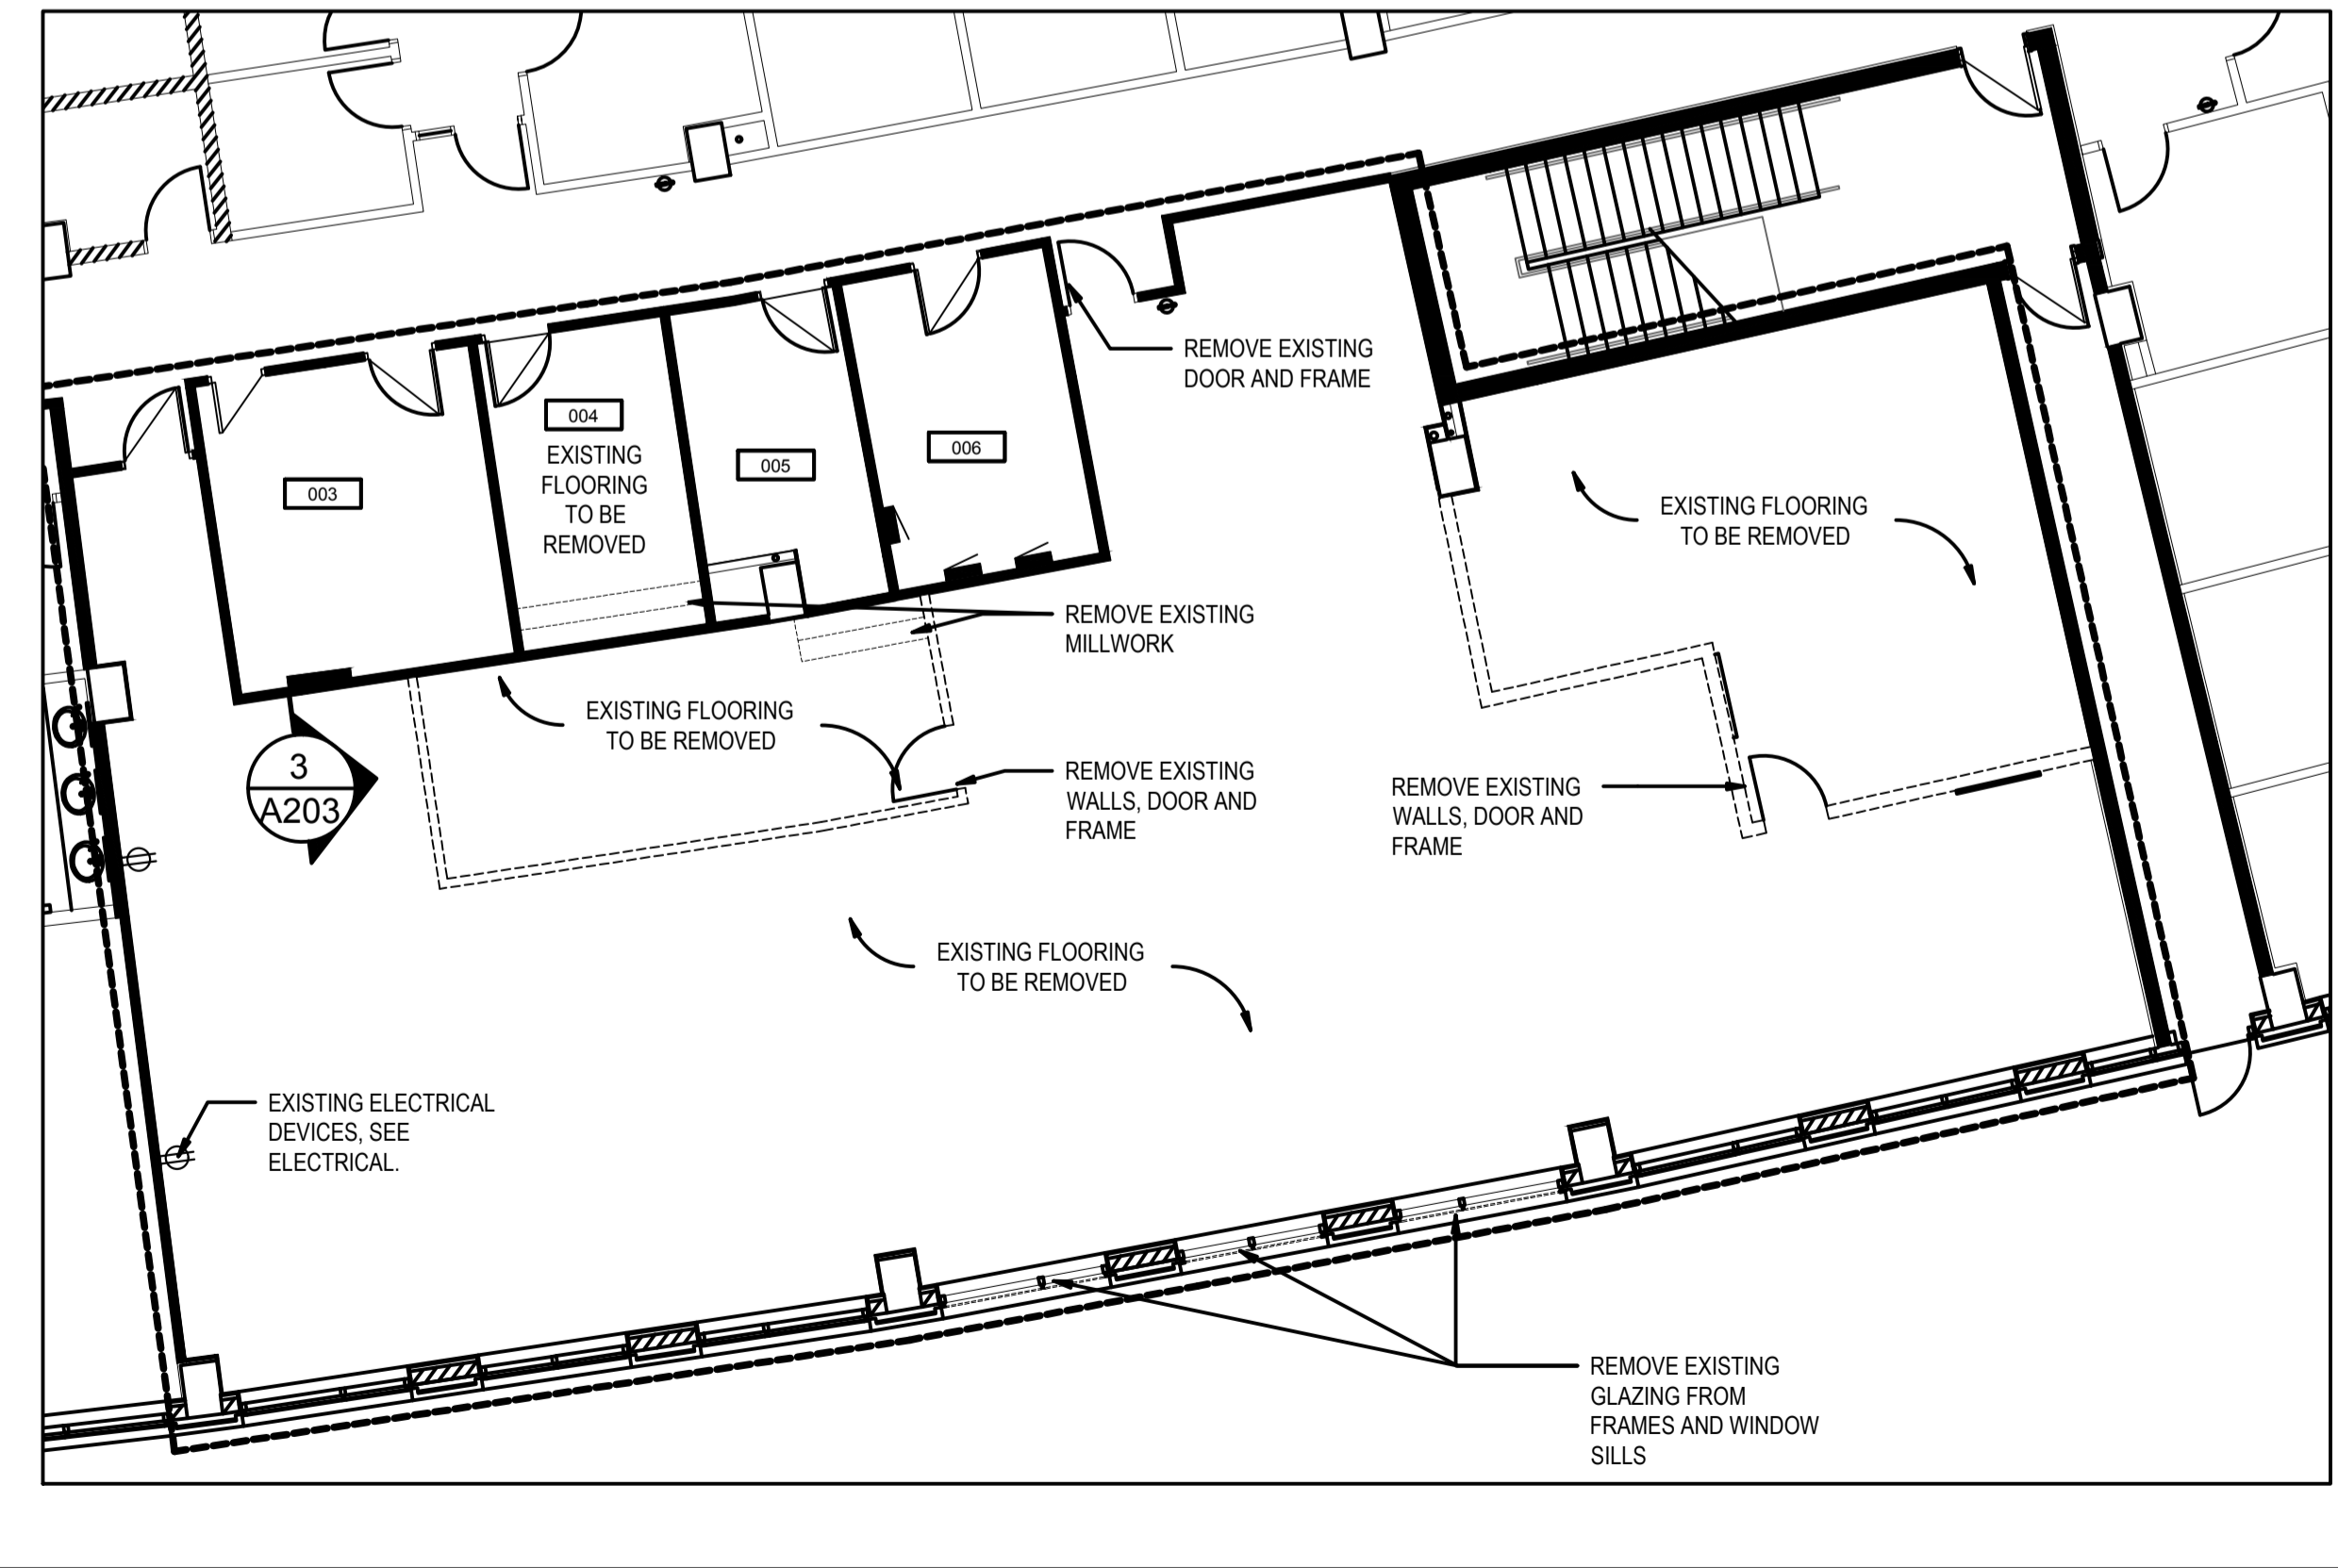

LEVEL 1\_EXISTING / DEMO FLOOR PLAN

 SCALE : 1:100



1

A201

THIS FILE AND INFORMATION CONTAINED WITHIN IS A WORKING FILE, AS SUCH STANTEC CANNOT GUARANTEE THE AUTHENTICITY, INTEGRITY OR COMPLETENESS OF DATA SUPPLIED IN ELECTRONIC FORMAT. ANY USER OF THIS FILE SHALL RELEASE, INDEMNIFY AND HOLD STANTEC, ITS OFFICES, EMPLOYEES, CONSULTANTS AND AGENTS HARMLESS FROM ANY CLAIMS OR DAMAGES ARISING FROM THE USE OF ELECTRONIC FILES. ALL TITLES, BLOCKS, STAMPS OR SEALS REMAIN THE PROPERTY OF STANTEC, AND ARE NOT TO BE USED FOR ANY PURPOSE OTHER THAN FOR WHICH THEY ARE TRANSMITTED AND ARE NOT TRANSMITTED TO A THIRD PARTY WITHOUT STANTEC'S WRITTEN CONSENT.

0	ISSUED FOR TENDER	NOV 13 2019
revisions		date

TS - Operations Centre Ft  
 Up GOCB H Division HQ

FLOOR PLANS &  
 REFLECTED CEILING PLANS

designed	BMD	conçu
date	08/01/19	
drawn	SG	dessiné
date	08/01/19	
approved		approuvé
date	08/01/19	
Tender		Soumission
PWGSC Project Manager	Administrateur de projets TPSGC	
project number		no. du projet

2271428

drawing no. no. du dessin

A201