

TWEEDIE & ASSOCIATES
CONSULTING ENGINEERS LTD.
 33 Pine Glen Road, Riverview, NB E1B 1V3
 e-mail: tace@tace.ca
 Tel: 506-383-8223 / Fax: 506-382-8223

0	ADDENDUM 1	10/02 2020
revisions		date
project		project

552613
ATLANTIC INSTITUTION
HEATING PLANT UPGRADE

drawing / dessin

BOILER ROOM PLAN
BOILER PIPING
NEW LAYOUT


designed	BSM	conçu
date	2 OCT 2020	
drawn	BSM	dessiné
date	2 OCT 2020	
approved	BSM	approuvé
date	2 OCT 2020	
Tender		Soumission

PWGSC Project Manager / Administrateur de projets TPSGC

project number / no. du projet
R.087698.001


drawing no. / no. du dessin
SKH-01

MAINTENANCE CLEARANCE 1
 BOILERS (REFER TO DET)

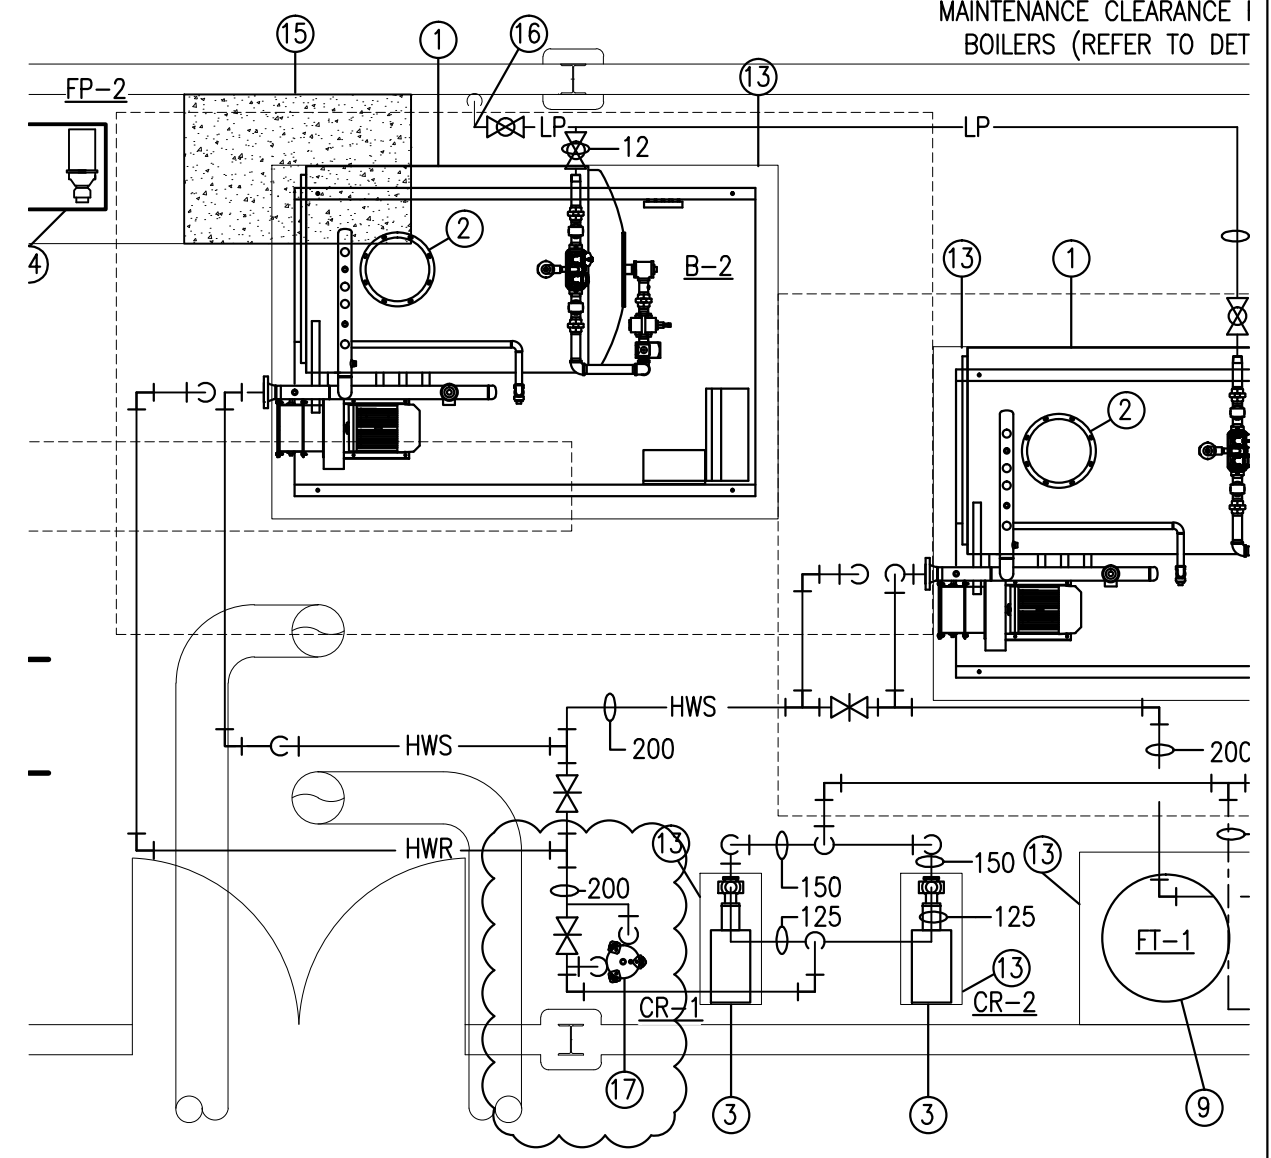

BOILER ROOM PLAN
BOILER PIPING NEW LAYOUT
 SCALE : 1:50

- ⑮ REMOVE SECTION OF EXISTING CONCRETE PAD AS SHOWN TO ACCOMMODATE NEW BOILER HOUSEKEEPING PAD IN THIS LOCATION.
- ⑯ CONNECT NEW LP GAS PIPING TO EXISTING PIPING IN LOCATION SHOWN. PIPE TO EACH BOILER FOR BURNER PILOT OPERATION.
- ⑰ NEW CHEMICAL BY-PASS FEEDER

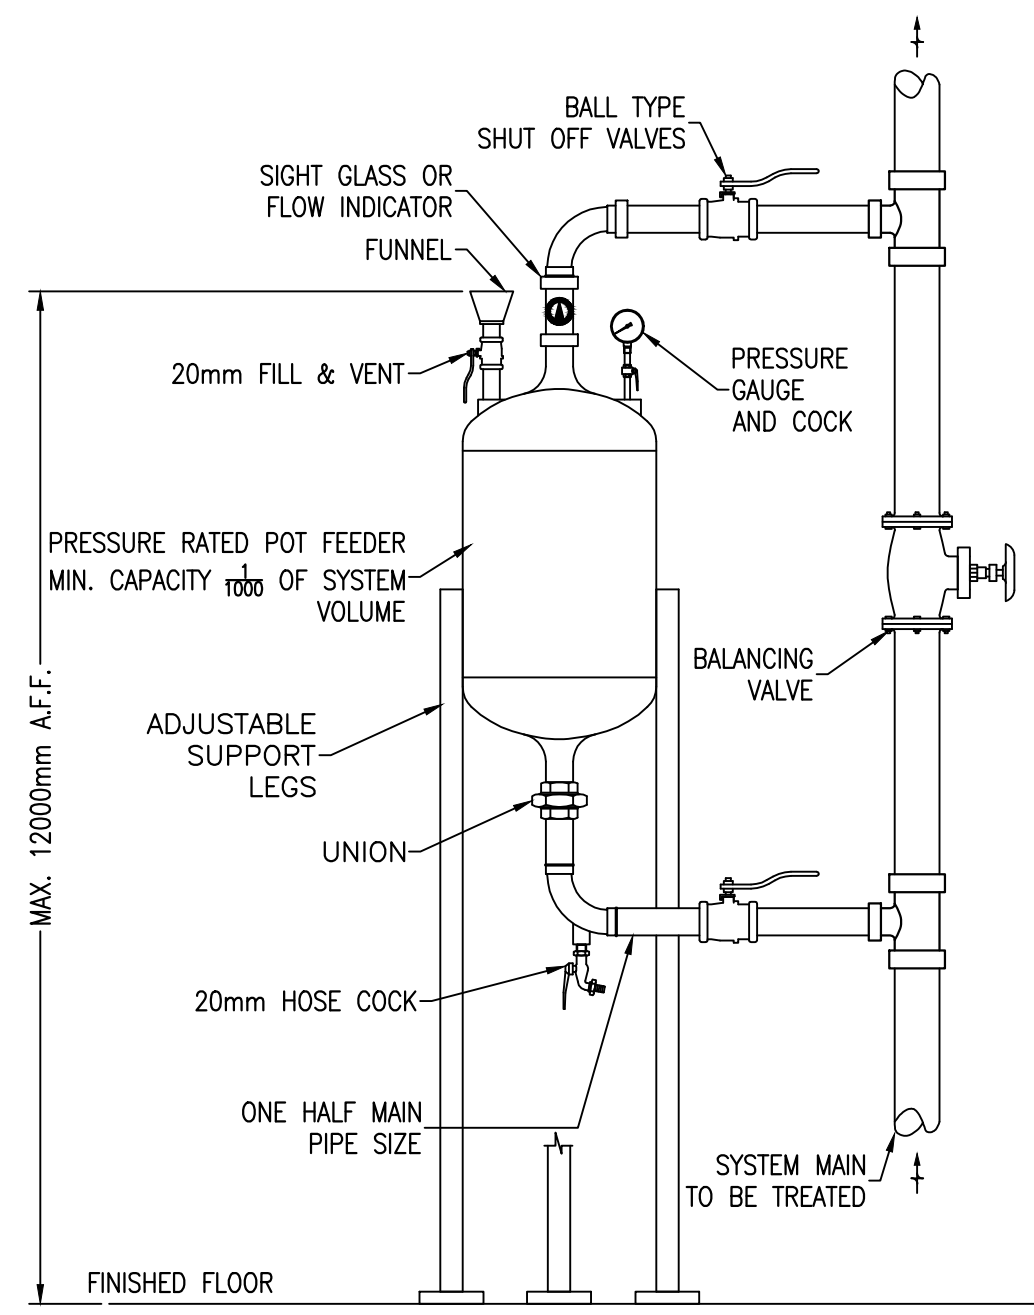

CHEMICAL POT FEEDER DETAIL
 SCALE : NTS