




### WS-2 TYPICAL WORKSTATION

#### CATEGORY 1A

REFER TO FLOOR PLANS.

POWER OUTLET BELOW WORK SURFACE

LAN & DATA OUTLETS AS PER THIS TYPICAL WS-2

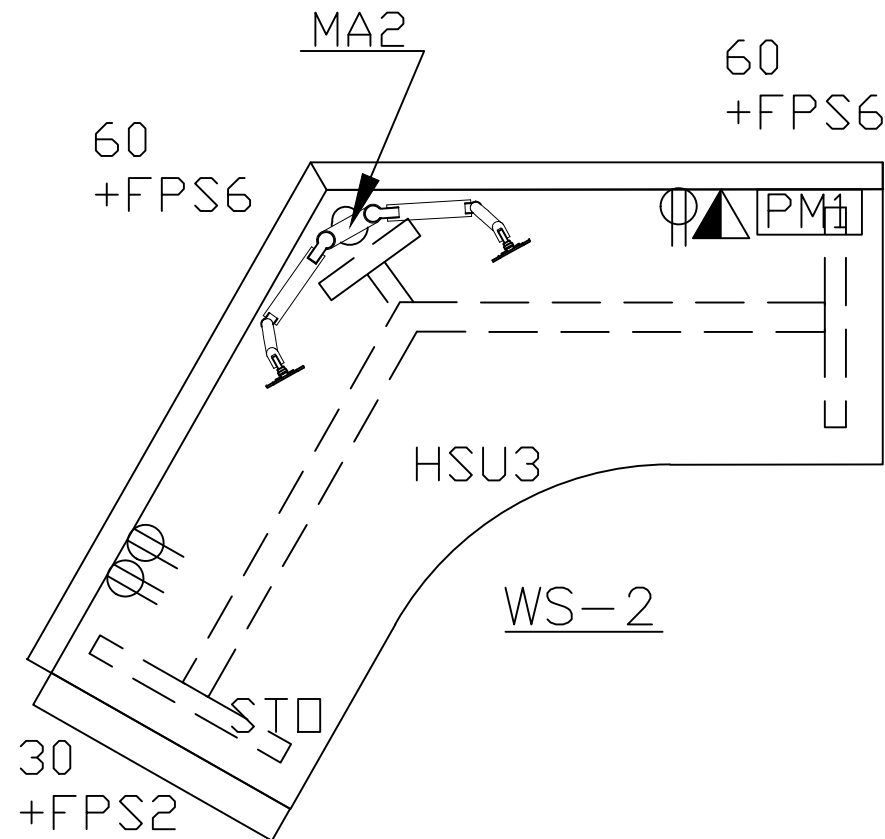

#### CATEGORY 1B

FPS2 762 (30") PRIVACY SCREEN, PANEL MOUNTED, FROSTED GLASS

FPS6 1524 (60") PRIVACY SCREEN, PANEL MOUNTED, FROSTED GLASS

#### CATEGORY 2

HSU 3 1524 (60) X 762 (30) HEIGHT ADJUSTABLE WORK SURFACE, HIGH PRESSURE LAMINATE, ELECTRICALLY ASSISTED, 3 LEG BASE

#### CATEGORY 5

MA2 MONITOR ARM, DUAL MONITOR, GROMMET MOUNT

PM1 DESK TOP POWER MODULE

STO UNDER SURFACE MOUNTED HOOK

104 in' Floor to ceiling

			Location	9 MONTCLAIR HUB - 2ND FLOOR - WS-2 TYPICAL WORKSTATION		Approval:	Date: 2021-01-07	
			Project Name	9 MONTCLAIR HUB - 2ND FLOOR - GATINEAU - QUEBEC		Drawn by: Louise Durivage	Scale: NTS	Page: 1/1
No.	Description	Date						