



GENERAL NOTES:

- A. ENSURE ELECTRICAL SERVICE IS DE-ENERGIZED PRIOR TO COMMENCING WITH DEMOLITION.
- B. DIVISION 26 SHALL REMOVE ALL ELECTRICAL WIRING, UTILITY POLES ON SITE. ENSURE DISCONNECTED ELECTRICAL CIRCUITS ARE MARKED FOR FUTURE RE-CONNECTION PER NEW INSTALLATION ELECTRICAL PLANS.

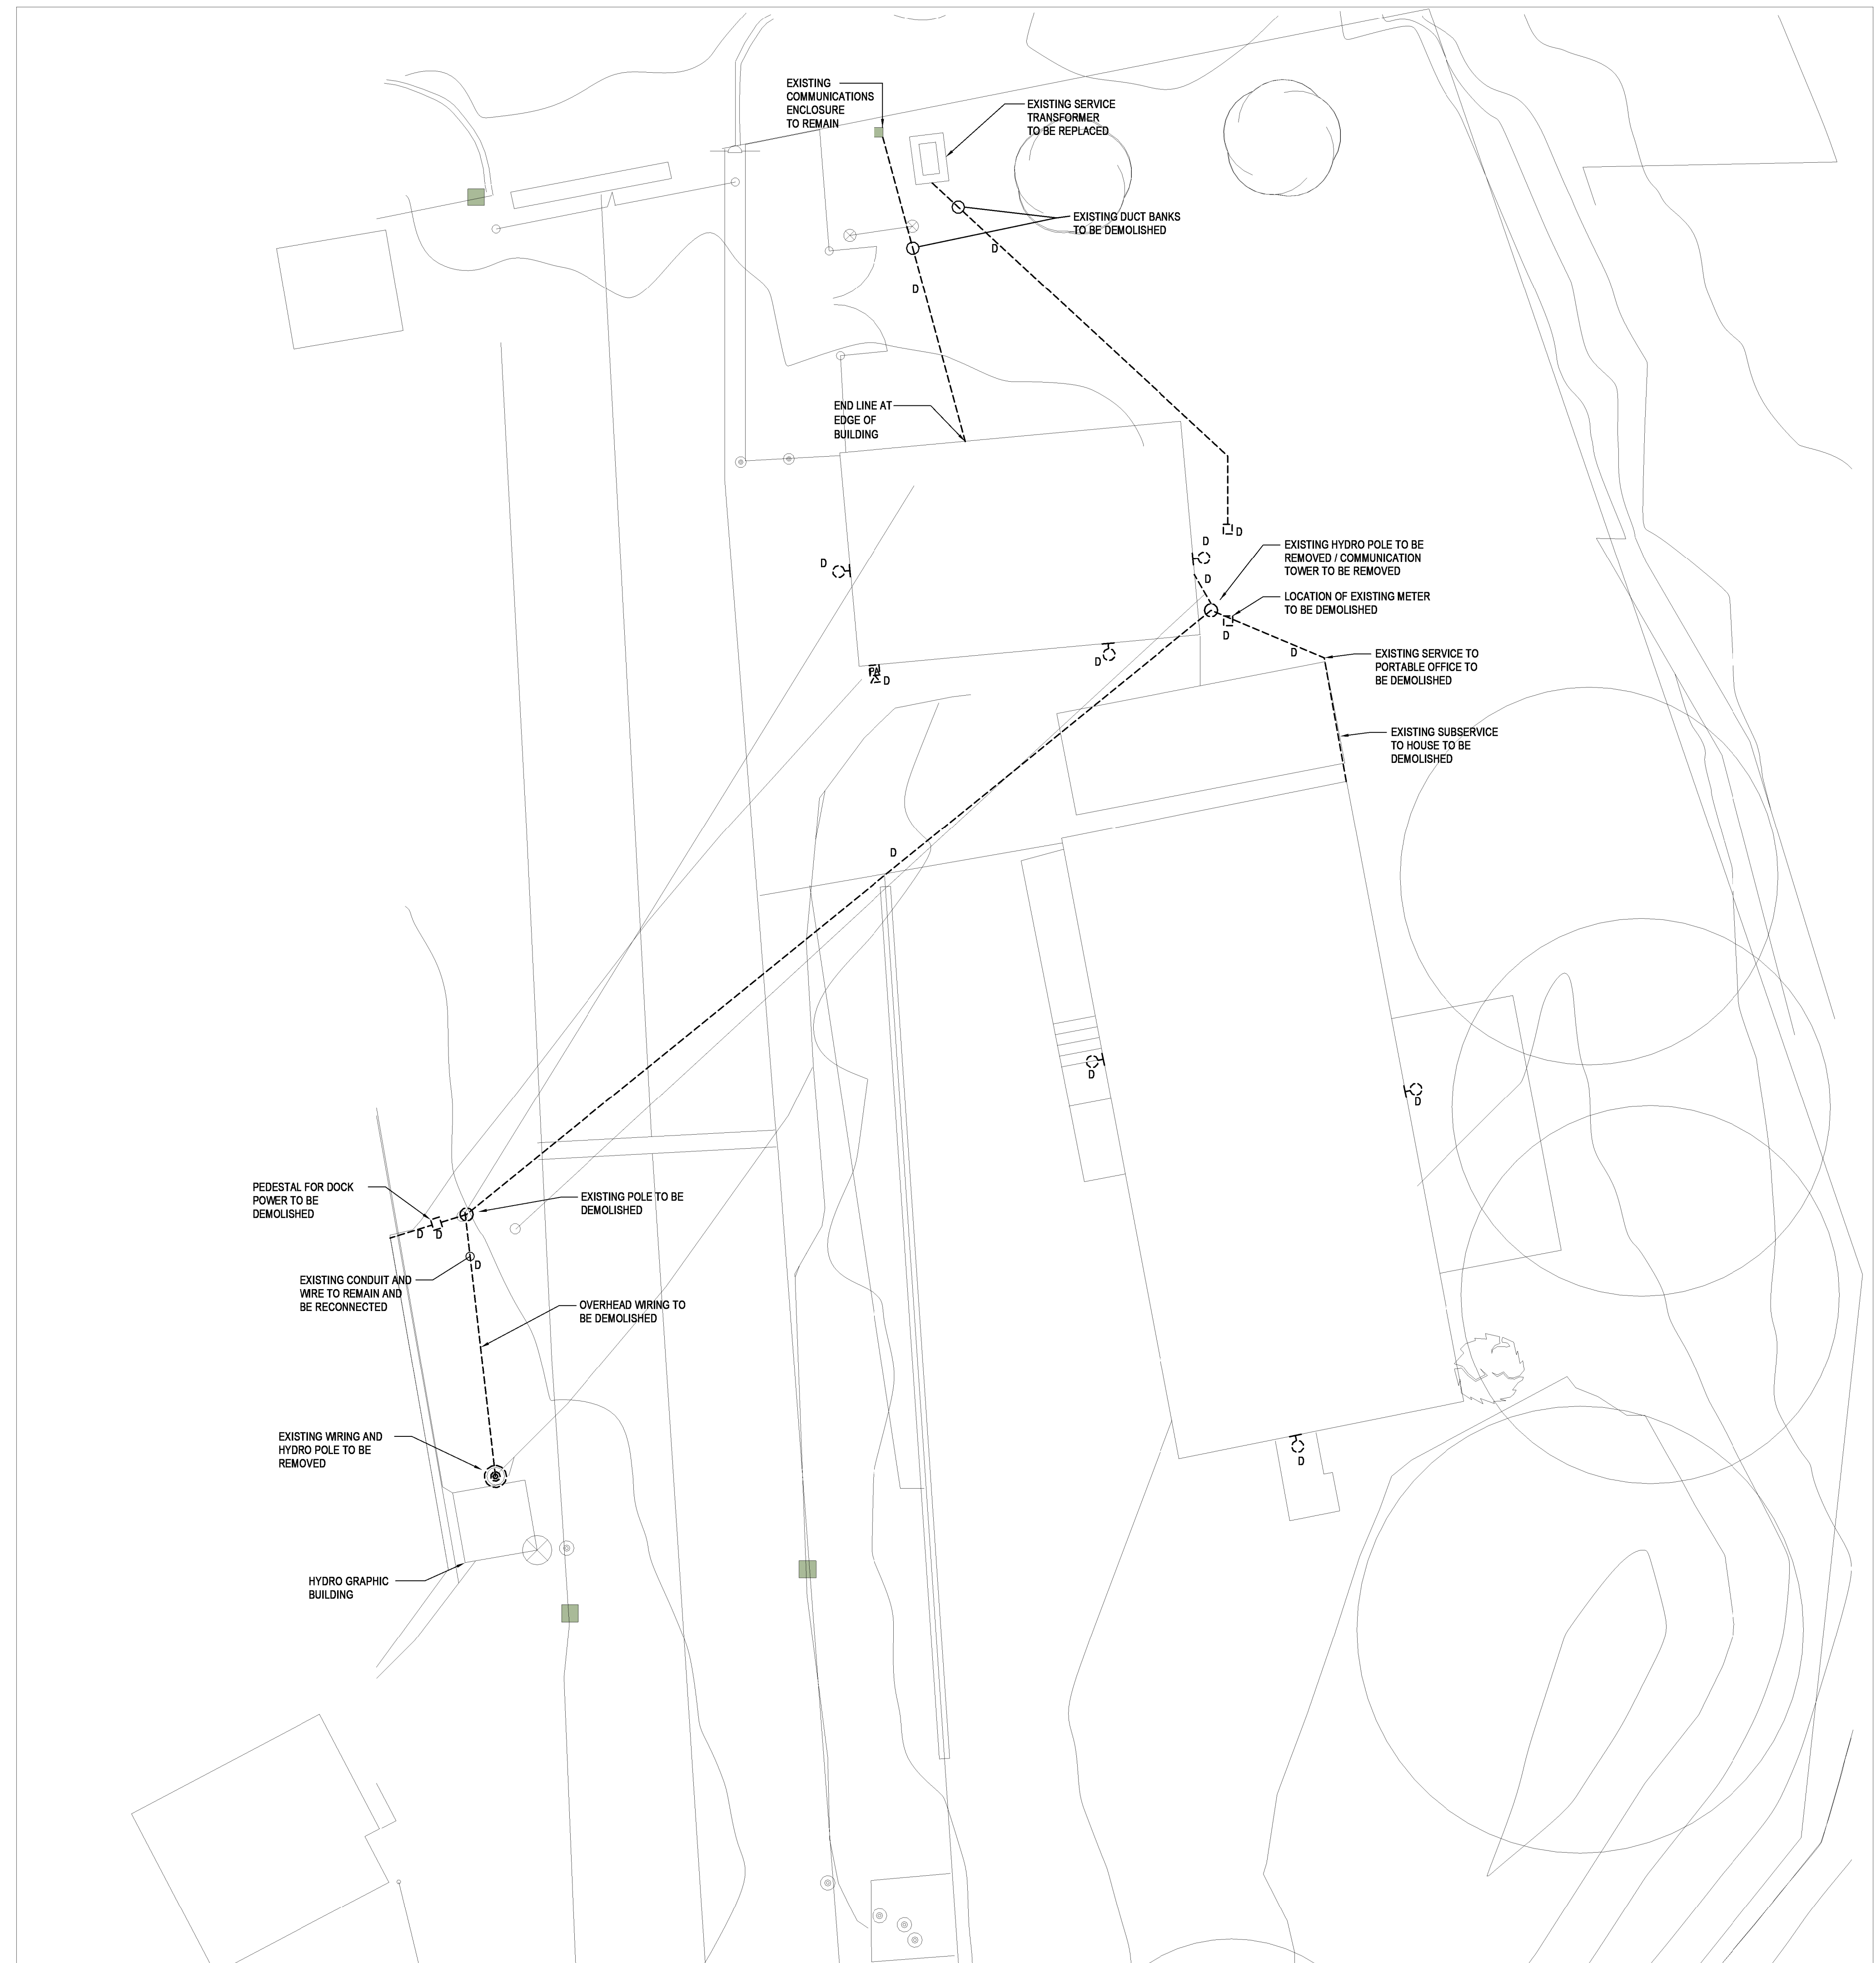

1 ELECTRICAL DEMOLITION POWER SITE PLAN LAYOUT
 1 : 100 0 1 2 3 4 5
 2 1 SCALE 1:100

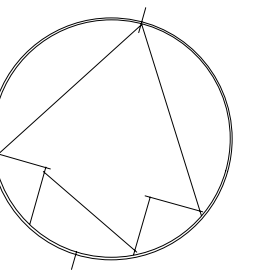

NORHT ARROW



No	DATE	REVISION	BY
C	2020-12-17	ISSUED FOR TENDER	C.M.S.
B	2020-10-07	ISSUED FOR 100% SUBMISSION	C.M.S.
A	2020-06-30	RE-ISSUED FOR 90% SUBMISSION	C.M.S.

Do not scale drawings. Verify all dimensions and conditions on site and immediately notify the Departmental Representative of all discrepancies.

A	Detail No.
B	drawing no. - where detail required
C	drawing no. - where detailed

project title
 titre du projet
COBURG
 COBURG CITY

COBURG SEARCH AND RESCUE STATION

drawing title
 titre du dessin
ELECTRICAL GENERAL DEMOLITION POWER SITE PLAN LAYOUT

drawn by
 dessiné par
T. CLARK

designed by
 conçu par
C. SITKOWSKI

approved by
 approuvé par
M. MOORE

bid office
 projet manager
 administrateur de projets
ELISABETH OHI

project date
 date du projet
20-03-2019

project no.
 no. du projet
R.084112.005

drawing no.
 dessiné no.
E100