

No.	DATE	REVISION	BY
E	2020-12-17	ISSUED FOR TENDER	M.W.
D	2020-10-07	ISSUED FOR 100% REVIEW	M.W.
C	2020-06-26	RE-ISSUED FOR 99% REVIEW	M.W.
B	2020-01-31	ISSUED FOR 99% REVIEW	C.M.
A	2019-03-29	ISSUED FOR 66% REVIEW	V.D.

Do not scale drawings. Verify all dimensions and conditions on site and immediately notify the Departmental Representative of all discrepancies.

- A Detail No. No. du détail
- B drawing no. - where detail required dessin no. - où détail exigé
- C drawing no. - where detailed dessin no. - où détaillé

project title
titre du projet

COBourg CITY

COBourg SEARCH AND RESCUE STATION

drawing title
titre du dessin
MECHANICAL HVAC LAYOUT - LEVEL 1

drawn by
dessiné par
H. EL-SABEH

designed by
conçu par
H. EL-SABEH



approved by
approuvé par
M. WALLACE

bid office
project manager
administrateur de projets

project date
date du projet
2020-06-30

project no.
no. du projet
R.084112.005

drawing no.
dessiné no.
M500

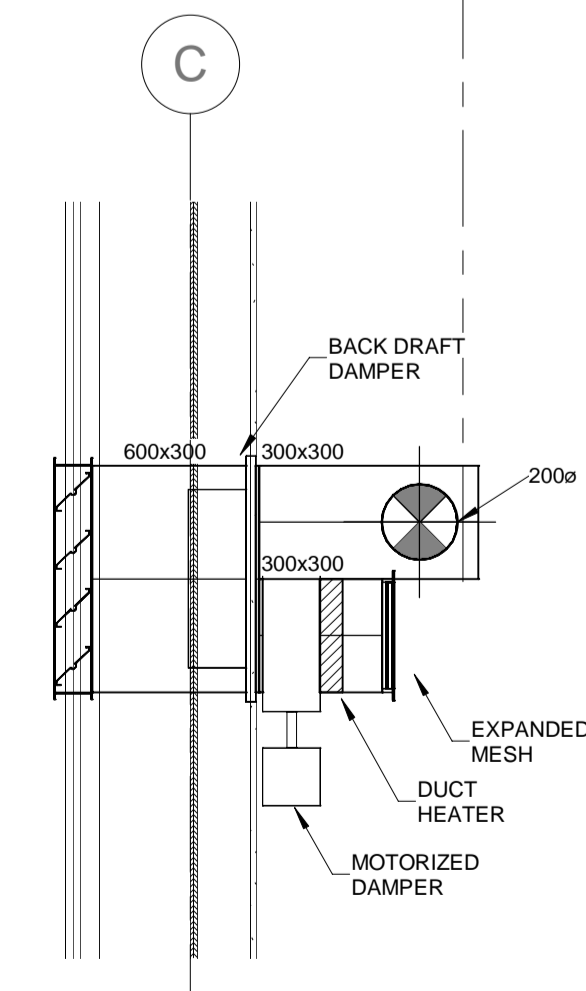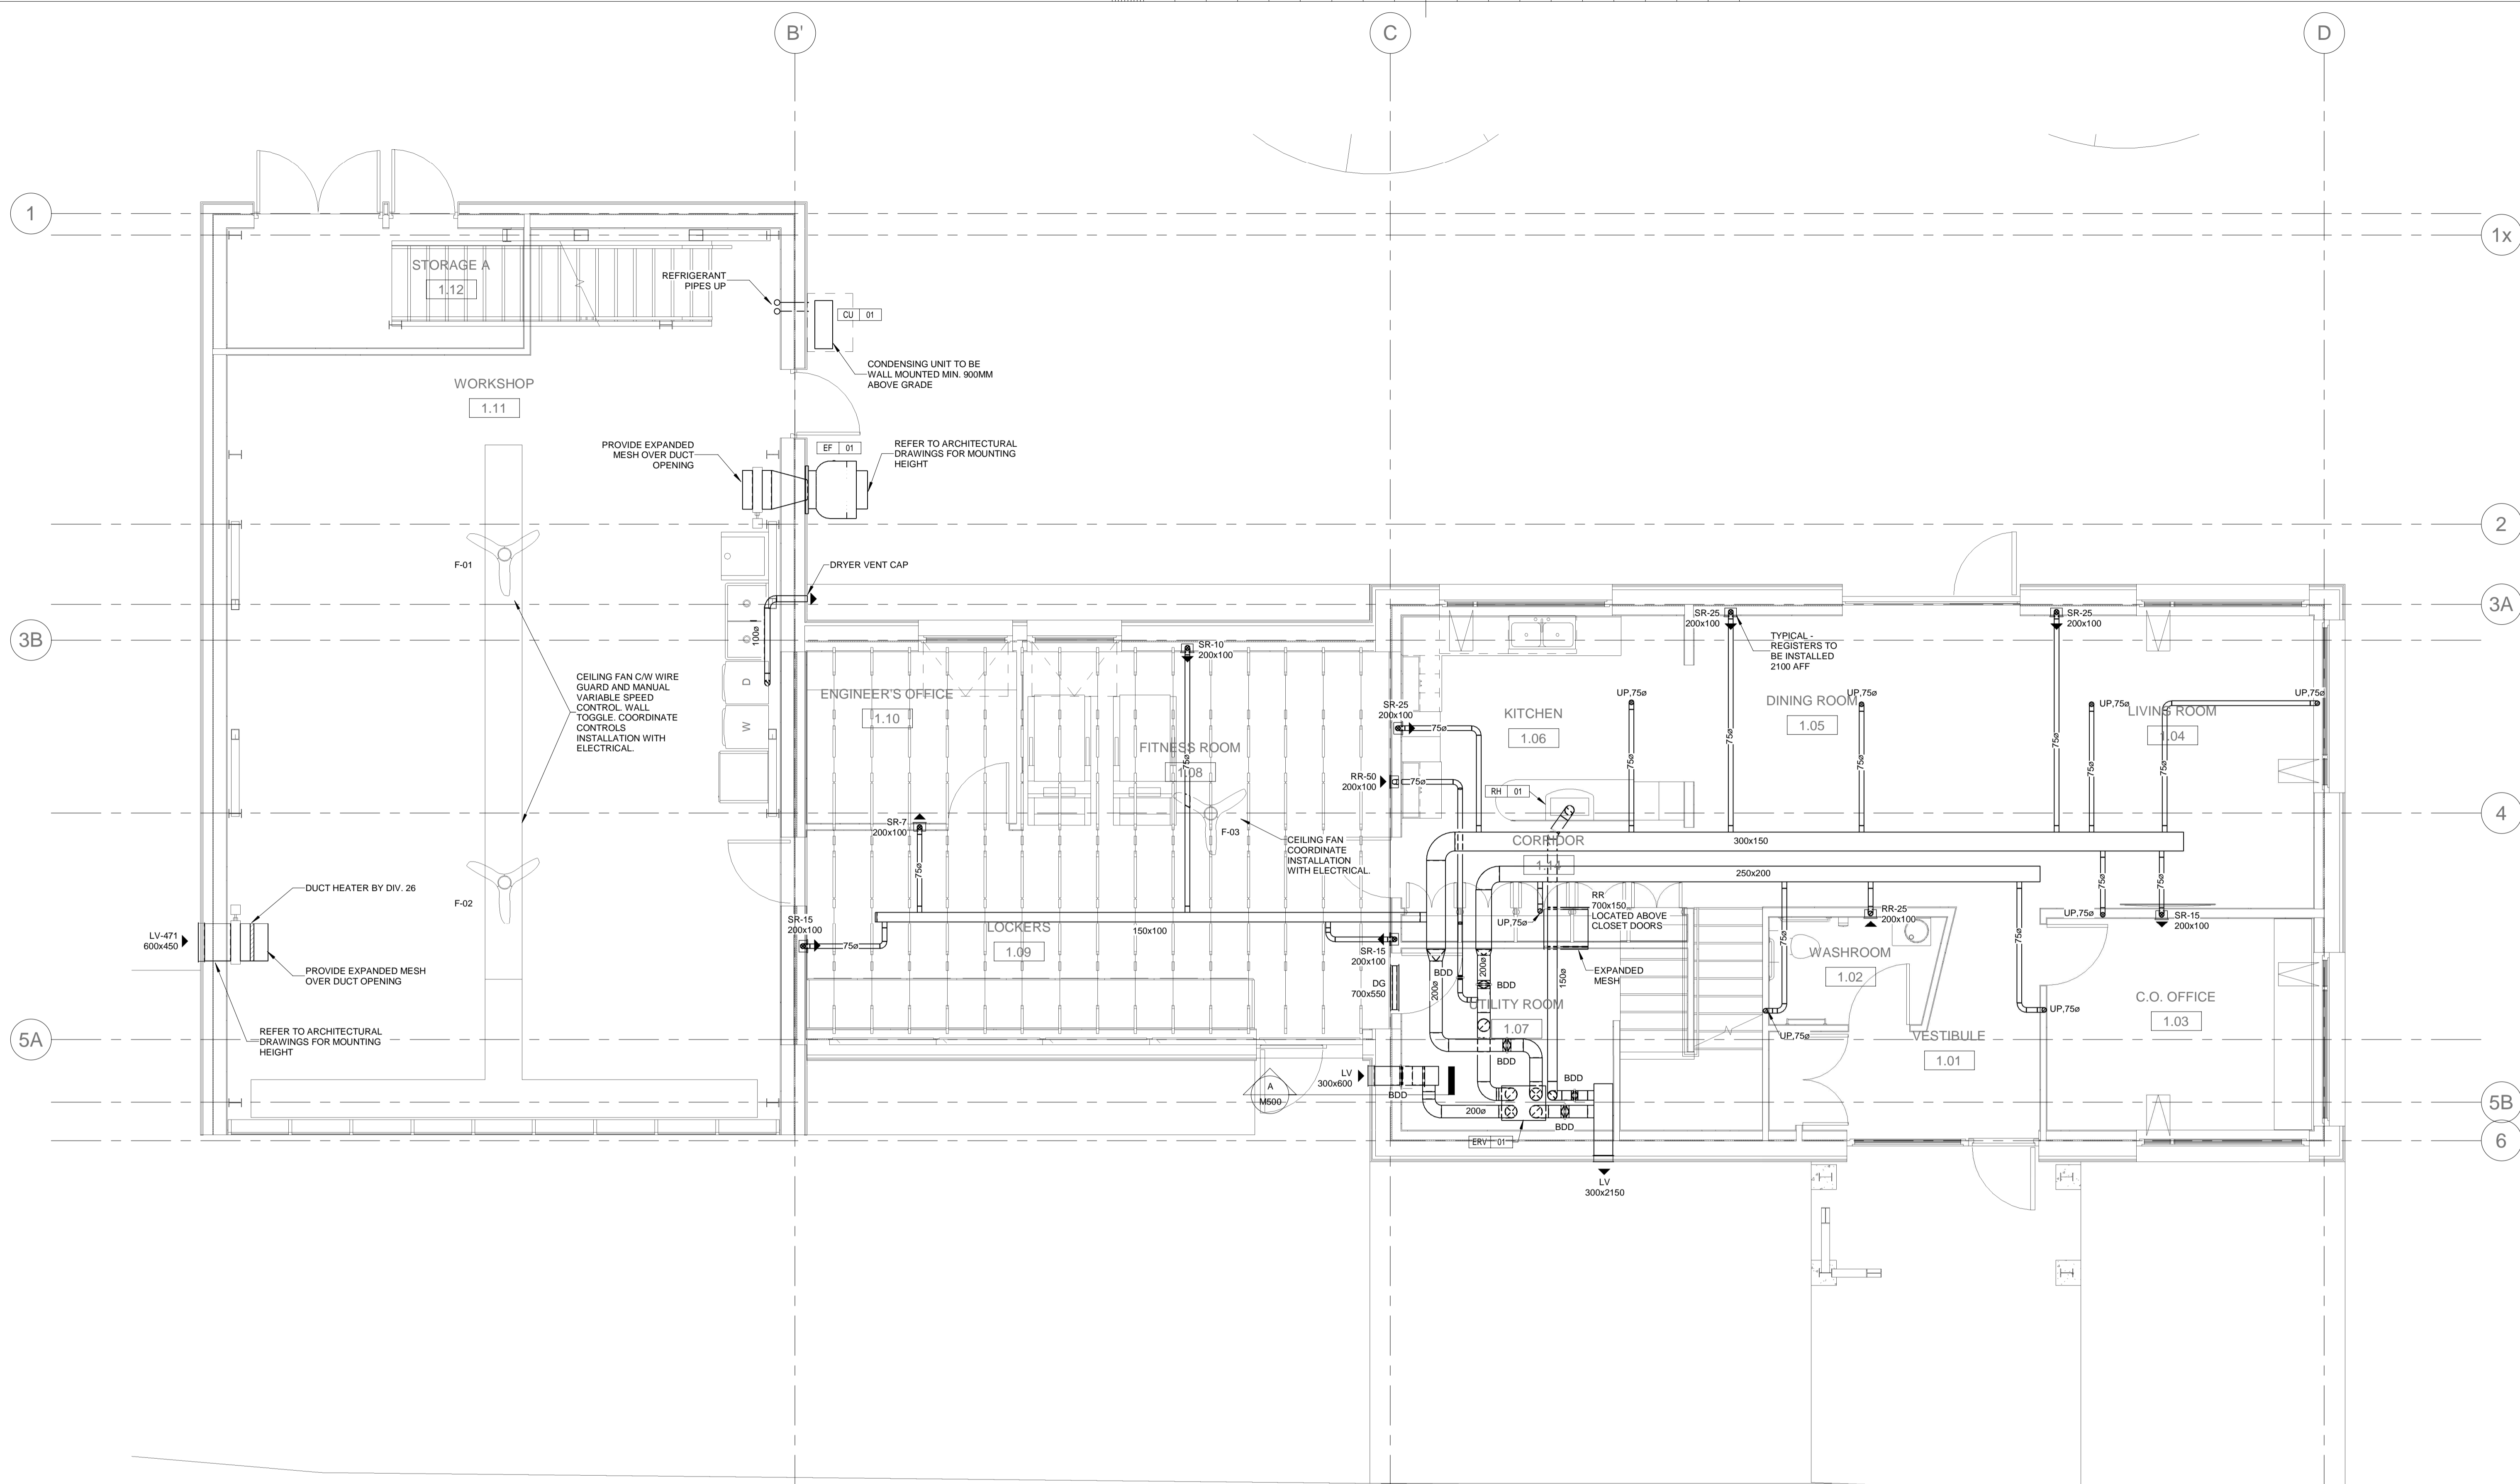

A SECTION A
M500 1:20